

FOR INFORMATION ONLY

PLAN SCALE 3/8" = 1'-0"

SECTION A-A SCALE 1/4" = 1'-0"


SECTION C-C SCALE 1/4" = 1'-0"

SECTION D-D SCALE 1/4" = 1'-0"

SECTION H-H SCALE 1/4" = 1'-0"

DETAIL A SCALE 1/4" = 1'-0"

NOTES -
 FOR DRAINAGE DETAILS & PIPE SLEEVES SEE DWG. 5-2, SH. 3
 FOR RAILING DETAILS SEE DWGS. 5-11 & 5-12, SH. 12 & 13
 FOR ELECTRICAL DETAILS SEE SHEET NO. 47 & 48

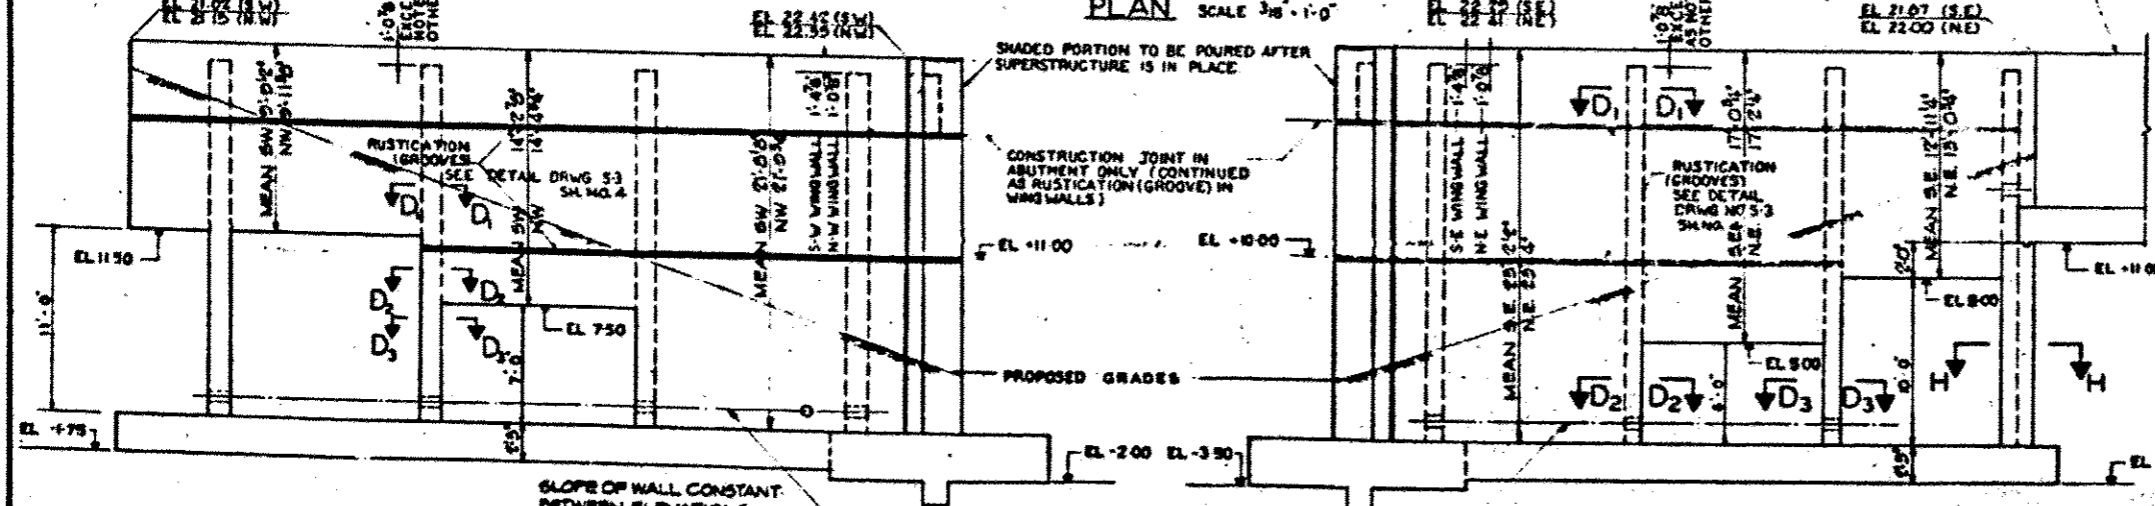

ELEVATION S-W WING WALL SCALE 3/8" = 1'-0"
 N-W WING WALL (SIMILAR EXCEPT WHERE NOTED)

ELEVATION S-E WING WALL SCALE 3/8" = 1'-0"
 N-E WING WALL (SIMILAR EXCEPT WHERE NOTED)

CONTRACT NO. 60J15
 SHEET NO. 114 OF 137

REVISIONS	
NO.	DESCRIPTION

DEPARTMENT OF HIGHWAYS
 COOK COUNTY, ILLINOIS

WINGWALLS
 63RD STREET GRADE SEPARATION
 OVER
 SOUTH ROUTE EXPRESSWAY

COMPUTED: H. M. H. PROJECT: 811-54-3(12)150
 DRAWN: E. M. S. SCALE: AS SHOWN
 CHECKED: E. M. C. APPROVED: [Signature]

APPROVED: [Signature] DATE: 12/6/94
 COUNTY: Cook COUNTY HIGHWAY: 94
 SHEET NO.: 5 OF 48 DRAWING NO.: S-4

BE LEW, CATHEN & COMPANY
 CONSULTING ENGINEERS