


F.A.P. RFE:	SECTION	COUNTY	TOTAL SHEETS	SHEET NO.
335	119R-2	LAKE	439	150
STA. 432+83.12		TO STA. 470+56.84		
FED. ROAD DIST. NO.		ILLINOIS	FED. AID PROJECT	
60B01				



DATE	BY
DATE	BY

DATE	BY
DATE	BY

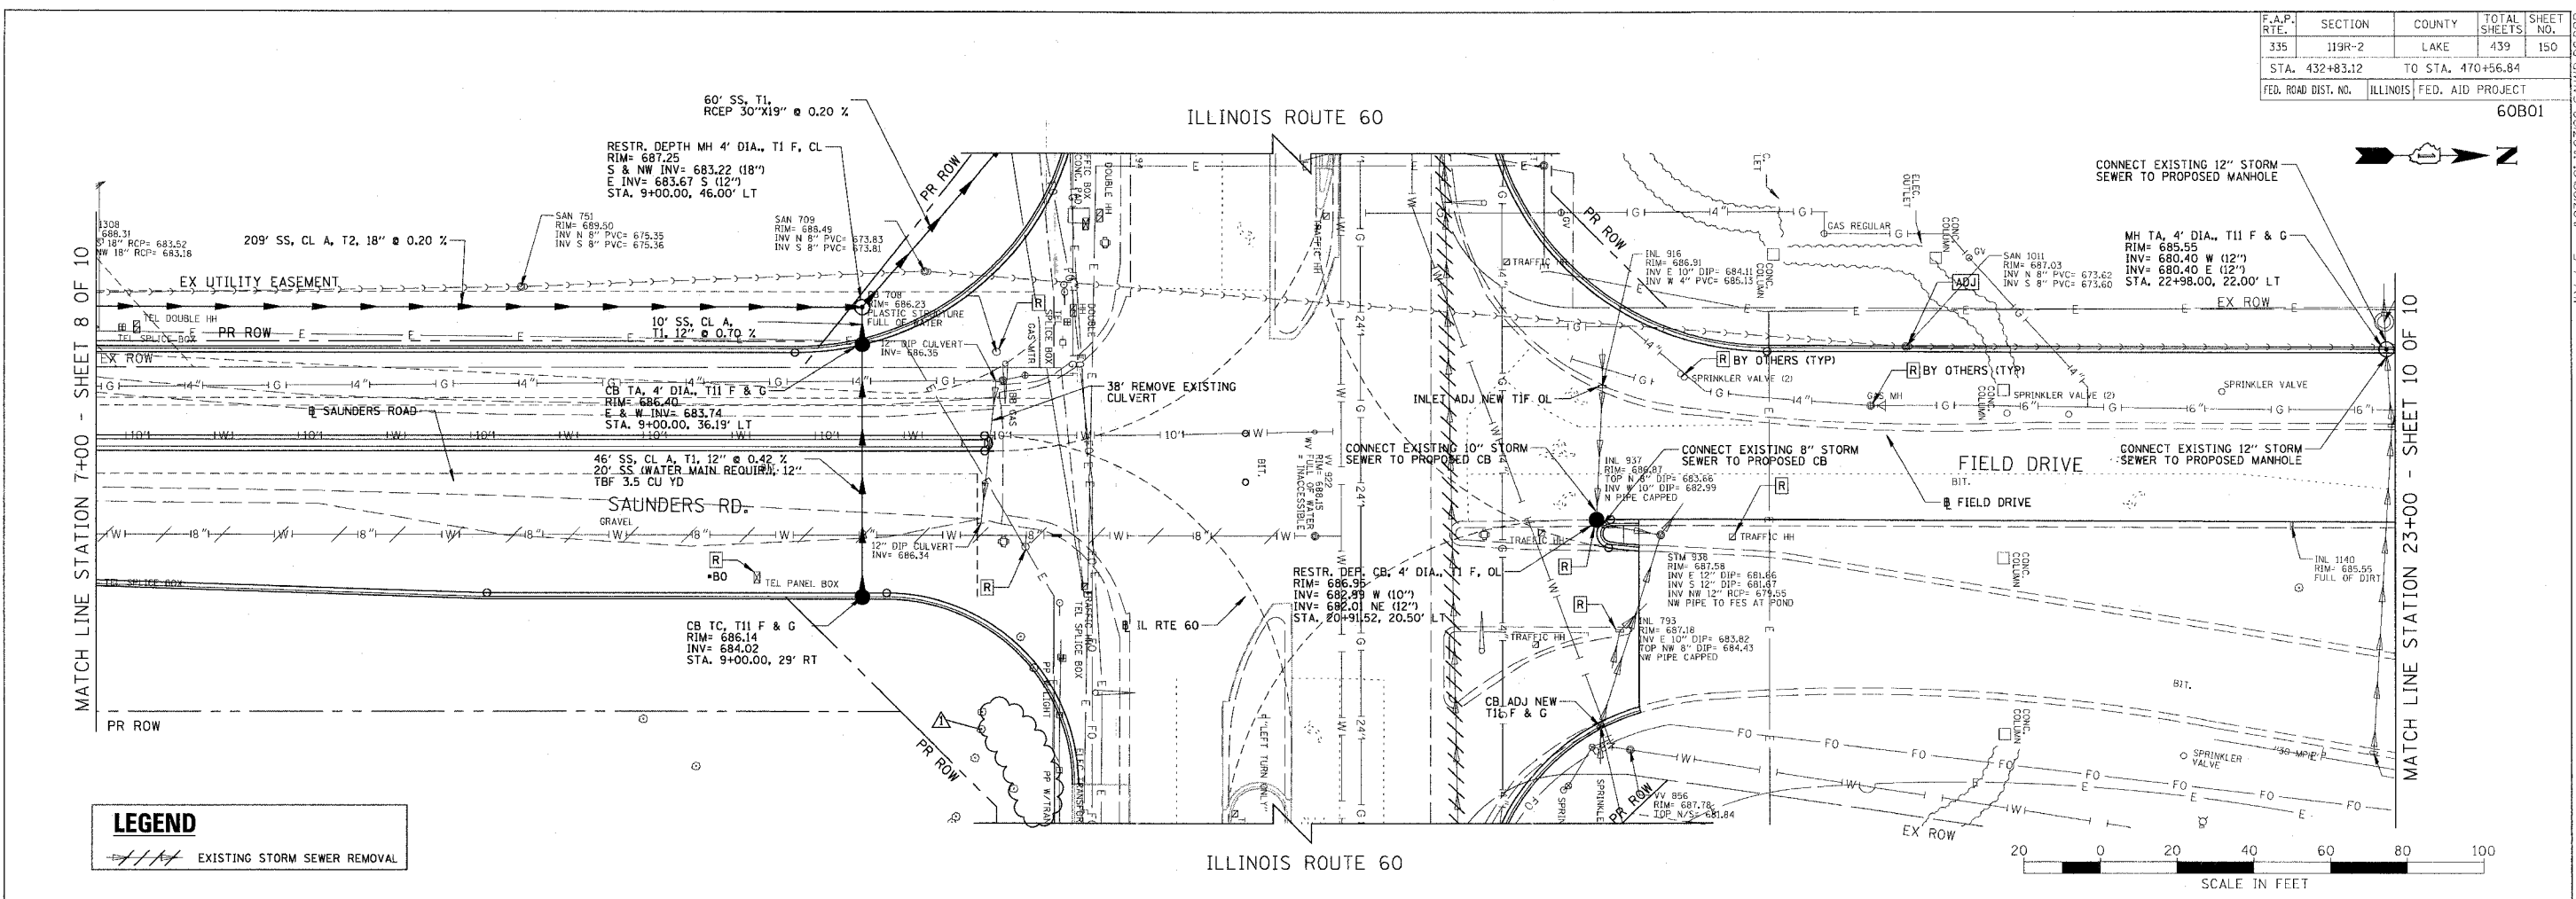

LEGEND

 --- EXISTING STORM SEWER REMOVAL

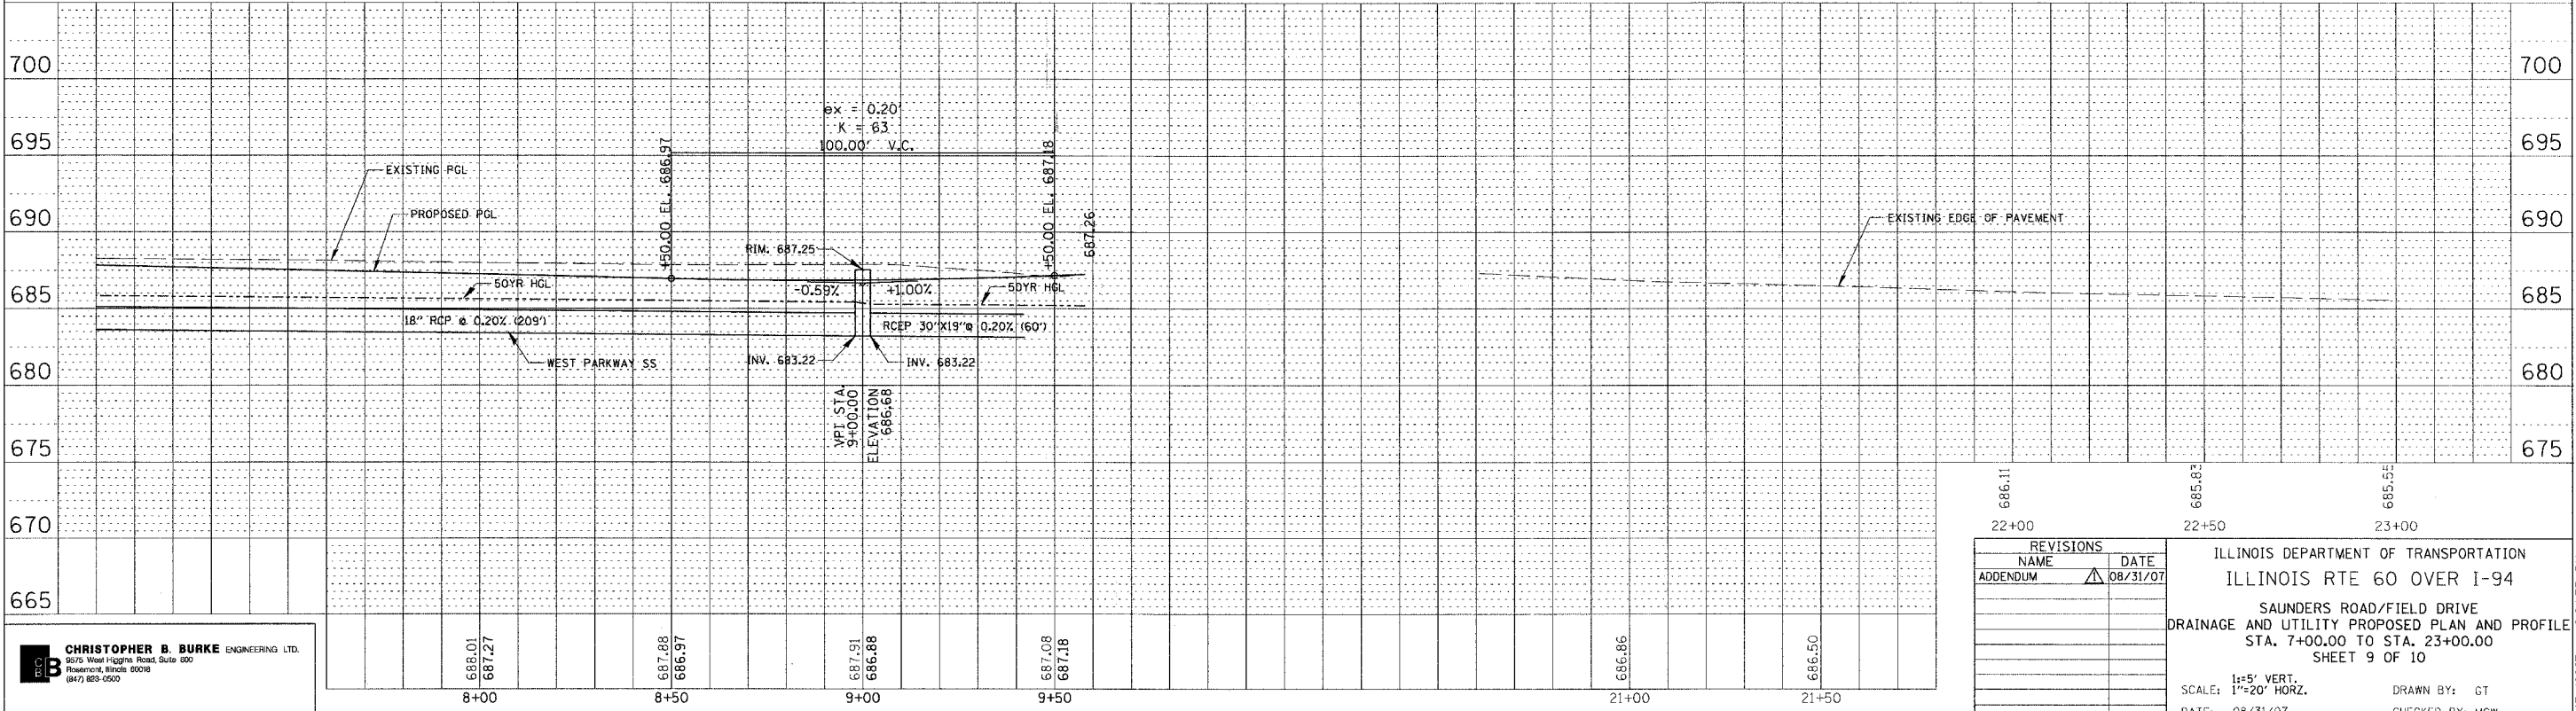

CHRISTOPHER B. BURKE ENGINEERING LTD.
 9075 West Higgins Road, Suite 600
 Rosemont, Illinois 60018
 (847) 823-0500

REVISIONS	
NAME	DATE
ADDENDUM	08/31/07

ILLINOIS DEPARTMENT OF TRANSPORTATION
ILLINOIS RTE 60 OVER I-94
 SAUNDERS ROAD/FIELD DRIVE
 DRAINAGE AND UTILITY PROPOSED PLAN AND PROFILE
 STA. 7+00.00 TO STA. 23+00.00
 SHEET 9 OF 10

1"=5' VERT.
 1"=20' HORZ.
 DATE: 08/31/07

DRAWN BY: GT
 CHECKED BY: MCW

N:\Later\60B01\92\CIV\NO.9192_SAUND-02.DWG 8/31/2007 2:04:35 PM