


F.A.P. RTE.	SECTION	COUNTY	TOTAL SHEETS	SHEET NO.
335	119R-2	LAKE	439	240
STA. 465+00		TO STA. 478+00		
FED. ROAD DIST. NO. 1		ILLINOIS		FED. AID PROJECT

60B01

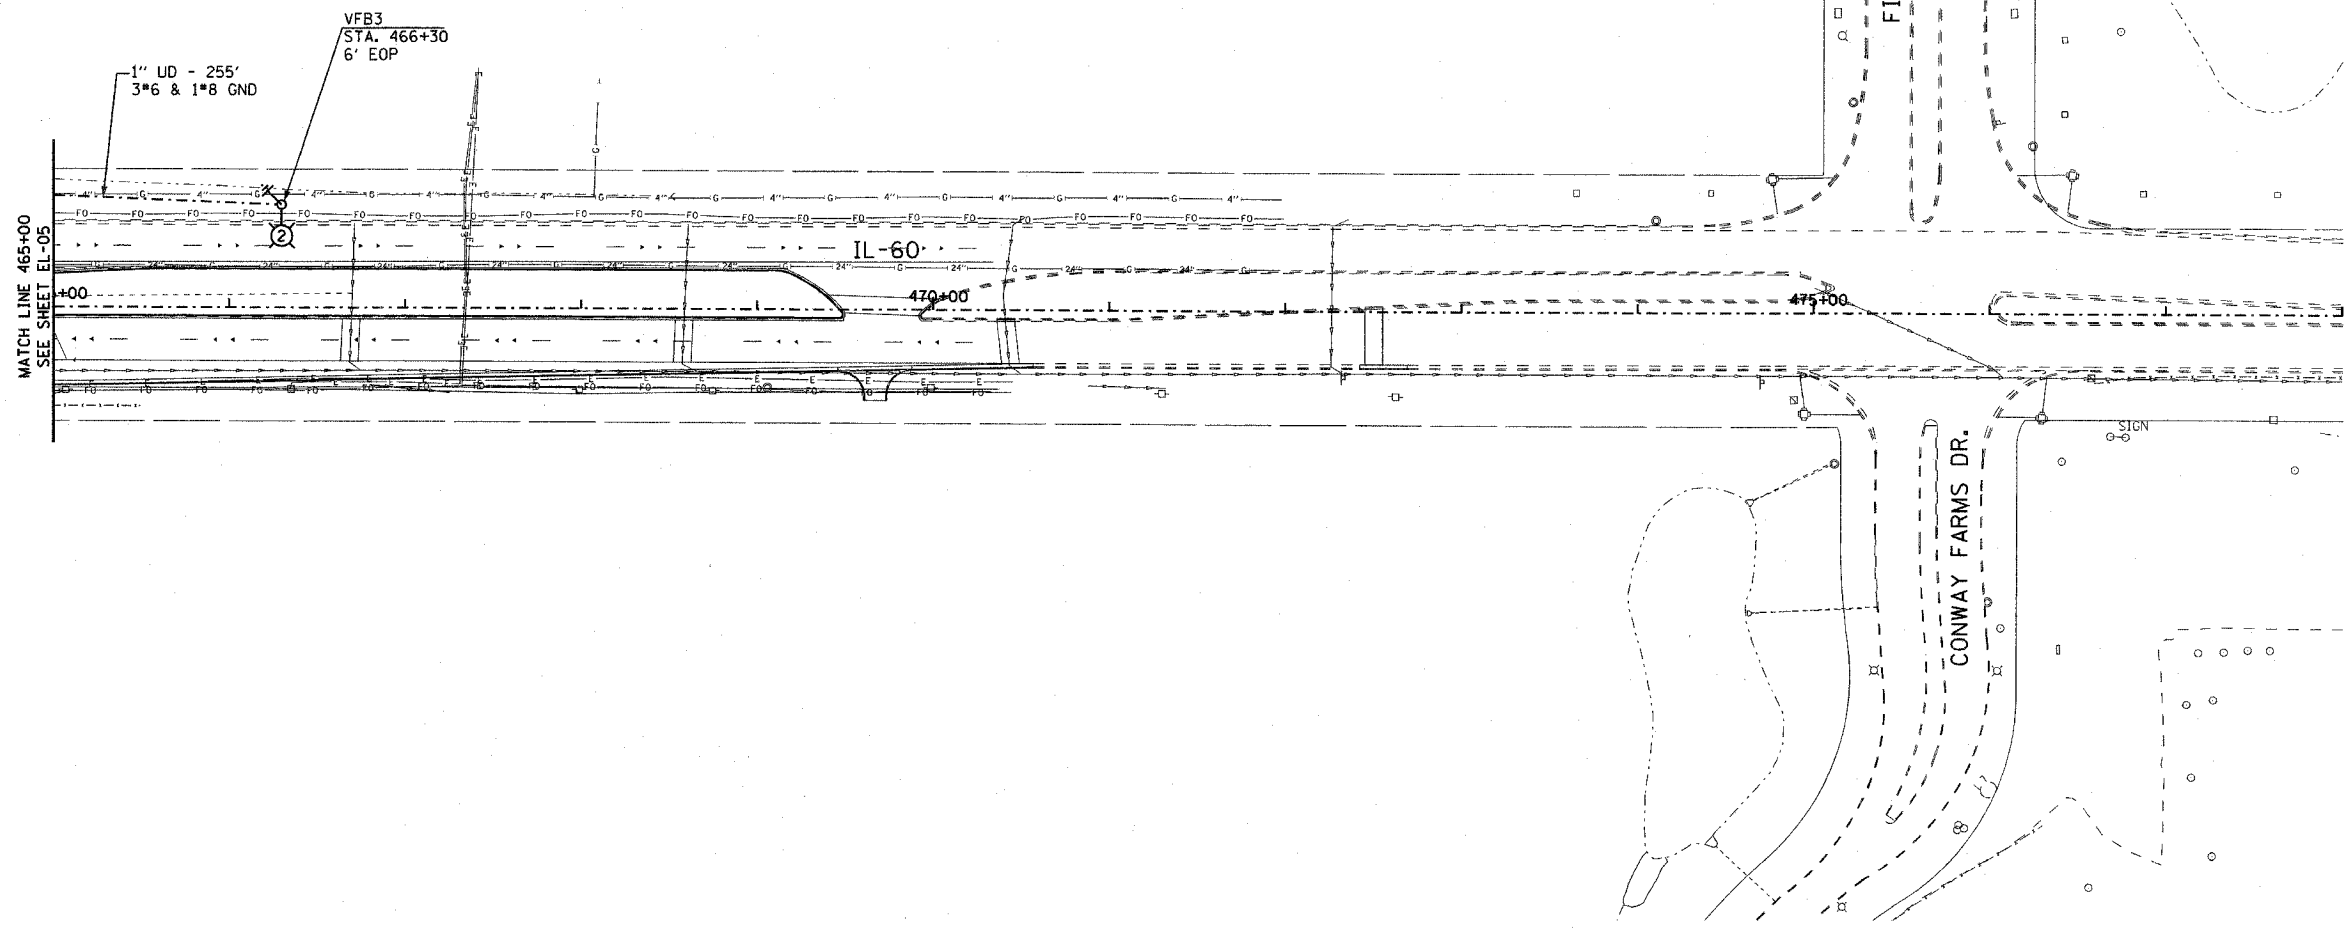

SHEET EL-06 OF 13

REVISIONS	
NAME	DATE

ILLINOIS DEPARTMENT OF TRANSPORTATION  
 ILLINOIS RTE 60 OVER I-94  
 PROPOSED ROADWAY LIGHTING PLAN  
 STA. 465+00 TO STA. 478+00

S.N. \_\_\_\_\_ DESIGNED BY: JDM  
 SCALE: 1"=50'-0" DRAWN BY: JDM  
 DATE: MAY 8, 2007 CHECKED BY: RES

**EJM** ENGINEERING, INC.  
 411 South Wells Street Suite 800  
 Chicago, Illinois 60607