


BUFFALO GROVE HIGH SCHOOL ATHLETIC FIELD


F.A. NO.	SECTION	COUNTY	TOTAL SHEETS	SHEET NO.
03-0087-00-LT	COOK	20	6	
DUNDEE ROAD STA. 25+25 TO STA. 35+25				
FED. ROAD DISTRICT	ALIKINS	FED. AID PROJECT		

POLE NUMBER	CONTROLLER NO.	STATION	OFFSET	LIGHT CIRCUIT	FOUNDATION TYPE
24	BG1	25+48	3' B.C.	E	SP
25	BG1	27+20	3' B.C.	F	SP
26	BG1	28+90	3' B.C.	E	24
36	BG1	25+48	3' B.C.	G	24
37	BG1	27+20	3' B.C.	H	24
38	BG1	28+90	3' B.C.	G	24

**FOUNDATION TYPE**  
 24 = LIGHT POLE FOUNDATION, 24" DIAMETER  
 OS = LIGHT POLE FOUNDATION, 24" DIAMETER, OFFSET  
 SP = LIGHT POLE FOUNDATION (SPECIAL)  
 EX = EXISTING FOUNDATION

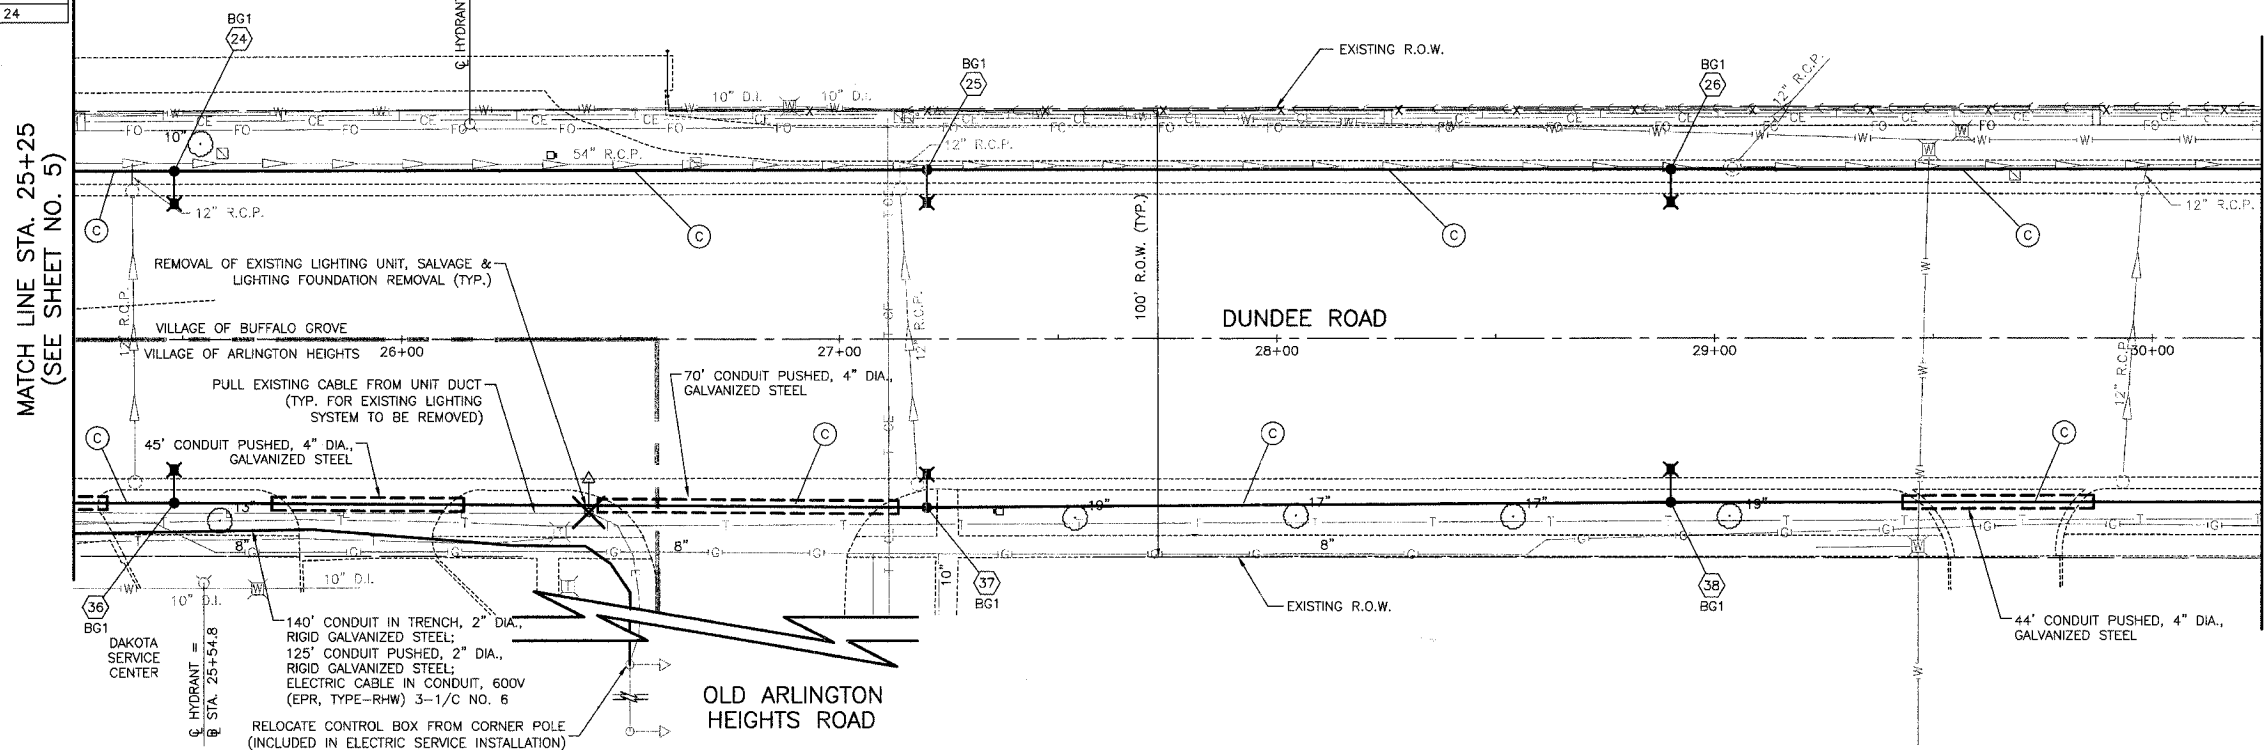

POLE NUMBER	CONTROLLER NO.	STATION	OFFSET	LIGHT CIRCUIT	CONTROLLER NO.
27	BG1	29+60	3' B.C.	F	24
28	BG1	32+25	3' B.C.	E	24
29	BG1	33+88	3' B.C.	F	SP
39	BG1	29+60	3' B.C.	H	24
40	BG1	32+25	3' B.C.	G	24
41	BG1	33+88	3' B.C.	H	24

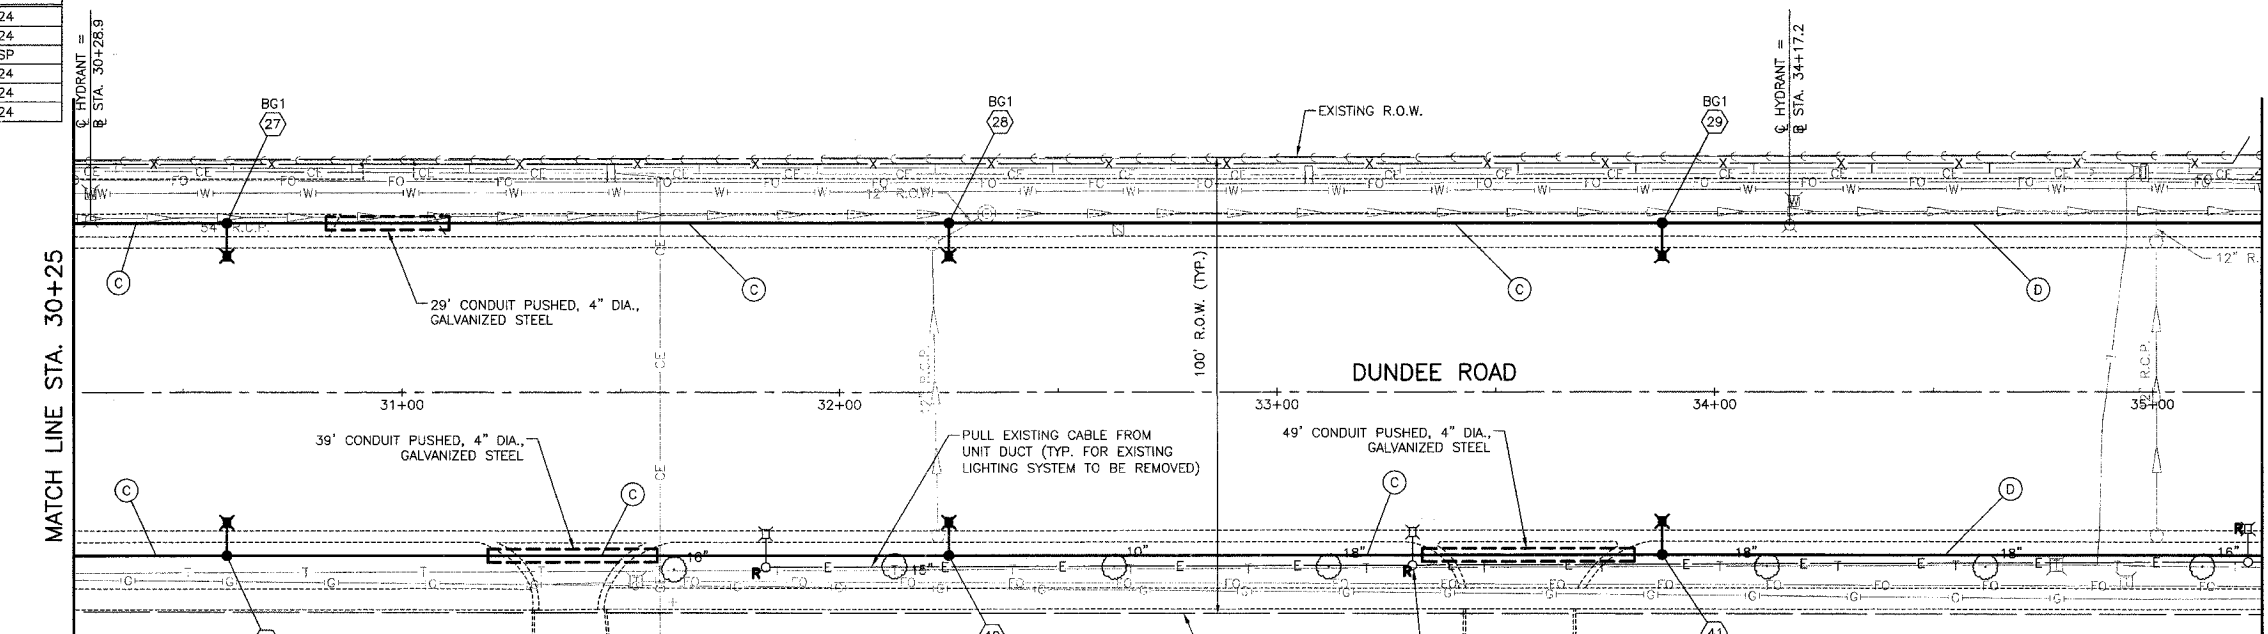

- (A) UNIT DUCT, WITH 4-1/2\"/>
- (B) UNIT DUCT, WITH 2-1/2\"/>
- (C) UNIT DUCT, WITH 4-1/2\"/>
- (D) UNIT DUCT, WITH 2-1/2\"/>

RELOCATE EXISTING LIGHTING UNIT, LIGHTING FOUNDATION REMOVAL, REMOVAL OF EXISTING LUMINAIRE, AND INSTALL NEW LUMINAIRE, SODIUM VAPOR, HORIZONTAL MOUNT, 250 WATT (TYP.)

NO.	REVISIONS

VILLAGE OF BUFFALO GROVE  
**DUNDEE ROAD LIGHTING IMPROVEMENT**  
**LIGHTING PLAN**  
 DUNDEE ROAD  
 STA. 25+25 TO STA. 35+25

DESIGNED BY: S.J.C.  
 CHECKED BY: D.N.M.  
 DATE: 07/10/2007

SCALE IN FEET