


| F.A. REL. | SECTION | COUNTY | TOTAL SHEETS | SHEET NO. |
|------------------------|----------------|------------------|--------------|-----------|
| | 03-00087-00-LT | COOK | 20 | 10 |
| DUNDEE ROAD STA. 64+75 | | TO STA. 66+00 | | |
| FED. ROAD DISTRICT | ILLINOIS | FED. AID PROJECT | | |

| POLE NUMBER | CONTROLLER NO. | STATION | OFFSET | LIGHT CIRCUIT | FOUNDATION TYPE |
|-------------|----------------|---------|---------|---------------|-----------------|
| 37 | BG2 | 64+80 | 3' B.C. | F | 24 |
| 38 | BG2 | 65+04 | 3' B.C. | E | 24 |
| 39 | BG2 | 65+65 | 3' B.C. | F | 24 |
| 50 | BG2 | 64+80 | 3' B.C. | H | 24 |
| 51 | BG2 | 65+03 | 3' B.C. | G | 24 |
| 52 | BG2 | 65+68 | 3' B.C. | H | 24 |

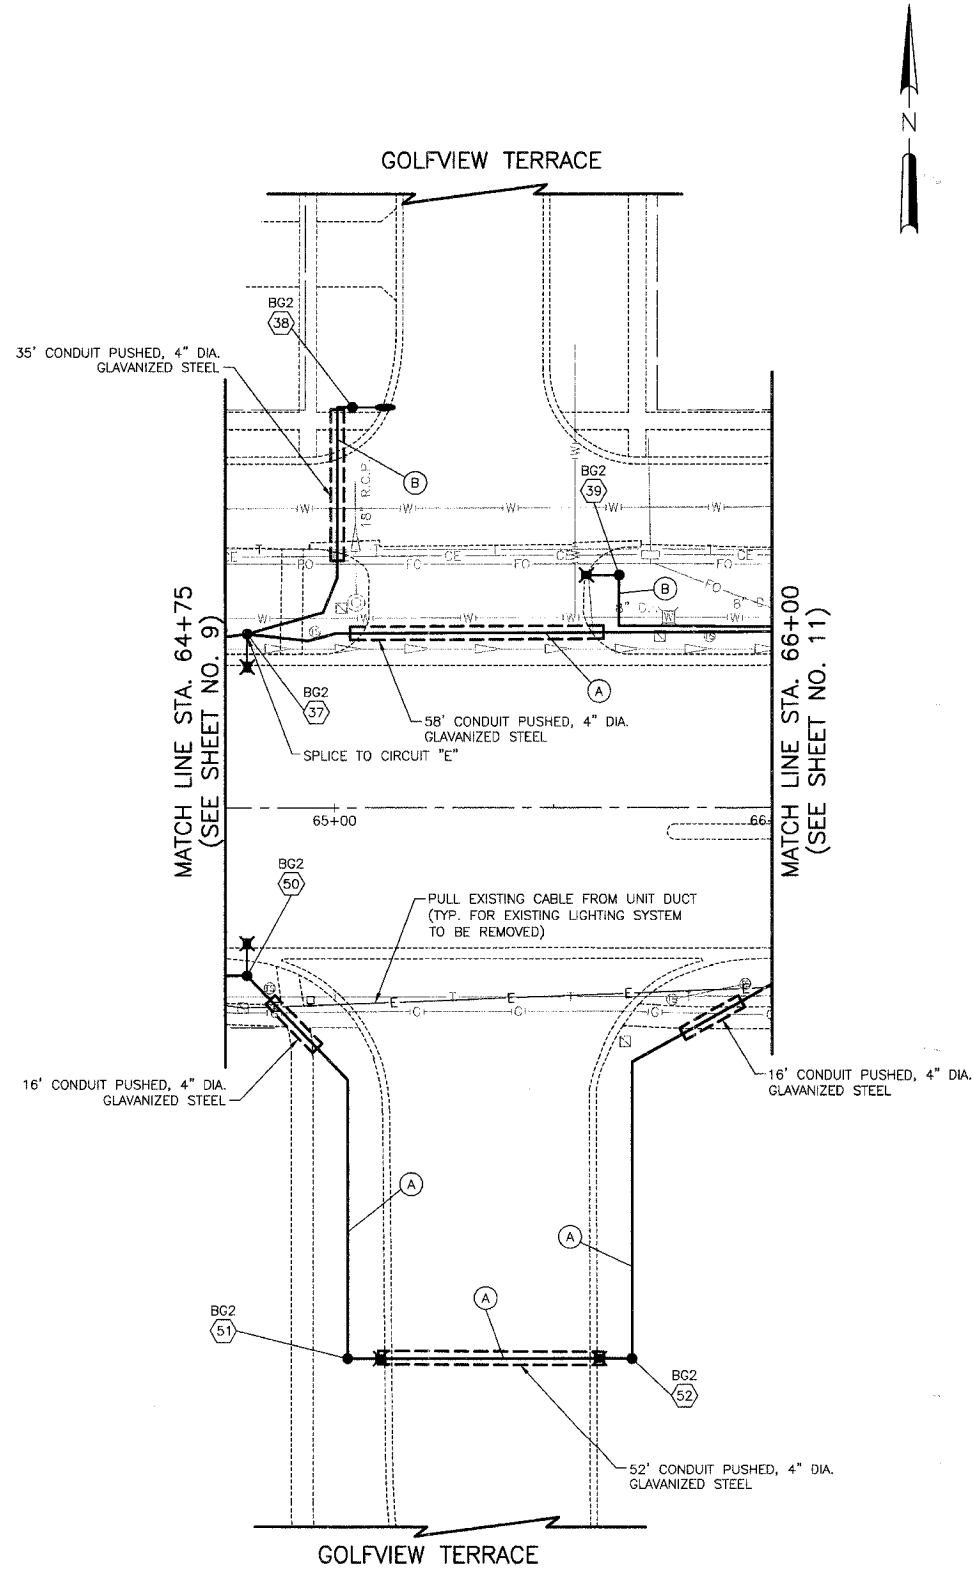

| NO. | REVISIONS |
|-----|-----------|
| | |
| | |
VILLAGE OF BUFFALO GROVE
DUNDEE ROAD LIGHTING IMPROVEMENT
LIGHTING PLAN
 DUNDEE ROAD
 STA. 64+75 TO STA. 66+00

DESIGNED BY: S.J.C.
 CHECKED BY: D.N.M.
 DATE: 07/10/2007

SCALE IN FEET