


POLE NUMBER	CONTROLLER NO.	STATION	OFFSET	LIGHT CIRCUIT	FOUNDATION TYPE
15	BG3	101+65	3' B.C.	E	OS
16	BG3	103+15	3' B.C.	F	OS
17	BG3	104+80	3' B.C.	E	24
26	BG3	101+65	6' B.C.	G	24
27	BG3	103+15	6' B.C.	H	24
28	BG3	104+80	6' B.C.	G	24

F.A. NO.	SECTION	COUNTY	TOTAL SHEETS	SHEET NO.
03-00087-00-LT	COOK	20	14	
DUNDEE ROAD STA. 100+75 TO STA. 110+75				
FED. ROAD DISTRICT	ILLINOIS	FED. AID PROJECT		

GROVE TERRACE CONDO

**FOUNDATION TYPE**  
 24 = LIGHT POLE FOUNDATION, 24" DIAMETER  
 OS = LIGHT POLE FOUNDATION, 24" DIAMETER, OFFSET  
 SP = LIGHT POLE FOUNDATION (SPECIAL)  
 EX = EXISTING FOUNDATION

MATCH LINE STA. 100+75  
(SEE SHEET NO. 13)

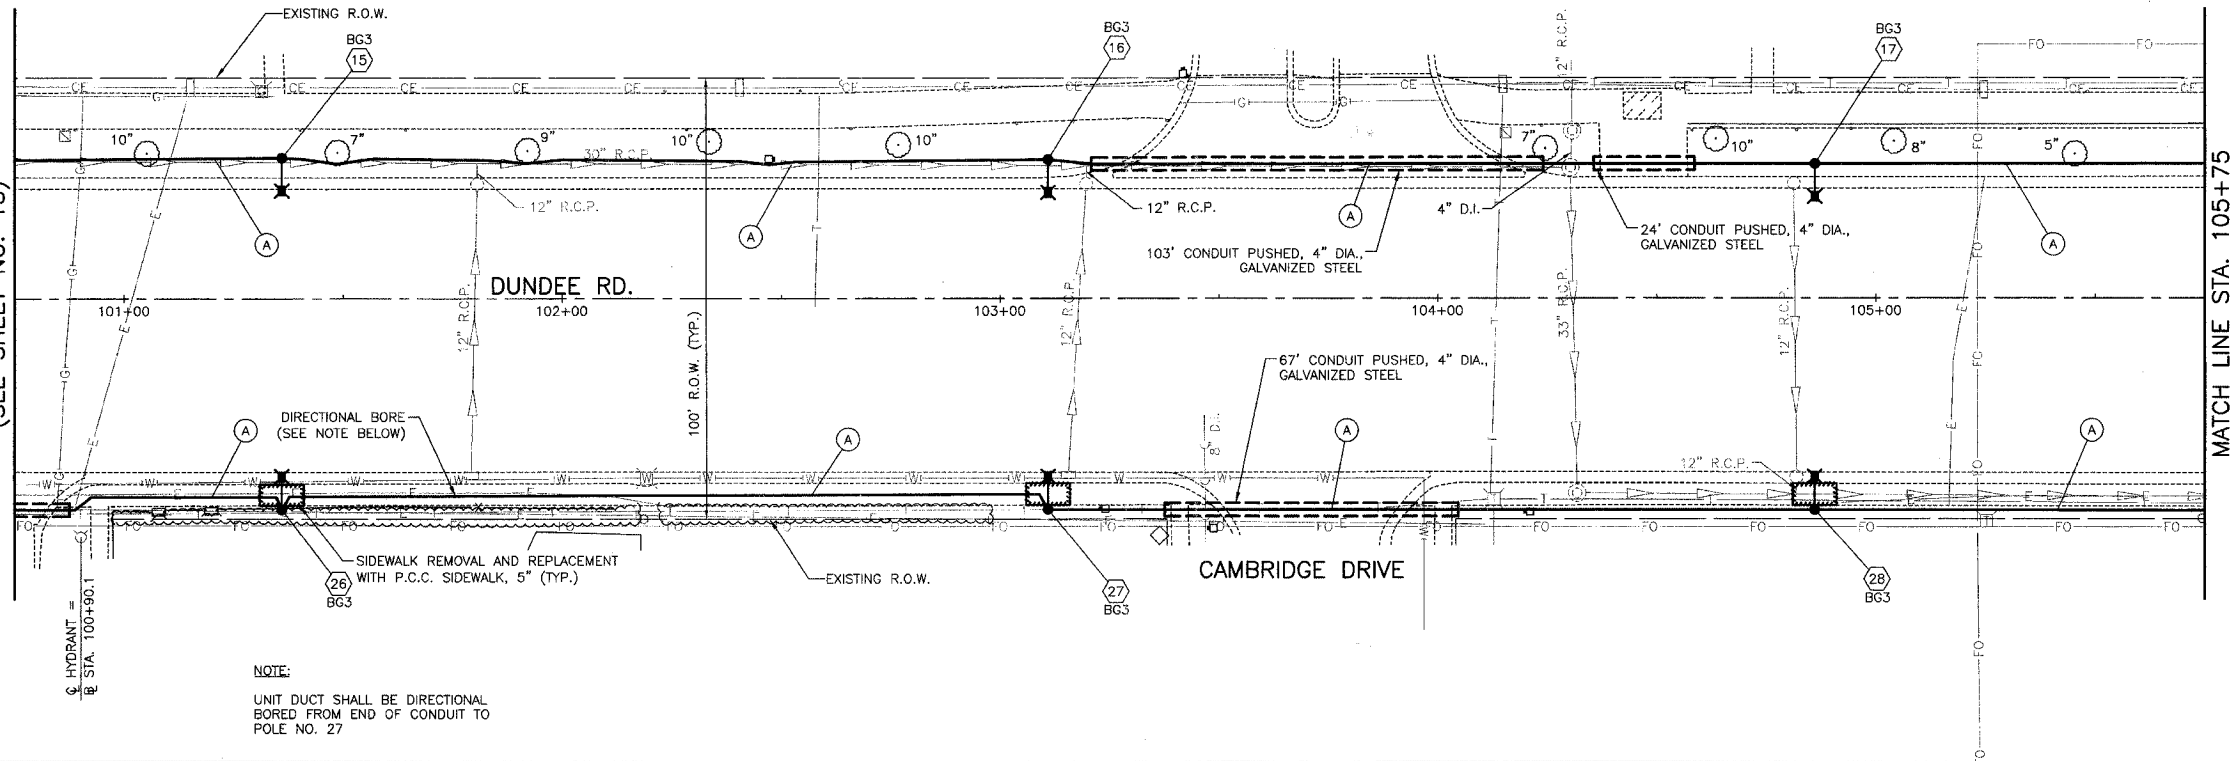


**NOTE:**  
 UNIT DUCT SHALL BE DIRECTIONAL BORED FROM END OF CONDUIT TO POLE NO. 27

POLE NUMBER	CONTROLLER NO.	STATION	OFFSET	LIGHT CIRCUIT	FOUNDATION TYPE
18	BG3	106+55	3' B.C.	F	24
19	BG3	108+30	3' B.C.	E	24
20	BG3	110+05	3' B.C.	F	24
29	BG3	106+55	6' B.C.	H	24
30	BG3	108+30	6.5' B.C.	G	24
31	BG3	110+05	6' B.C.	H	24

END IMPROVEMENT  
 STA. 110+05

MATCH LINE STA. 105+75

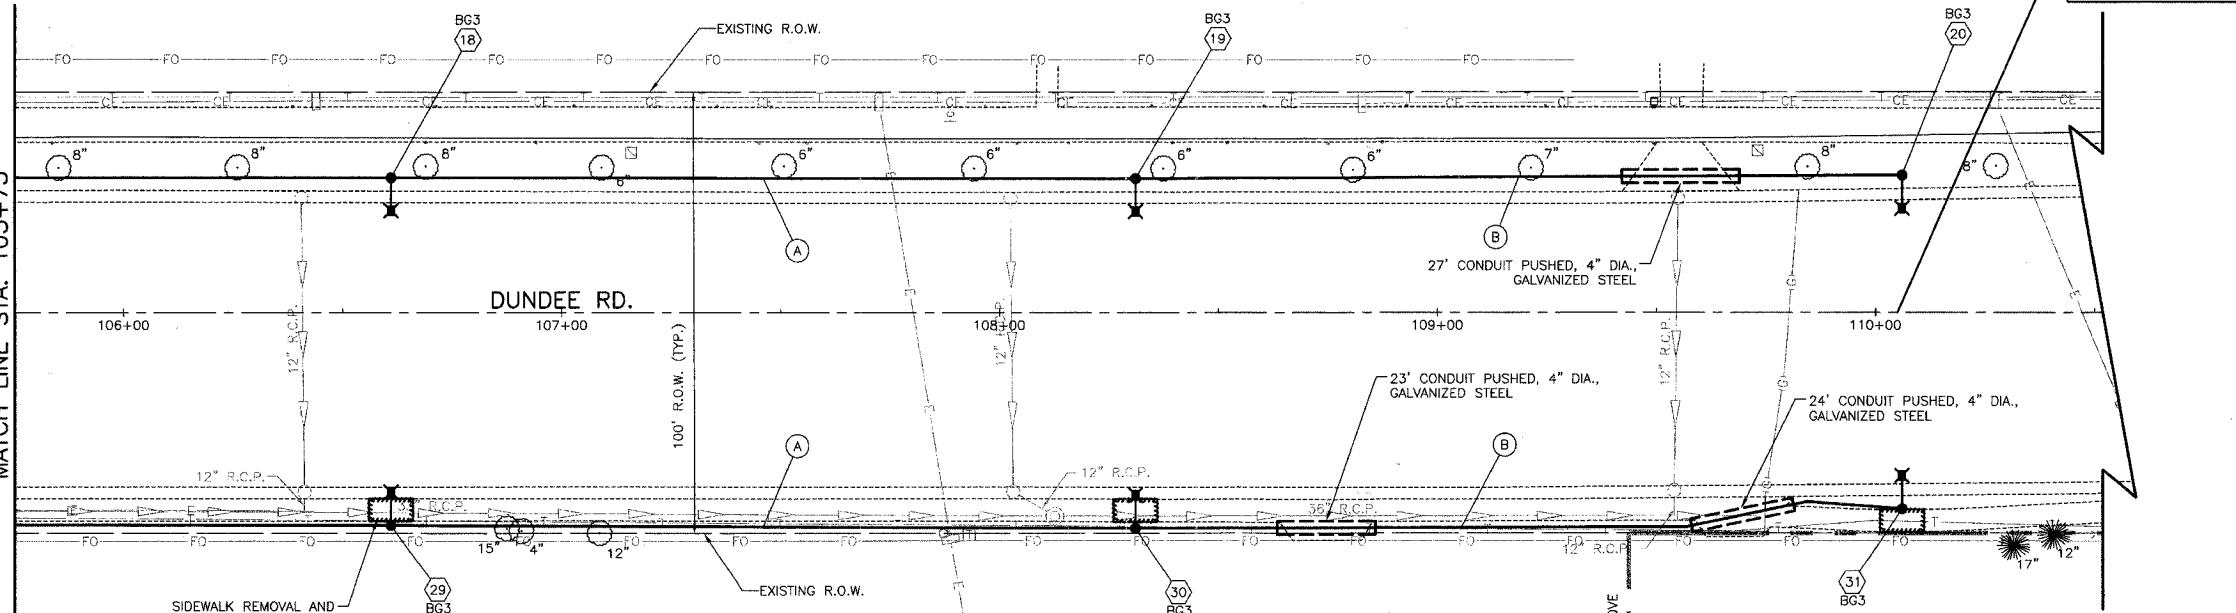

- (A) UNIT DUCT, WITH 4-1/2\"/>
- (B) UNIT DUCT, WITH 2-1/2\"/>
- (C) UNIT DUCT, WITH 4-1/2\"/>
- (D) UNIT DUCT, WITH 2-1/2\"/>

NO.	REVISIONS

VILLAGE OF BUFFALO GROVE  
**DUNDEE ROAD LIGHTING IMPROVEMENT**  
**LIGHTING PLAN**  
 DUNDEE ROAD  
 STA. 100+75 TO STA. 110+75

DESIGNED BY: S.J.C.  
 CHECKED BY: D.N.M.  
 DATE: 07/10/2007

SCALE IN FEET