
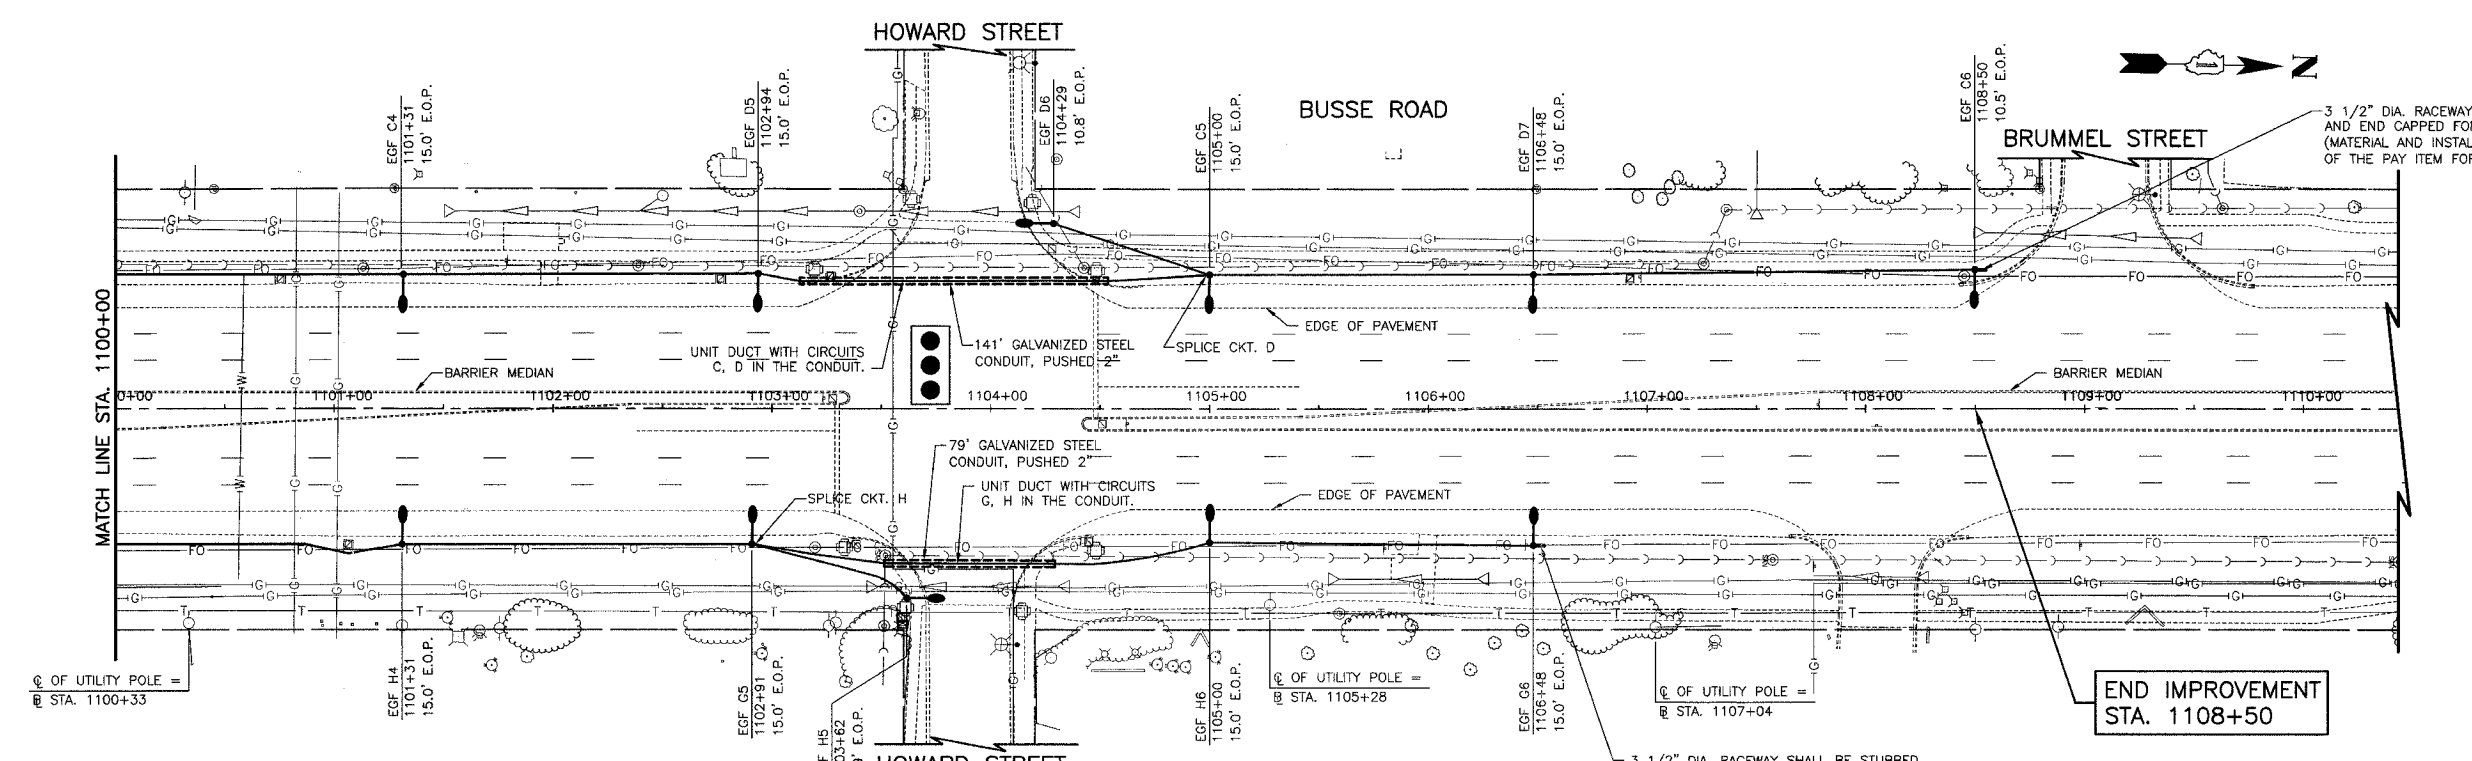


SECTION	COUNTY	TOTAL SHEETS	SHEET NO.
06-00052-00-LT	COOK	10	4
BUSSE RD. - STA. 1089+30 TO STA. 1108+50			
LIGHTING PLAN			

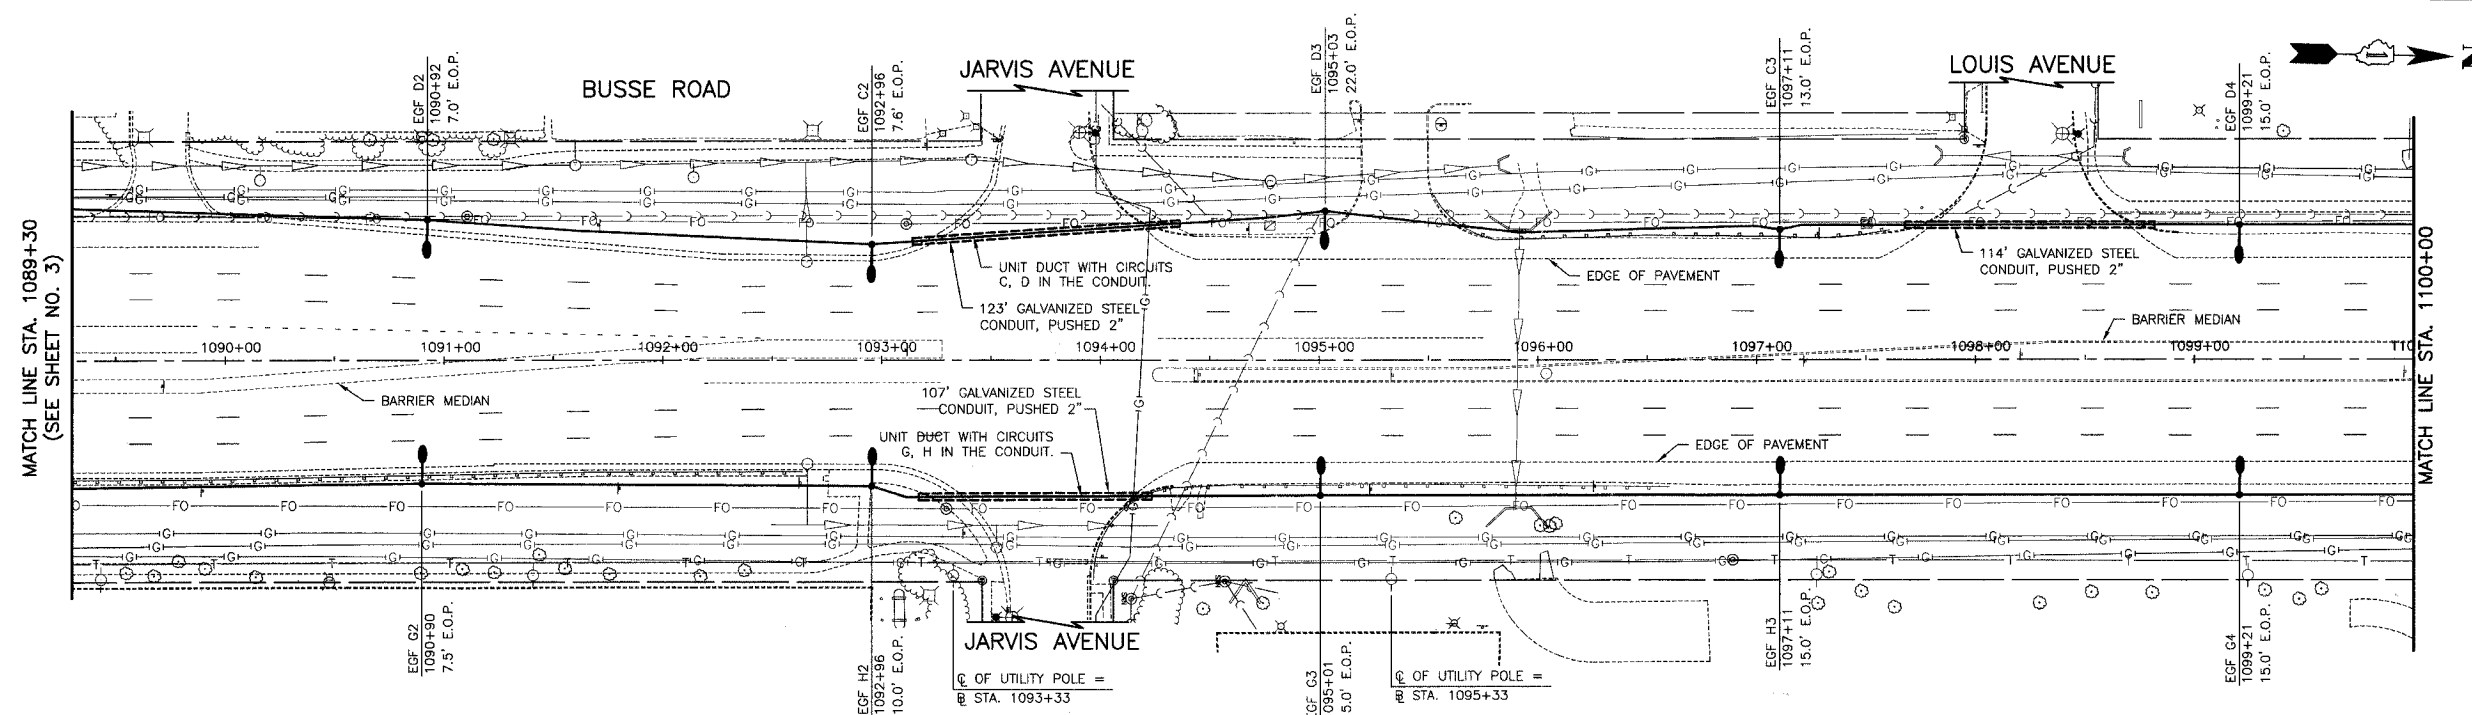

REVISIONS	
NAME	DATE

ILLINOIS DEPARTMENT OF TRANSPORTATION

BUSSE ROAD (IL 83)

ROADWAY LIGHTING

LIGHTING PLAN

BUSSE ROAD

STA. 1089+30 TO STA. 1108+50

SCALE IN FEET

DATE: 07/10/2007

CHECKED BY: D.N.M.

2: d:\projects\busse\plan\sheet\042.dwg, Date: 4/10/2007
 3: d:\projects\busse\plan\sheet\042.dwg, Date: 4/10/2007
 4: d:\projects\busse\plan\sheet\042.dwg, Date: 4/10/2007

