



PLAN	SECTION	COUNTY	TOTAL SHEETS	SHEET NO.
1545	00-00115-00-BR	DUPAGE	97	14
STA. 1+31.77		TO STA. 5+50.00		
FED. ROAD DIST. NO.	ILLINOIS	FED. AID PROJECT		CONTRACT 83961

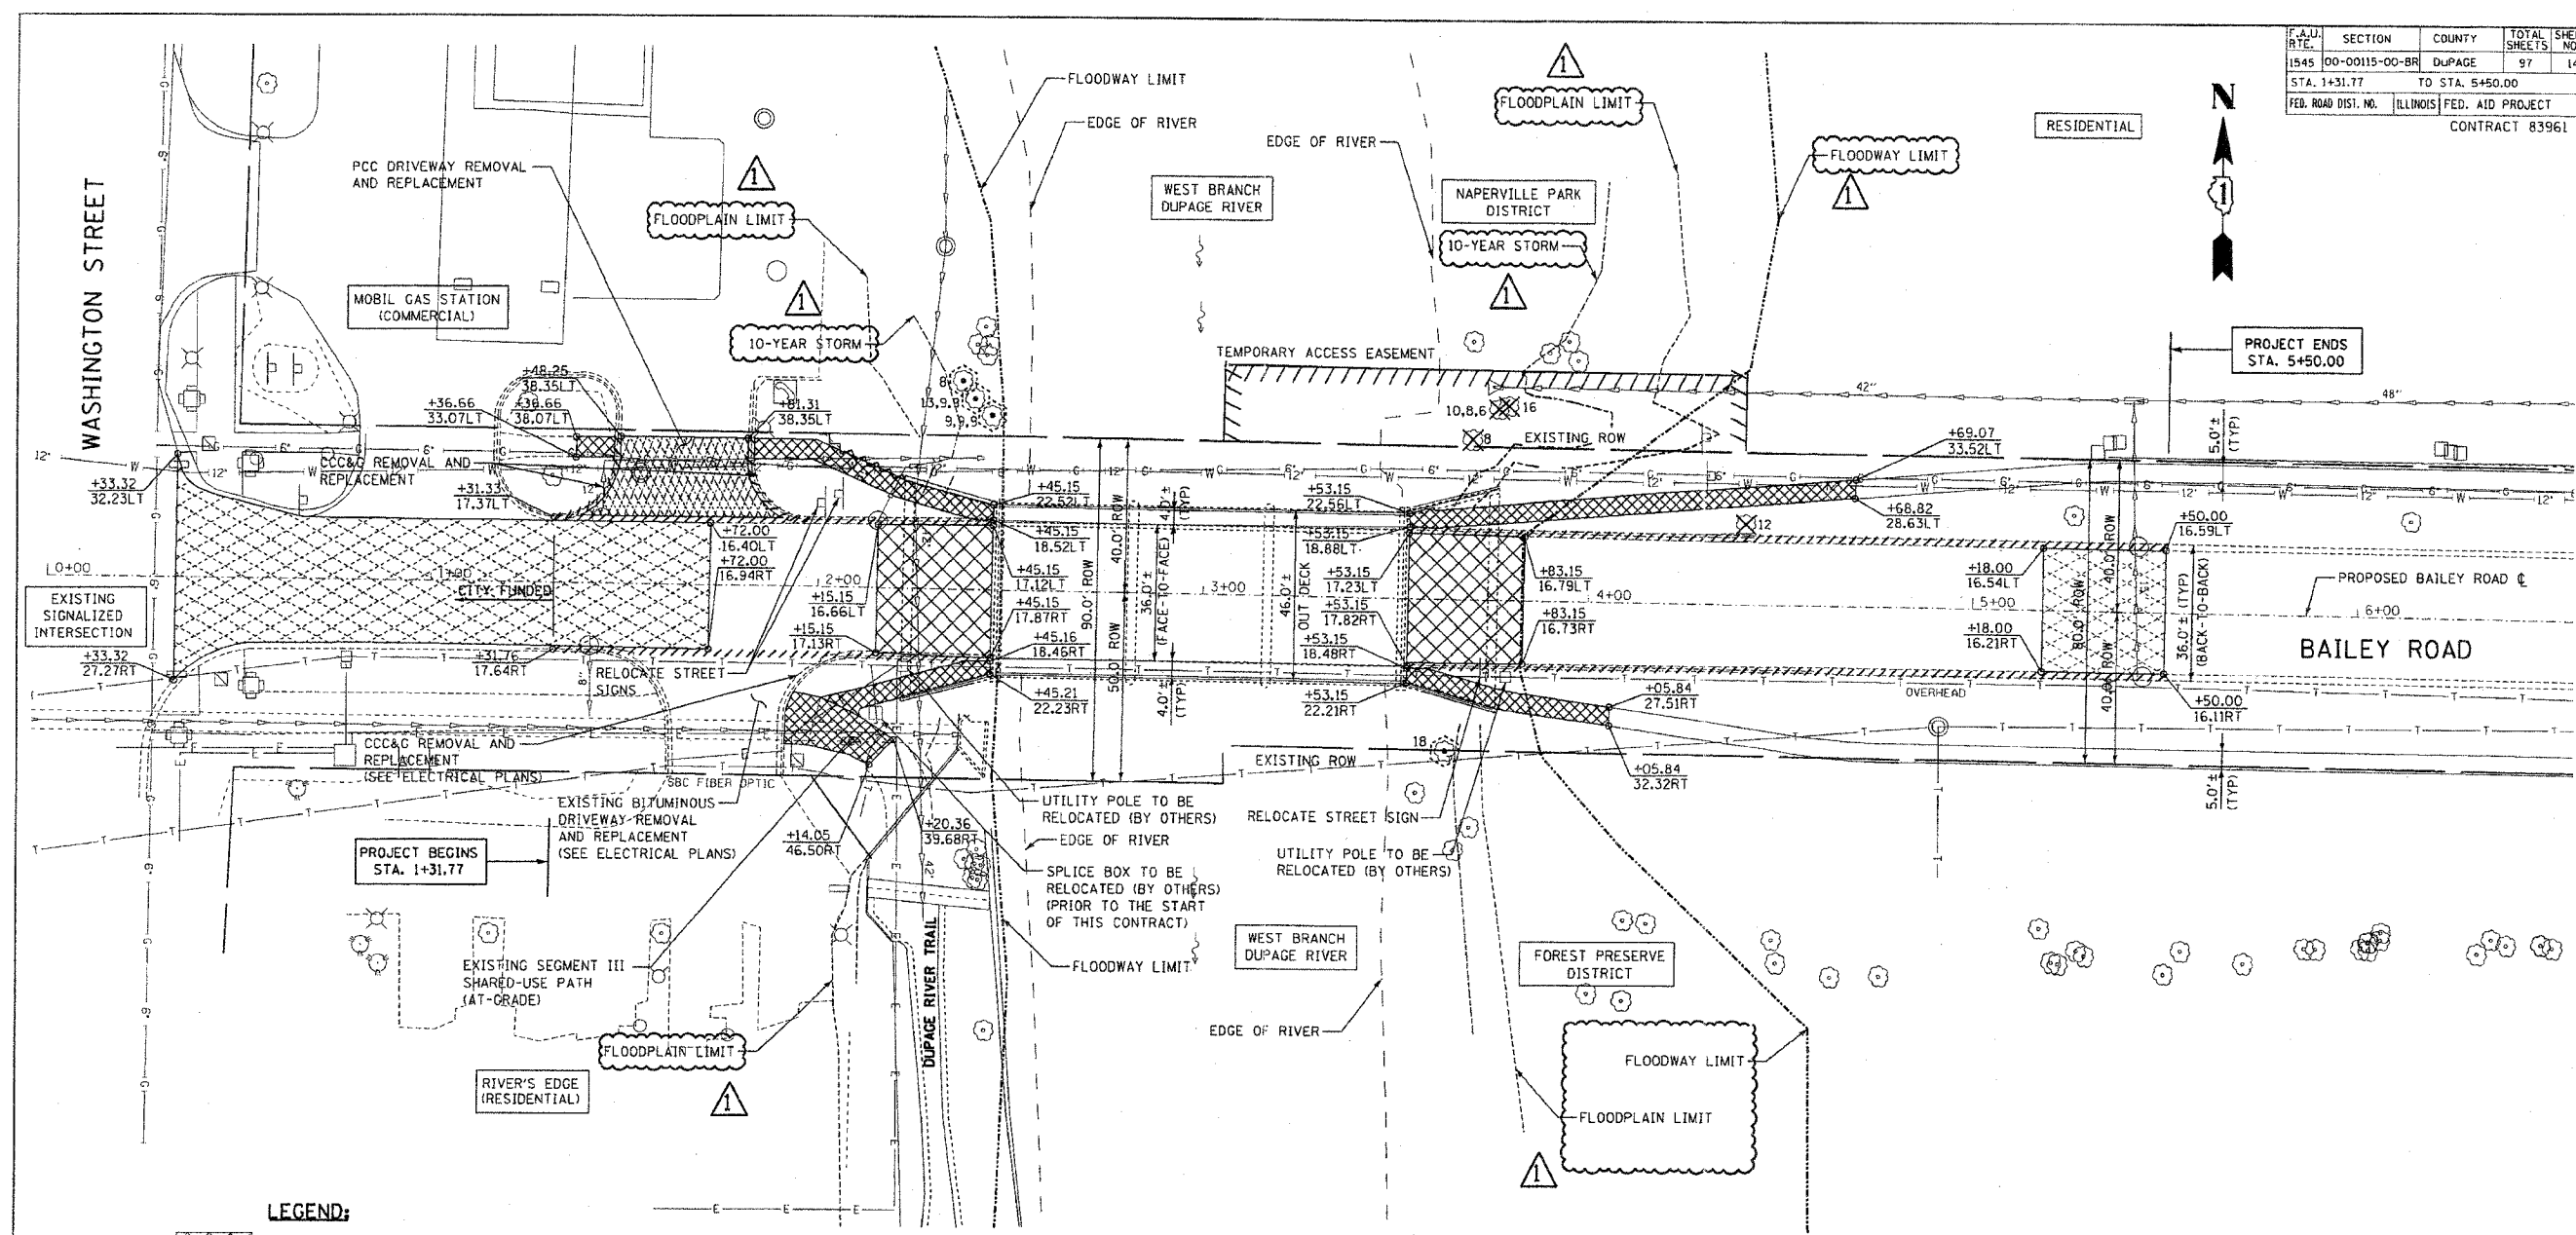

**LEGEND:**

 	PAVEMENT REMOVAL
	SIDEWALK REMOVAL
	HOT-MIX ASPHALT SURFACE REMOVAL - BUTT JOINT HOT-MIX ASPHALT SURFACE REMOVAL 2 1/4" (CITY FUNDED ONLY)
	DRIVEWAY REMOVAL
	COMB CONC CURB & GUTTER REMOVAL
	CHAIN LINK FENCE REMOVAL
	TREE REMOVAL (UNITS) (NO UNIT SHOWN = <6)
	TREE TRUNK PROTECTION

**NOTES:**  
1. SEE ELECTRICAL PLANS FOR ADDITIONAL REMOVAL ITEMS.



<table border="1"> <thead> <tr> <th colspan="2">REVISIONS</th> </tr> <tr> <th>NAME</th> <th>DATE</th> </tr> </thead> <tbody> <tr><td> </td><td> </td></tr> <tr><td> </td><td> </td></tr> <tr><td> </td><td> </td></tr> <tr><td> </td><td> </td></tr> <tr><td> </td><td> </td></tr> <tr><td> </td><td> </td></tr> <tr><td> </td><td> </td></tr> <tr><td> </td><td> </td></tr> <tr><td> </td><td> </td></tr> <tr><td> </td><td> </td></tr> <tr><td> </td><td> </td></tr> </tbody> </table>	REVISIONS		NAME	DATE																							<p><b>BRIDGE REHABILITATION BAILEY ROAD OVER WEST BRANCH OF THE DUPAGE RIVER</b></p> <p><b>REMOVAL AND EXISTING UTILITY PLANS</b></p> <p>CONSULTANT <b>TYLIN INTERNATIONAL</b></p>	<p>City of </p> <p><b>Naperville</b></p> <p>DRAWN: RTM CHECKED: SP APPROVED: [Signature] DATE: JULY 13, 2007 SCALE: 1"=20'-0" JOB NO.: C-91-062-04</p> <p>SHEET NO. <b>14</b> PROJECT NO.: BHM-8003(343)</p>
REVISIONS																												
NAME	DATE																											