

 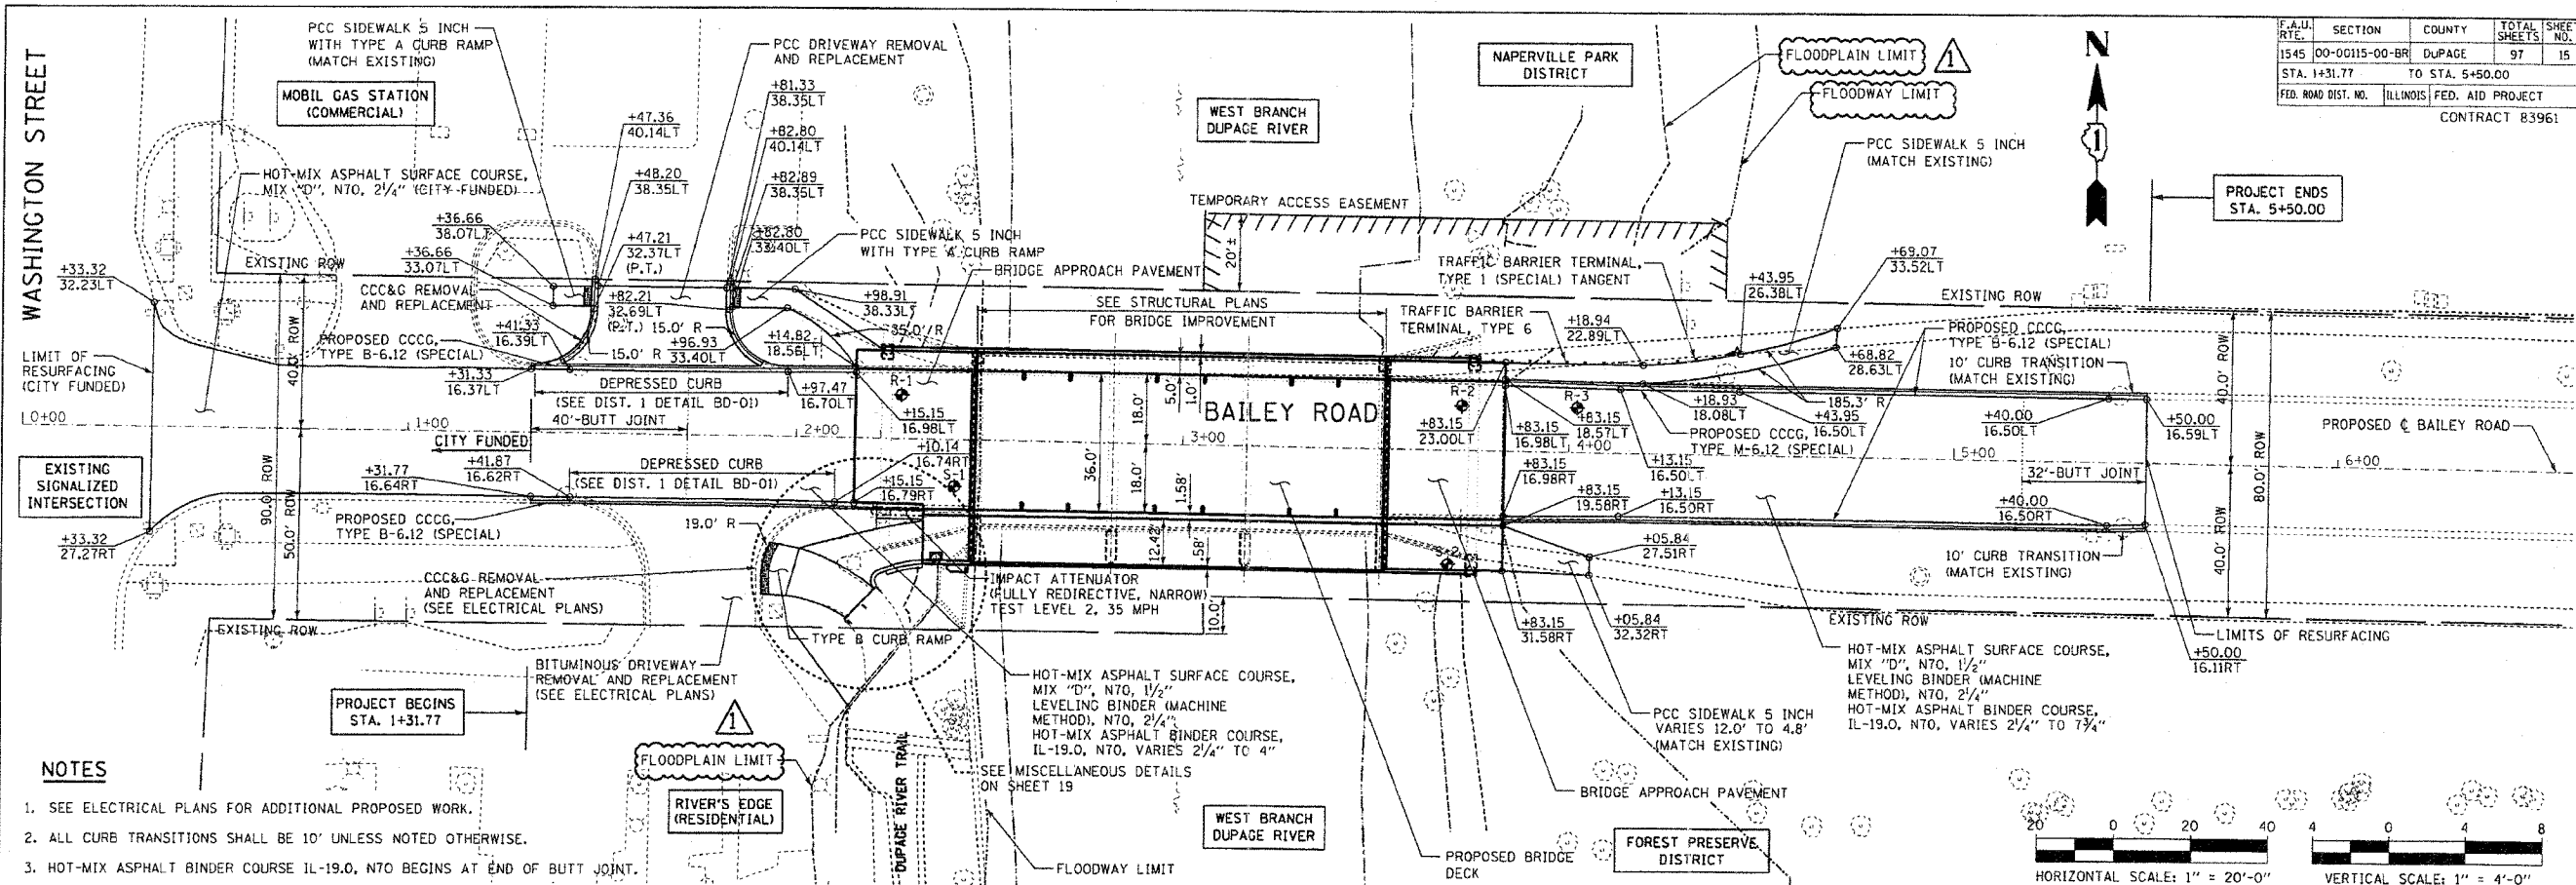


F.A.U. NO.	SECTION	COUNTY	TOTAL SHEETS	SHEET NO.
1545	00-00115-00-BR	DUPAGE	97	15
STA. 1+31.77		TO STA. 5+50.00		
FED. ROAD DIST. NO.		ILLINOIS		FED. AID PROJECT
CONTRACT 83961				

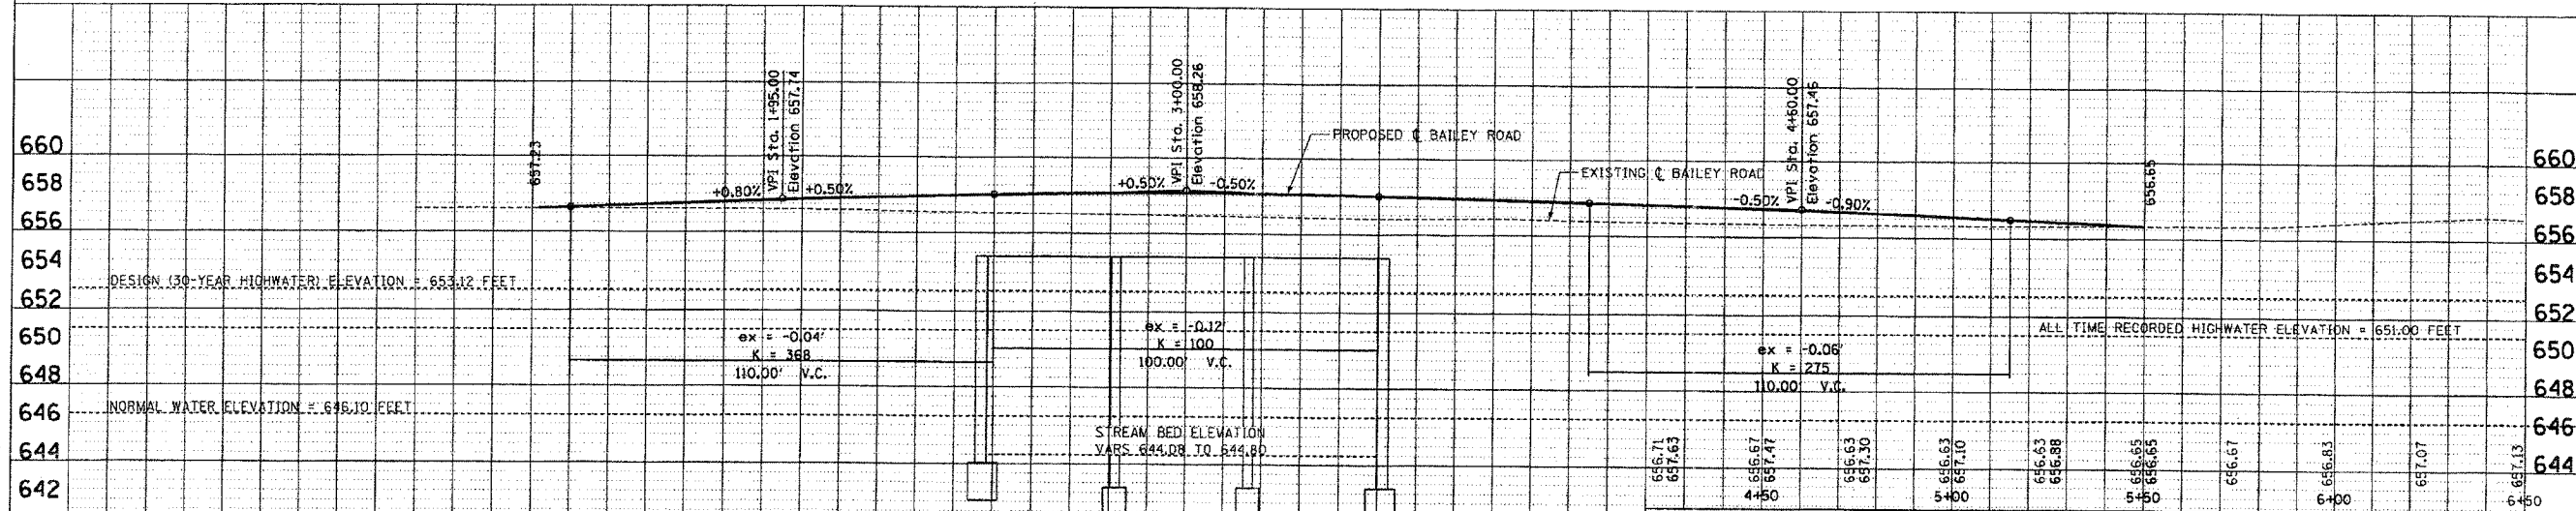

- NOTES**
- SEE ELECTRICAL PLANS FOR ADDITIONAL PROPOSED WORK.
 - ALL CURB TRANSITIONS SHALL BE 10' UNLESS NOTED OTHERWISE.
 - HOT-MIX ASPHALT BINDER COURSE IL-19.0, N70 BEGINS AT END OF BUTT JOINT.



REVISIONS NAME DATE		BRIDGE REHABILITATION BAILEY ROAD OVER WEST BRANCH OF THE DUPAGE RIVER PROPOSED PLAN AND PROFILE CONSULTANT TYLIN INTERNATIONAL	City of Naperville
DRAWN: RTM CHECKED: SP APPROVED: DATE: JULY 13, 2007 SCALE: HORIZ. 1"=20'-0" VERT. 1"=4'-0" JOB NO.: C-91-062-04			