
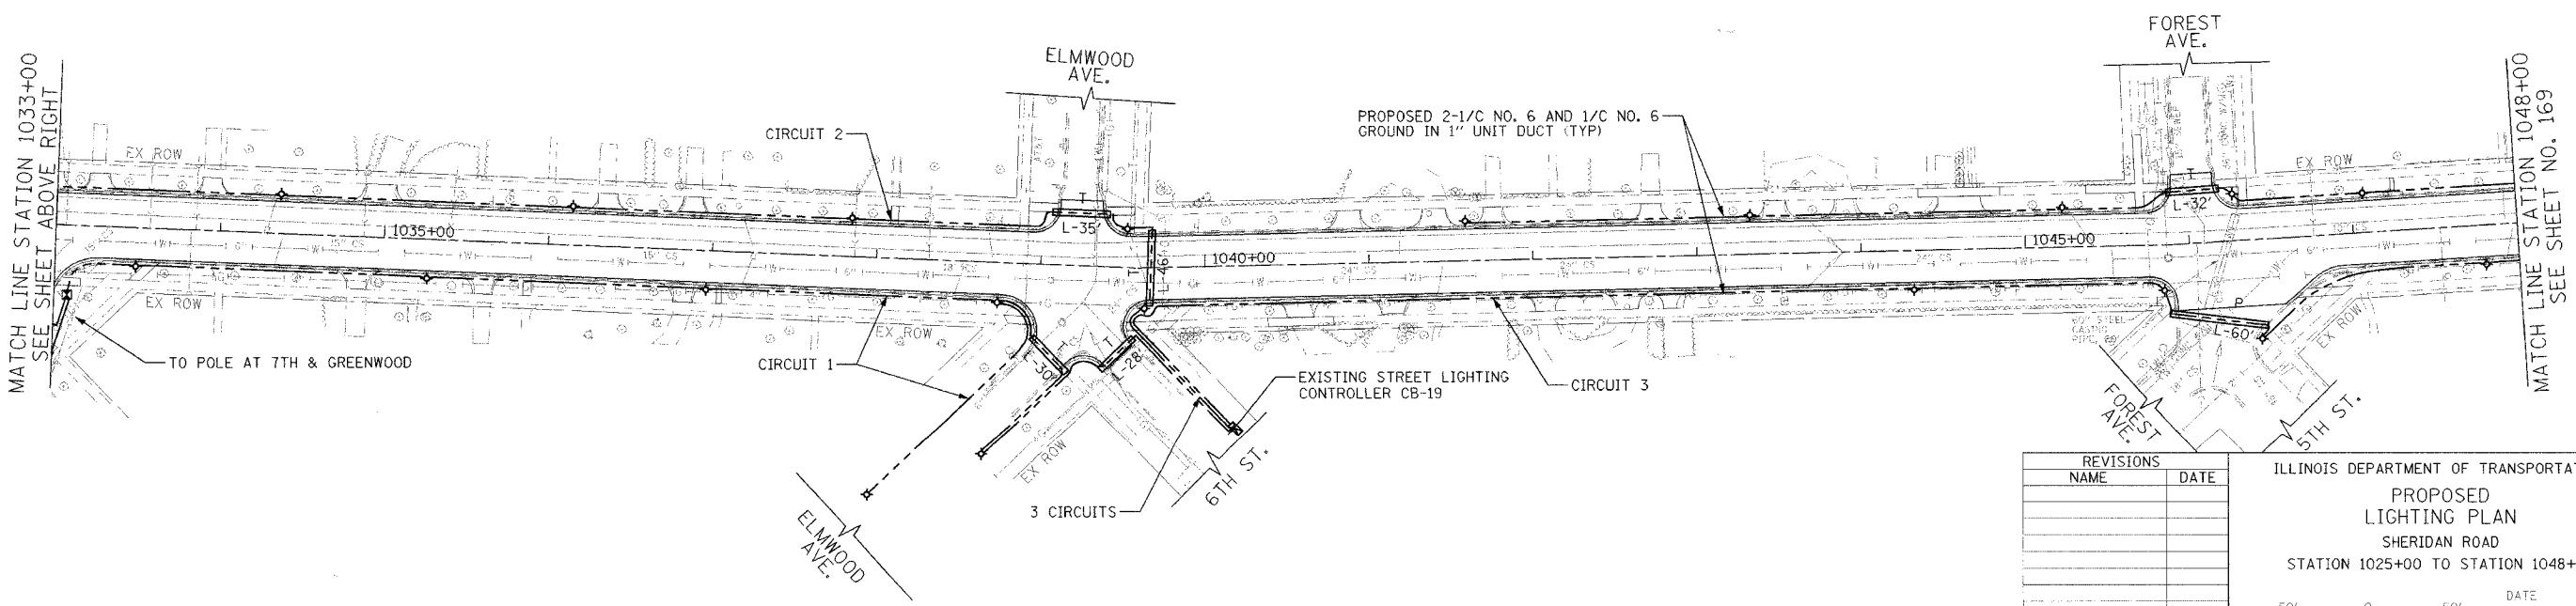


F.A.J. RTE.	SECTION	COUNTY	TOTAL SHEETS	SHEET NO.
3509	00-00173-03-FP	COOK	246	168
STA. 1025+00		TO STA. 1048+00		
FED. ROAD DIST. NO. 7 (ILLINOIS) FED. AID PROJECT				

**NOTES:**

- FOR RELOCATED POLE OFFSET DISTANCE REQUIREMENTS, SEE NOTE 8 ON SHEET NO. 161

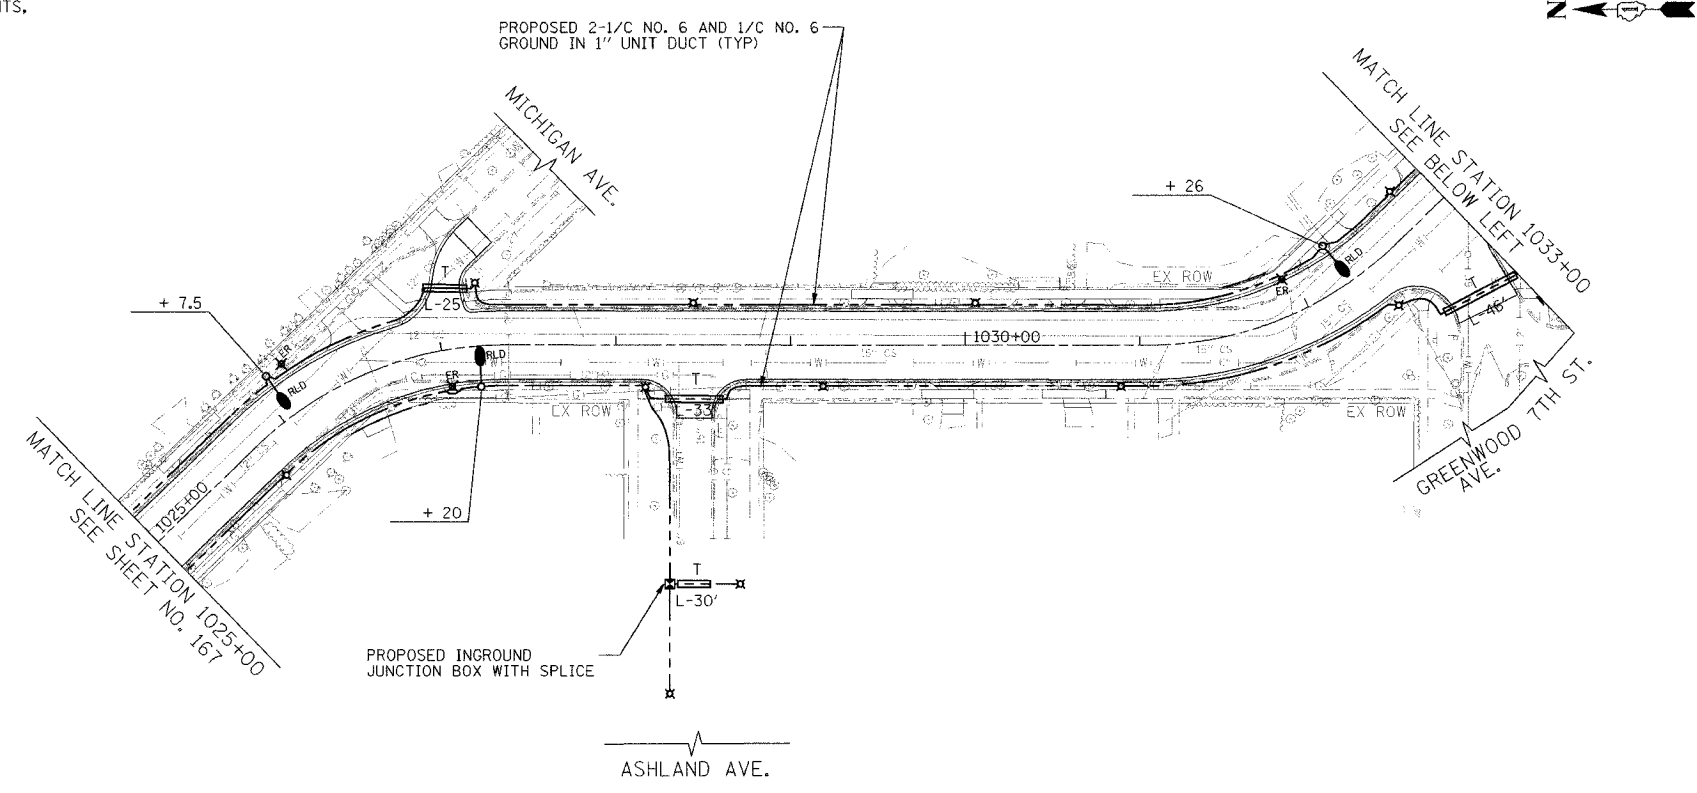

REVISIONS NAME	DATE

ILLINOIS DEPARTMENT OF TRANSPORTATION  
**PROPOSED LIGHTING PLAN**  
 SHERIDAN ROAD  
 STATION 1025+00 TO STATION 1048+00

DATE: 7/30/07  
 DRAWN BY: AJP  
 CHECKED BY: RJG

HORIZ. 1"=50'

PLOT DATE = 8/6/2007  
 FILE NAME = g:\a\006\0005\road\sheet\CP-light.rvt  
 PLOT SCALE = 50.0000 / 1 IN.  
 USER NAME = mjgonzalez

1051 PERIMETER DRIVE SUITE 1025  
 SCHAMBERG, ILLINOIS 60173  
 (847) 605-9800

