



Note: Precaster is responsible for coordinating fabrication of concrete panels with location of all electrical, mechanical, and plumbing devices. Panels should be designed to include all knockouts and voids required for ductwork and junction boxes. They should also include conduit for the wiring of all such devices.


Note: Remove temporary elevator machine enclosure as required. (Temporary enclosure shall remain as long as possible to reduce the chances of damaging elevator equipment.)

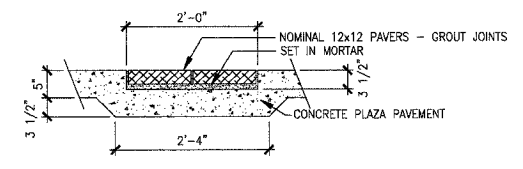

C PLAZA DETAIL
3/4" = 1'-0"

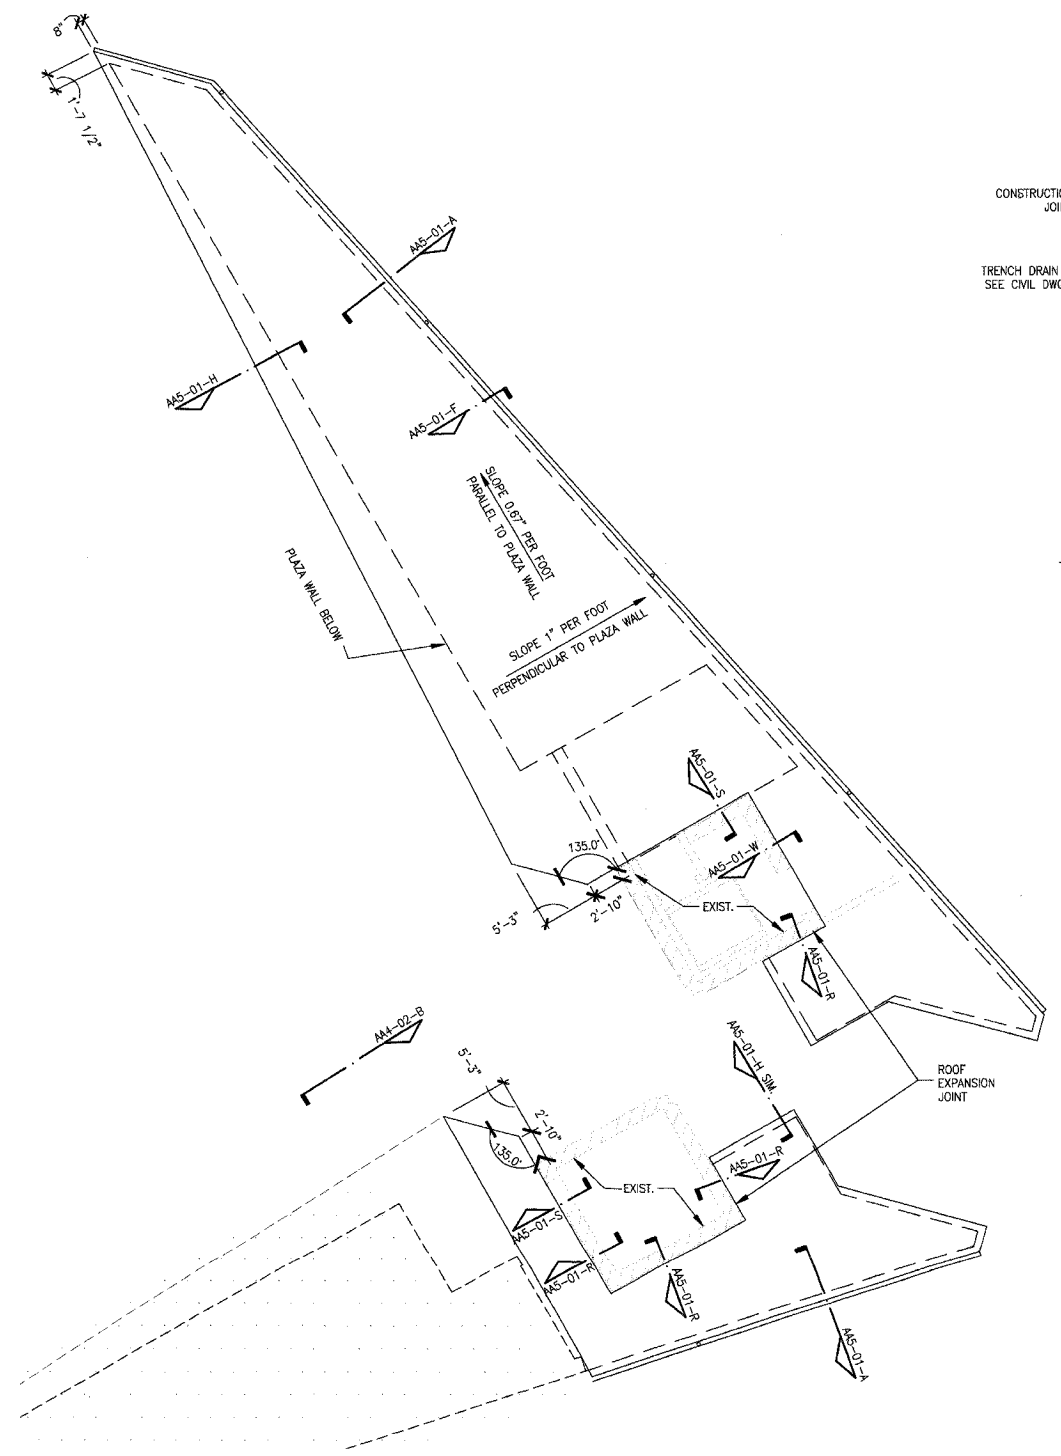

A ROOF PLAN
1/8" = 1'-0"
PLAN NORTH

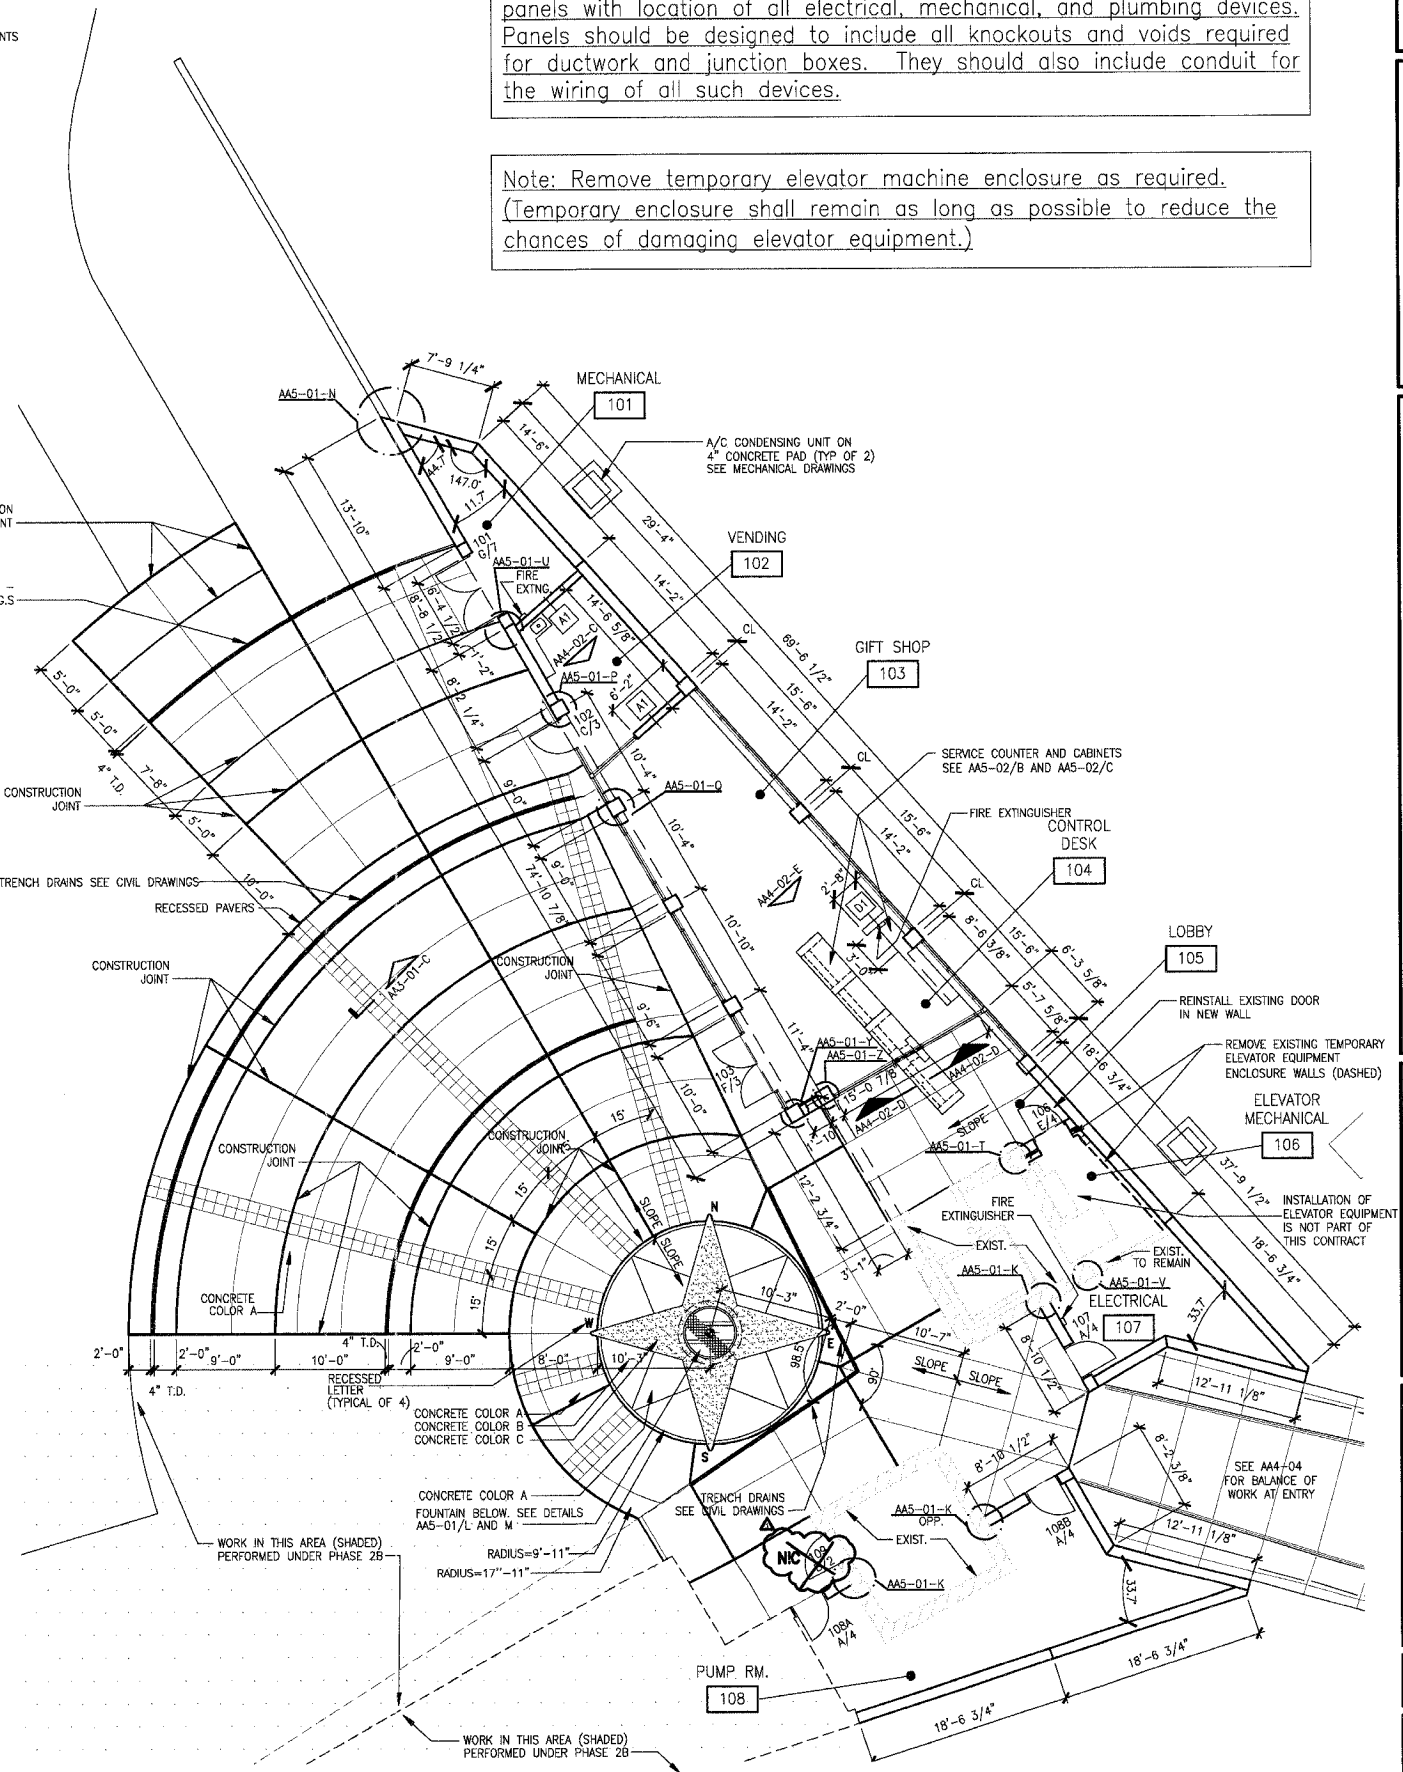

B FLOOR PLAN
1/8" = 1'-0"
PLAN NORTH

211 N. Broadway
Suite 1000
St. Louis, MO 63102
(314) 241-9188
FAX (314) 241-0225



**PHASE 2A
LEWIS AND CLARK MEMORIAL TOWER
VILLAGE OF HARTFORD, ILLINOIS
HARTFORD, ILLINOIS 62049**

SHEET TITLE:
**FLOOR PLAN AND
ROOF PLAN**

REV. NO.	DATE	REMARKS
1	11/8/06	DOT REV.

KENNEDY PROJECT NO
KAI# 10-02048

ISSUE DATE
12-JULY-05

SHEET NO
AA3-01