


F.A. RTE.	SECTION	COUNTY	TOTAL SHEETS	SHEET NO.
	06-00026-01-MS	MADISON	43	33

FEDERAL AID PROJECT

KEYED NOTES

- 1 QUAZITE TYPE BOX INSTALLED IN PAVED AREA. SEE DETAIL A, SHEET E6-01.
- 2 WITHIN THIS FIXTURE, CONNECT NEW WIRING TO EXISTING CIRCUITS LP-8 AND LP-10.
- 3 EXISTING 3/4" EMPTY CONDUIT WITH PULLWIRE INSTALLED UNDER A PREVIOUS PHASE. CONDUIT TERMINATES AT CONTACTOR C1. PROVIDE NEW BRANCH CIRCUIT WIRING BETWEEN THIS FIXTURE AND PANEL LP. CIRCUITS 5 AND 7. EXTEND NEW WIRING THROUGH CONTACTOR C1. SEE SHEET E4-01 FOR LOCATION OF CONTACTOR C1.
- 4 EXTEND AND CONNECT TO PANEL VIA CONTACTOR C2. SEE SHEET E4-01 FOR LOCATION OF CONTACTOR C2.
- 5 EXTEND AND CONNECT TO PANEL VIA RELAY PANEL. SEE SHEET E4-01 FOR LOCATION OF RELAY PANEL.
- 6 WITHIN EXISTING JUNCTION BOXES, DISCONNECT EXISTING POWER SUPPLY CONDUCTORS FROM EXISTING PANEL LRPS (LIFE SAFETY LITG, FIRE ALARM EQUIP.) CONNECT EXISTING LIFE SAFETY LIGHTING AND EXISTING FIRE ALARM EQUIPMENT TO NEW CIRCUITS EP-2, 12 AND 16.

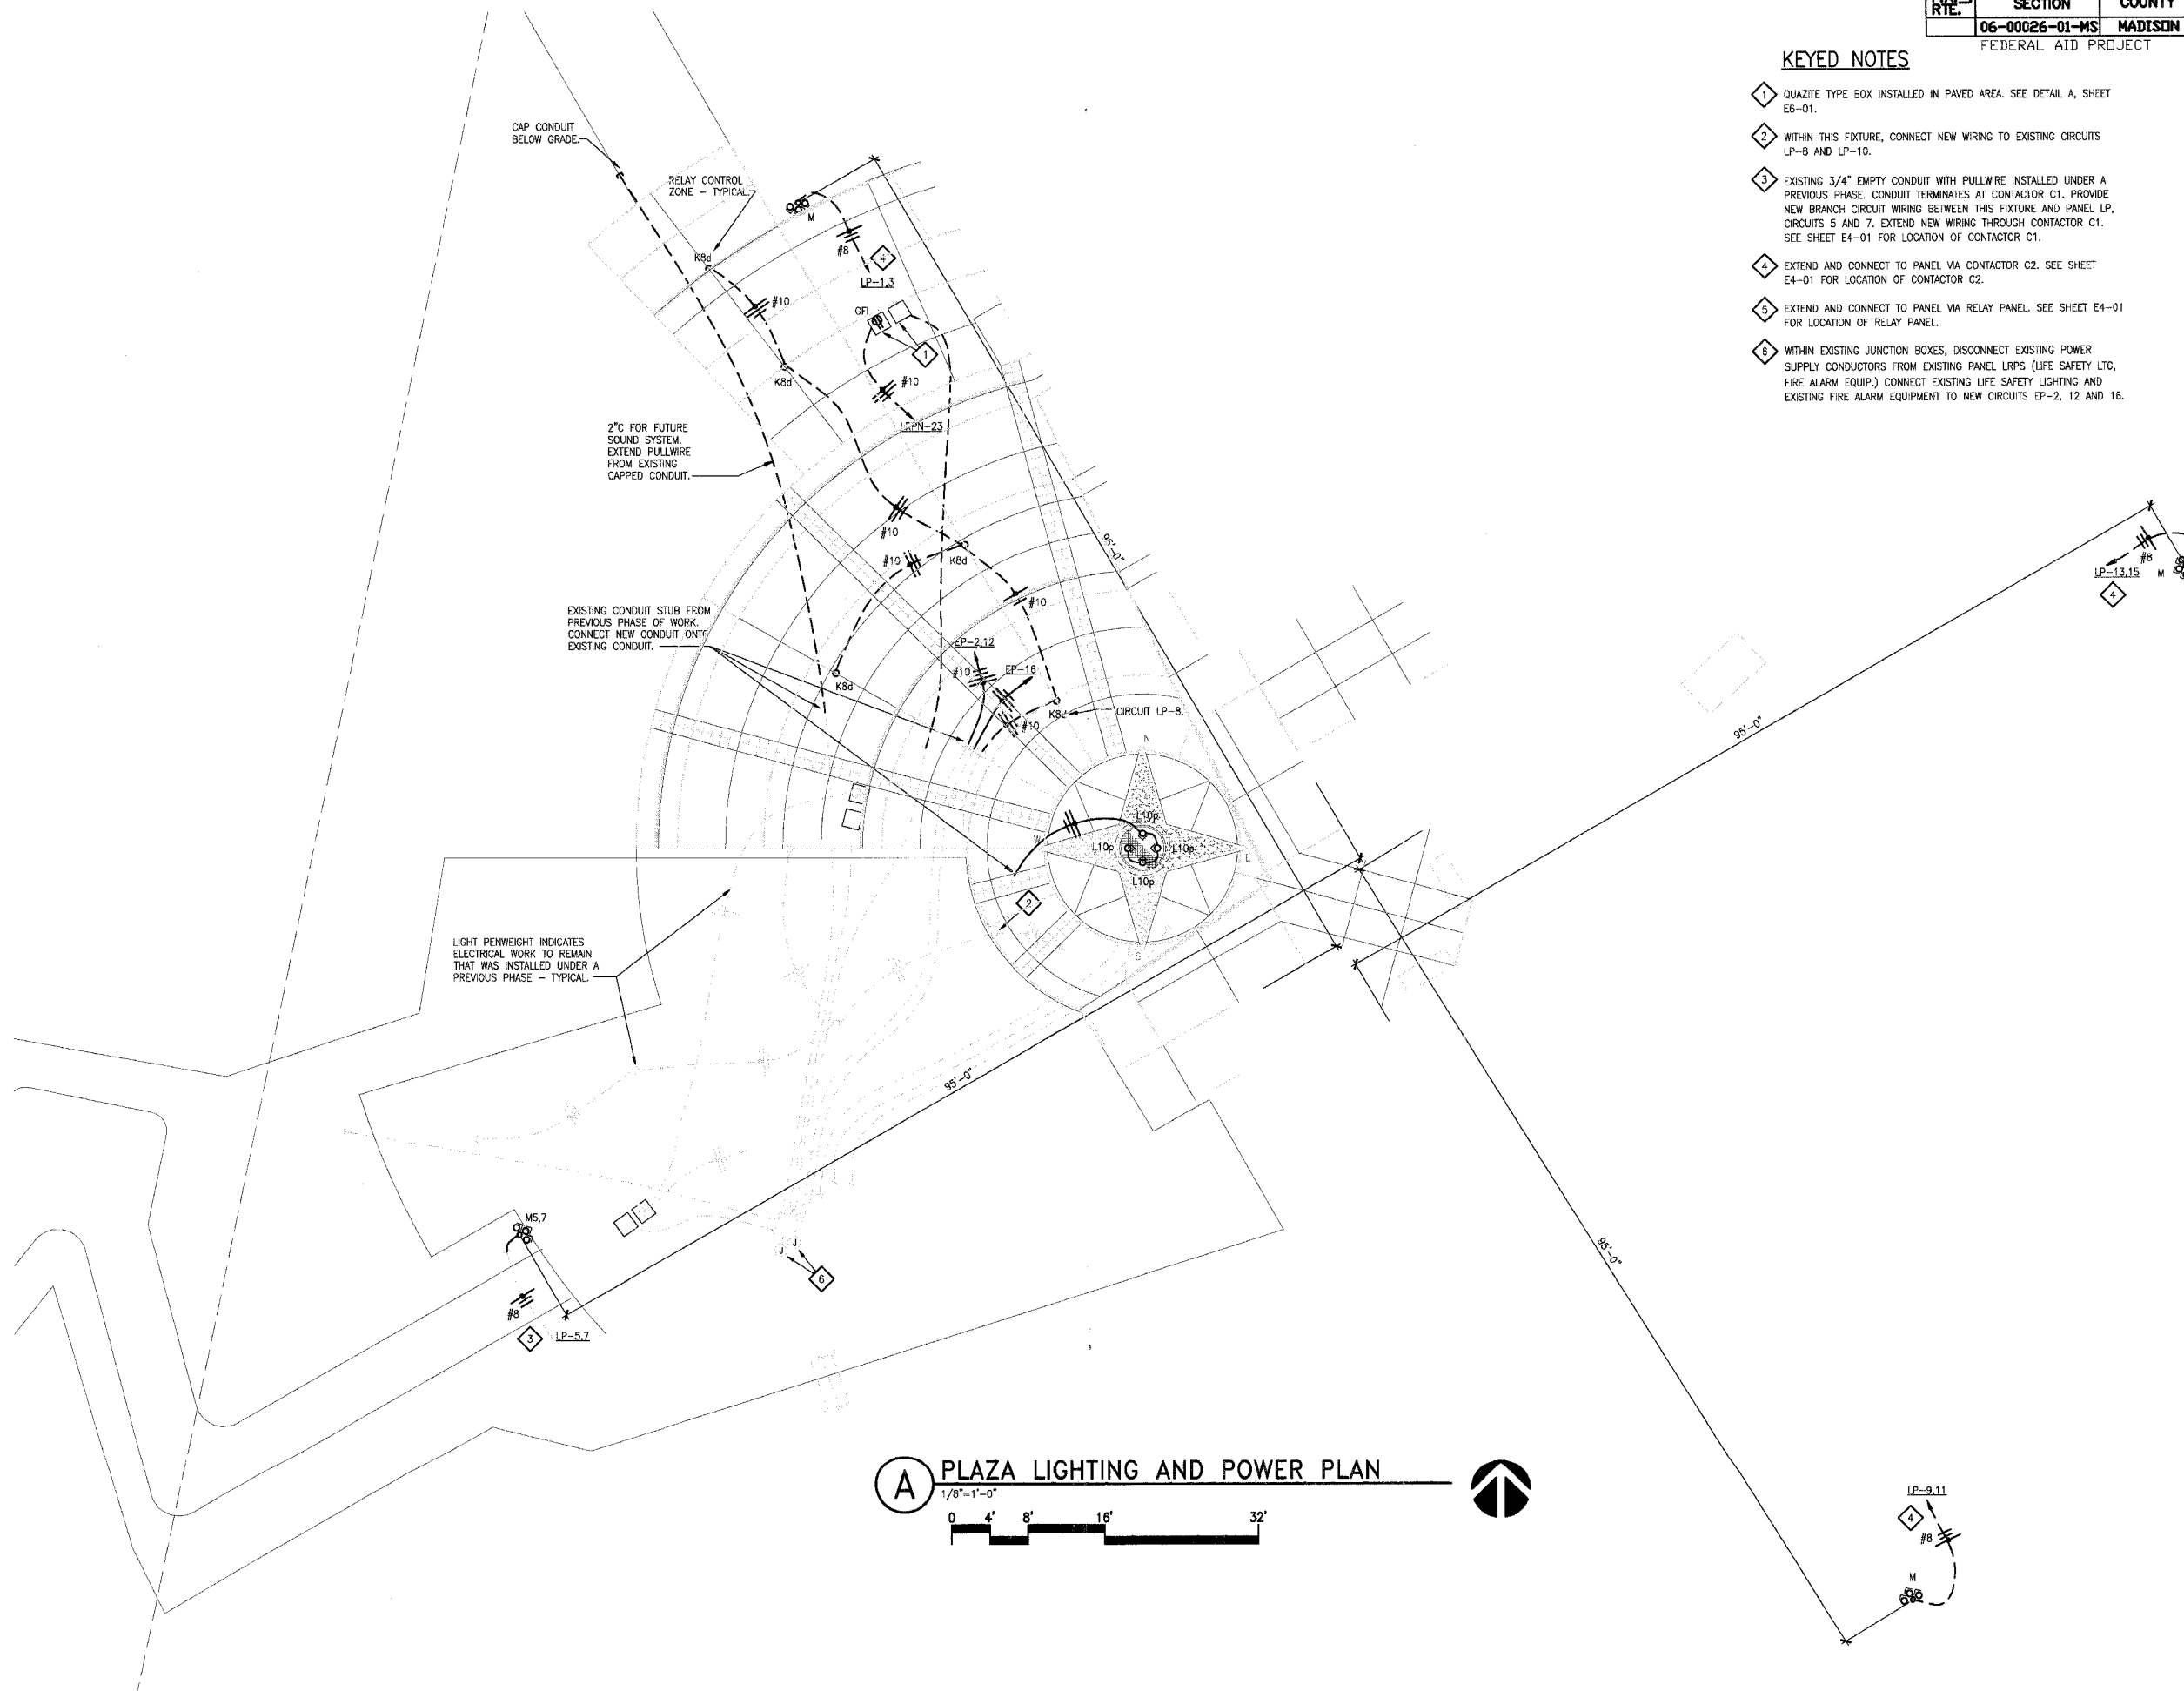

A PLAZA LIGHTING AND POWER PLAN
 1/8"=1'-0"
 0 4' 8' 16' 32'

211 N. Broadway
 Suite 1000
 St. Louis, MO 63102
 (314) 241-6188
 FAX (314) 241-0225



**PHASE 2A
 LEWIS AND CLARK MEMORIAL TOWER
 VILLAGE OF HARTFORD, ILLINOIS
 HARTFORD, ILLINOIS 62049**

SHEET TITLE:
**PLAZA
 LIGHTING PLAN**

REV. NO.	REMARKS	DATE

KENNEDY PROJECT NO
KAI# 10-02048

ISSUE DATE
12-JULY-05

SHEET NO
EA2-02

P:\2002\10-02048\600DISC\E7A2-02.DWG | 7/2/2007 10:15:01 AM | Xref's: TB2436COL SITE-2A BS-PLAN-2A E24BS202 E2BR6202 | Imager: none