

211 N. Broadway  
Suite 1000  
St. Louis, MO 63102  
KAI  
TEL (314) 241-0100  
FAX (314) 241-0105

**PHASE 2A  
LEWIS AND CLARK MEMORIAL TOWER  
VILLAGE OF HARTFORD, ILLINOIS  
HARTFORD, ILLINOIS 62049**

SHEET TITLE:  
**GROUND FLOOR  
POWER PLAN**

REV. NO.	REMARKS	DATE

KENNEDY PROJECT NO  
KAI# 10-02048


ISSUE DATE  
12-JULY-05

SHEET NO  
**EA4-01**

© 2005 KENNEDY ASSOCIATES INCORPORATED

**KEYED NOTES**

- 1 NOT USED.
- 2 NOT USED.
- 3 NOT USED.
- 4 NOT USED.
- 5 E.C. SHALL FURNISH AND INSTALL 4' X 8' X 3/4" FIRE RESISTANT PLYWOOD BACKBOARD FOR TELEPHONE SERVICE.
- 6 E.C. SHALL FURNISH AND INSTALL AIPHONE LEF-5 MASTER AND ASSOCIATED POWER SUPPLY.
- 7 TERMINATE CONDUCTORS ON AVAILABLE SPARE CIRCUIT BREAKER IN PANEL LRPS. SEE PANEL SCHEDULE.
- 8 DEVICE SURFACE MOUNTED UNDER COUNTER IN KNEE SPACE. ROUTE CONDUITS UNDER SLAB AND STUB UP THROUGH FLOOR UNDER COUNTER.

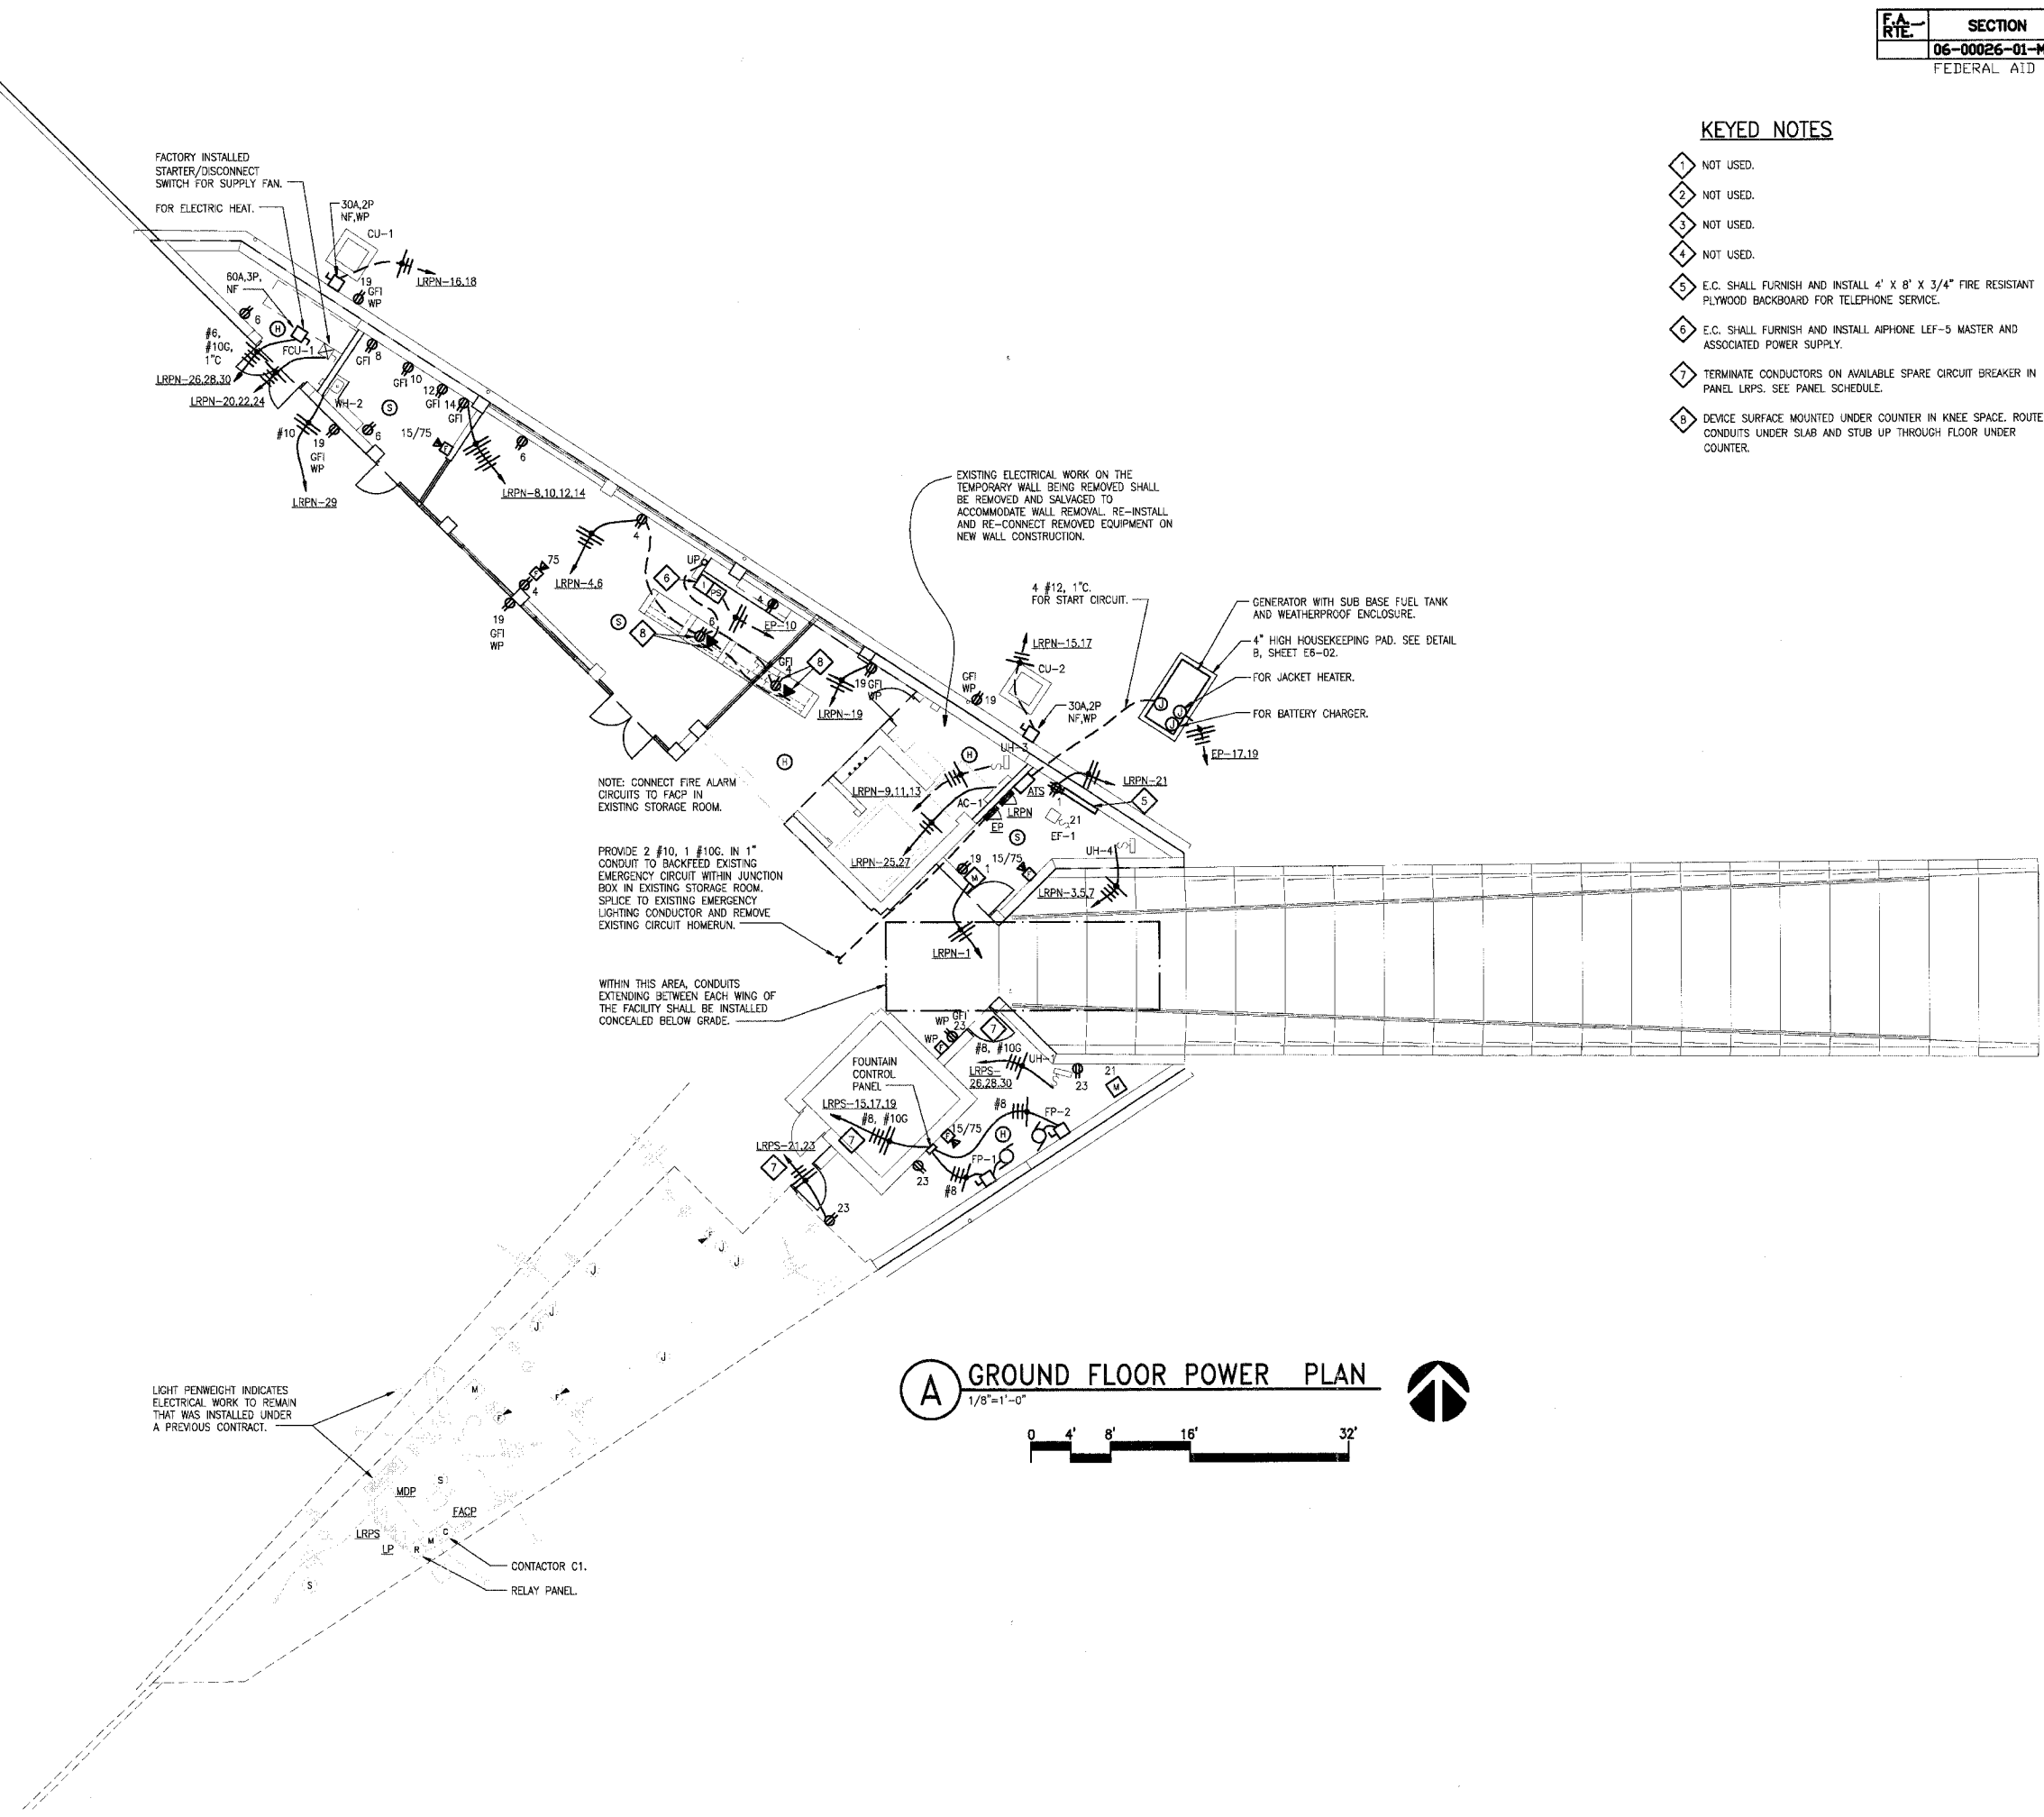

P:\2002\10-02048\600050\EA4-01.DWG | 7/2/2007 10:19:24 AM | Xref: TB24360DL BS-PLAN-2A EA4-01.EZBBS401.EZBBS401 | images: none