


211 N. Broadway
Suite 1000
St. Louis, MO 63102
(314) 241-9100
FAX (314) 241-0128



PHASE 2A
LEWIS AND CLARK MEMORIAL TOWER
VILLAGE OF HARTFORD, ILLINOIS
HARTFORD, ILLINOIS 62049

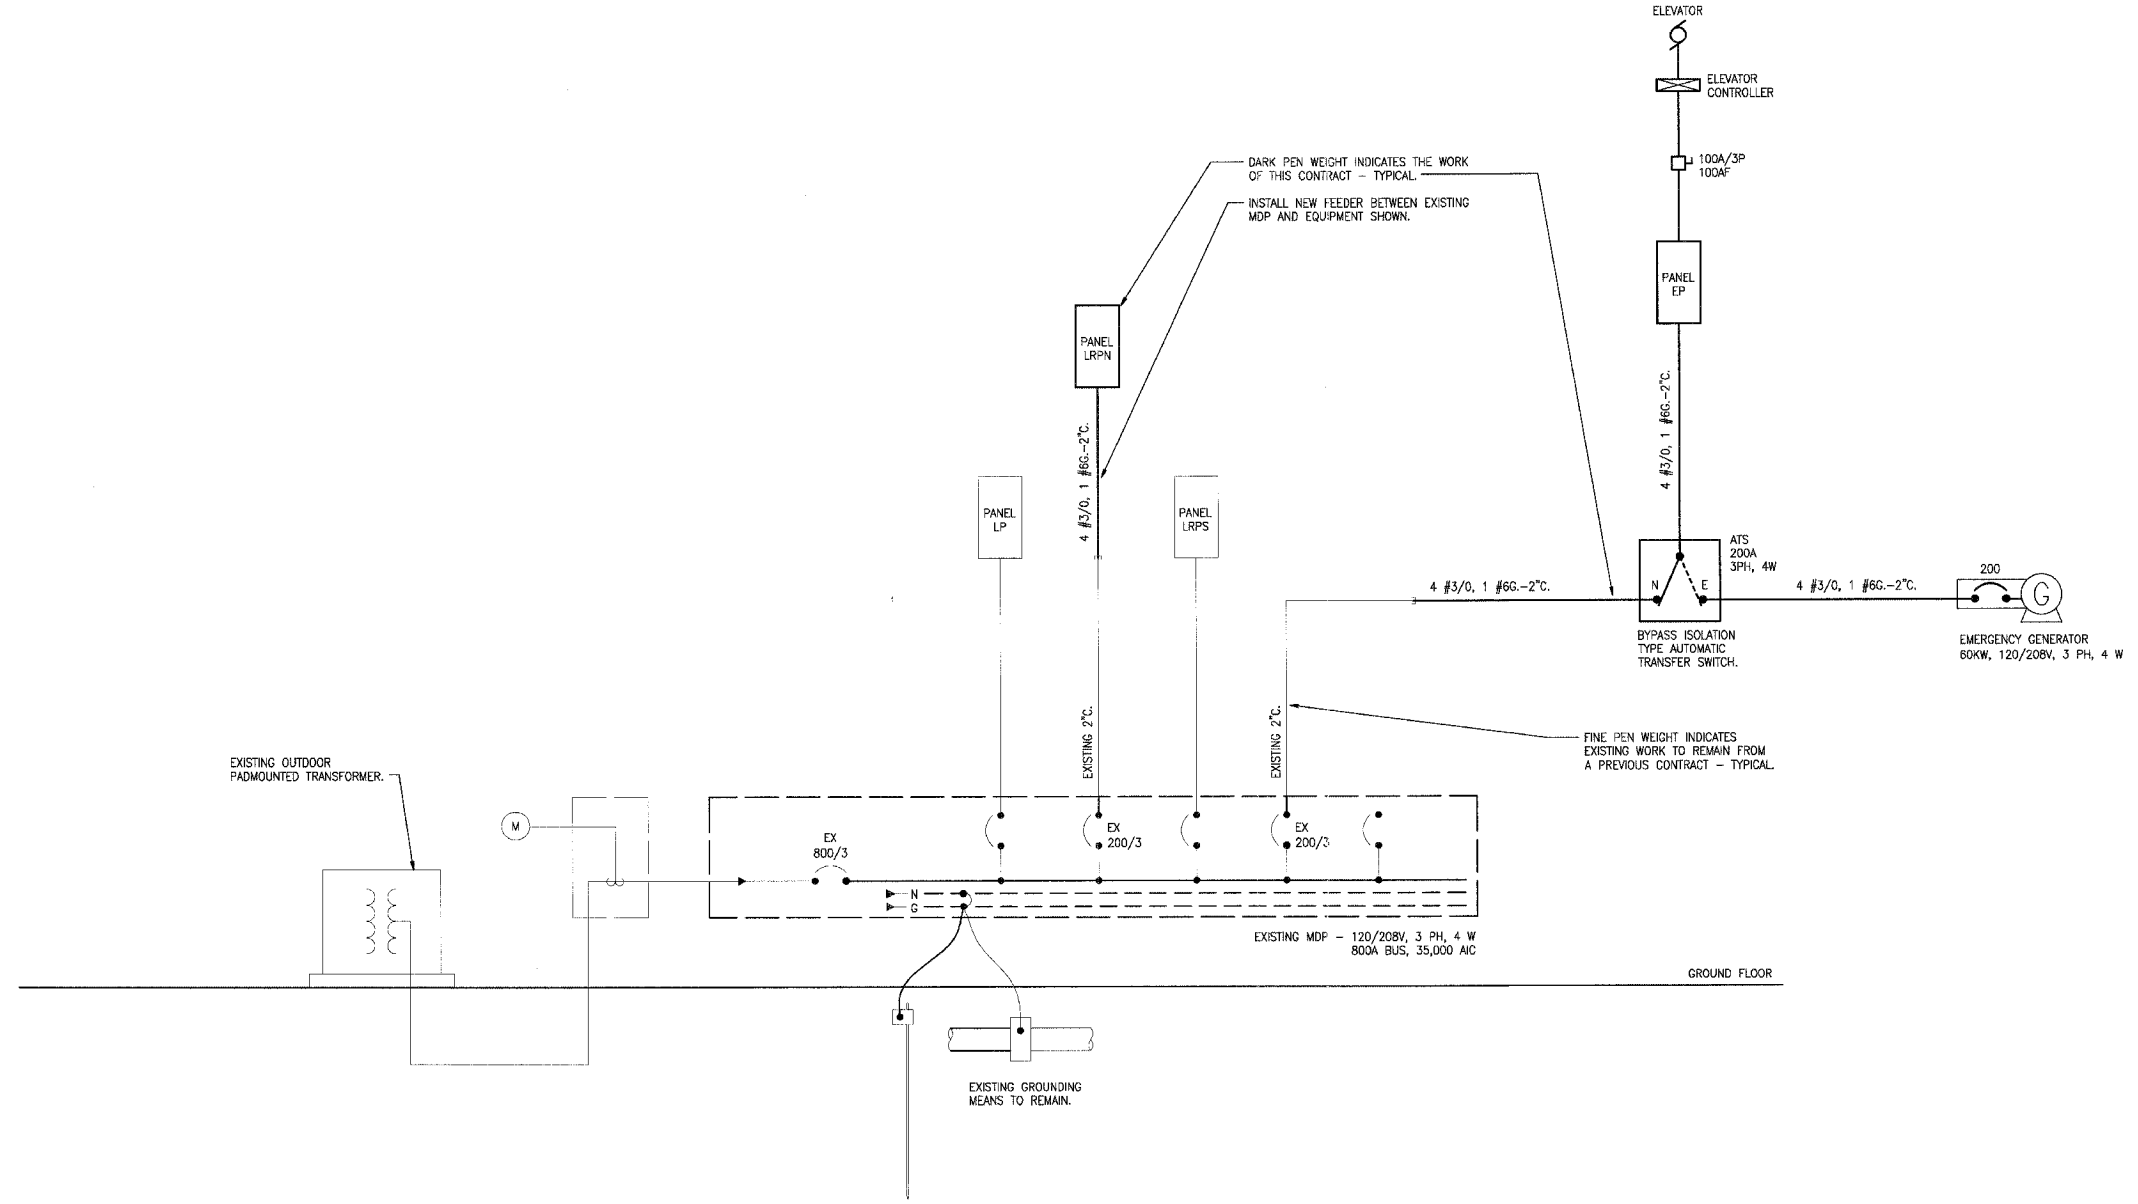

A ONE LINE DIAGRAM
NO SCALE

SHEET TITLE:
ONE LINE DIAGRAM

REV. NO.	REMARKS	DATE

KENNEDY PROJECT NO
KAI# 10-02048

ISSUE DATE
12-JULY-05

SHEET NO

EA5-01