


DATE	REVISION	BY

**DIMAX**  
**DEKALB TAYLOR MUNICIPAL AIRPORT**  
 A.I.P. PROJ.: 3-17-01-39-B37  
 I.L. PROJ.: DKB-3225


LAYOUT	KNL	03/20/07
DRAWN	CCC	03/23/07
REVIEWED	CAH	03/29/07

**HANSON**  
 Hanson Professional Services Inc.  
 1525 South Sixth Street  
 Springfield, Illinois 62703-2898  
 Offices Nationwide

**INSTALL MALS  
 RUNWAY END 2**  
**RUNWAY 2 MALS  
 SHELTER SITE PLAN**  
**DKB-D-MALSRO2-C03**

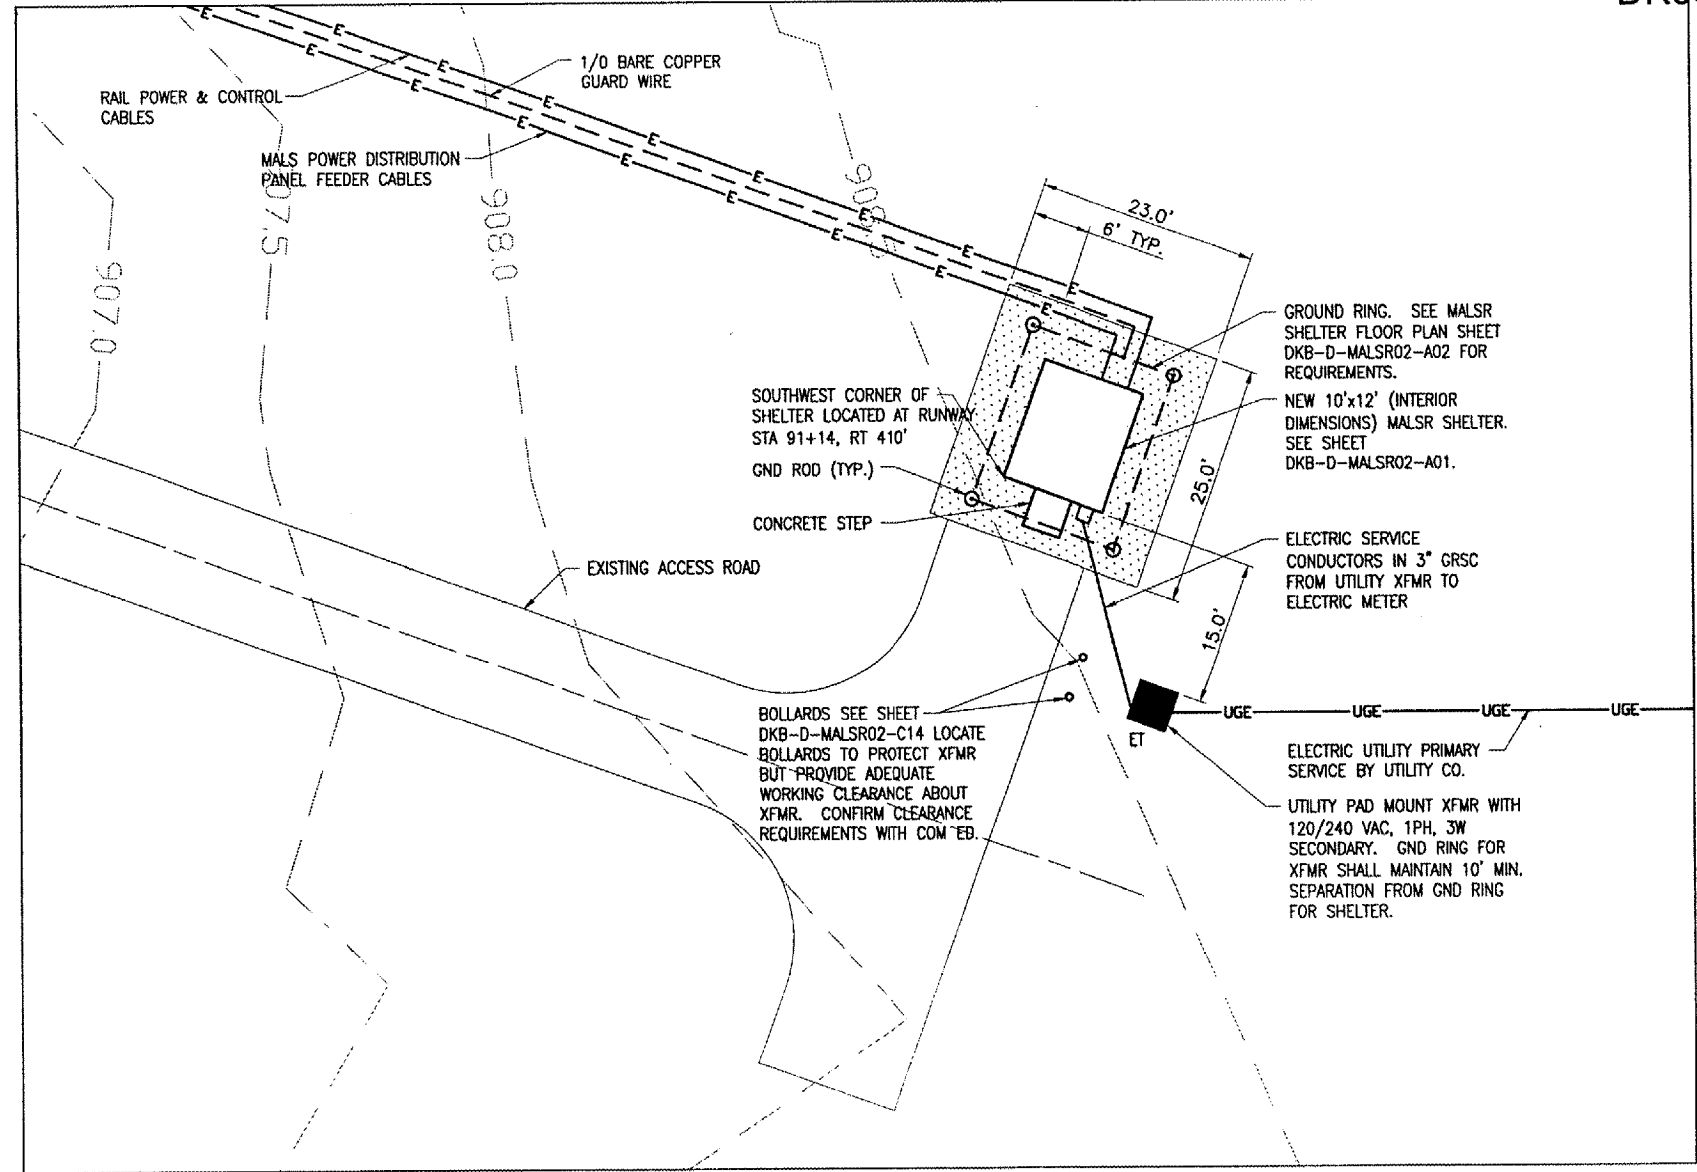

**MALS SHELTER SITE PLAN**  
 SCALE: 1" = 10'

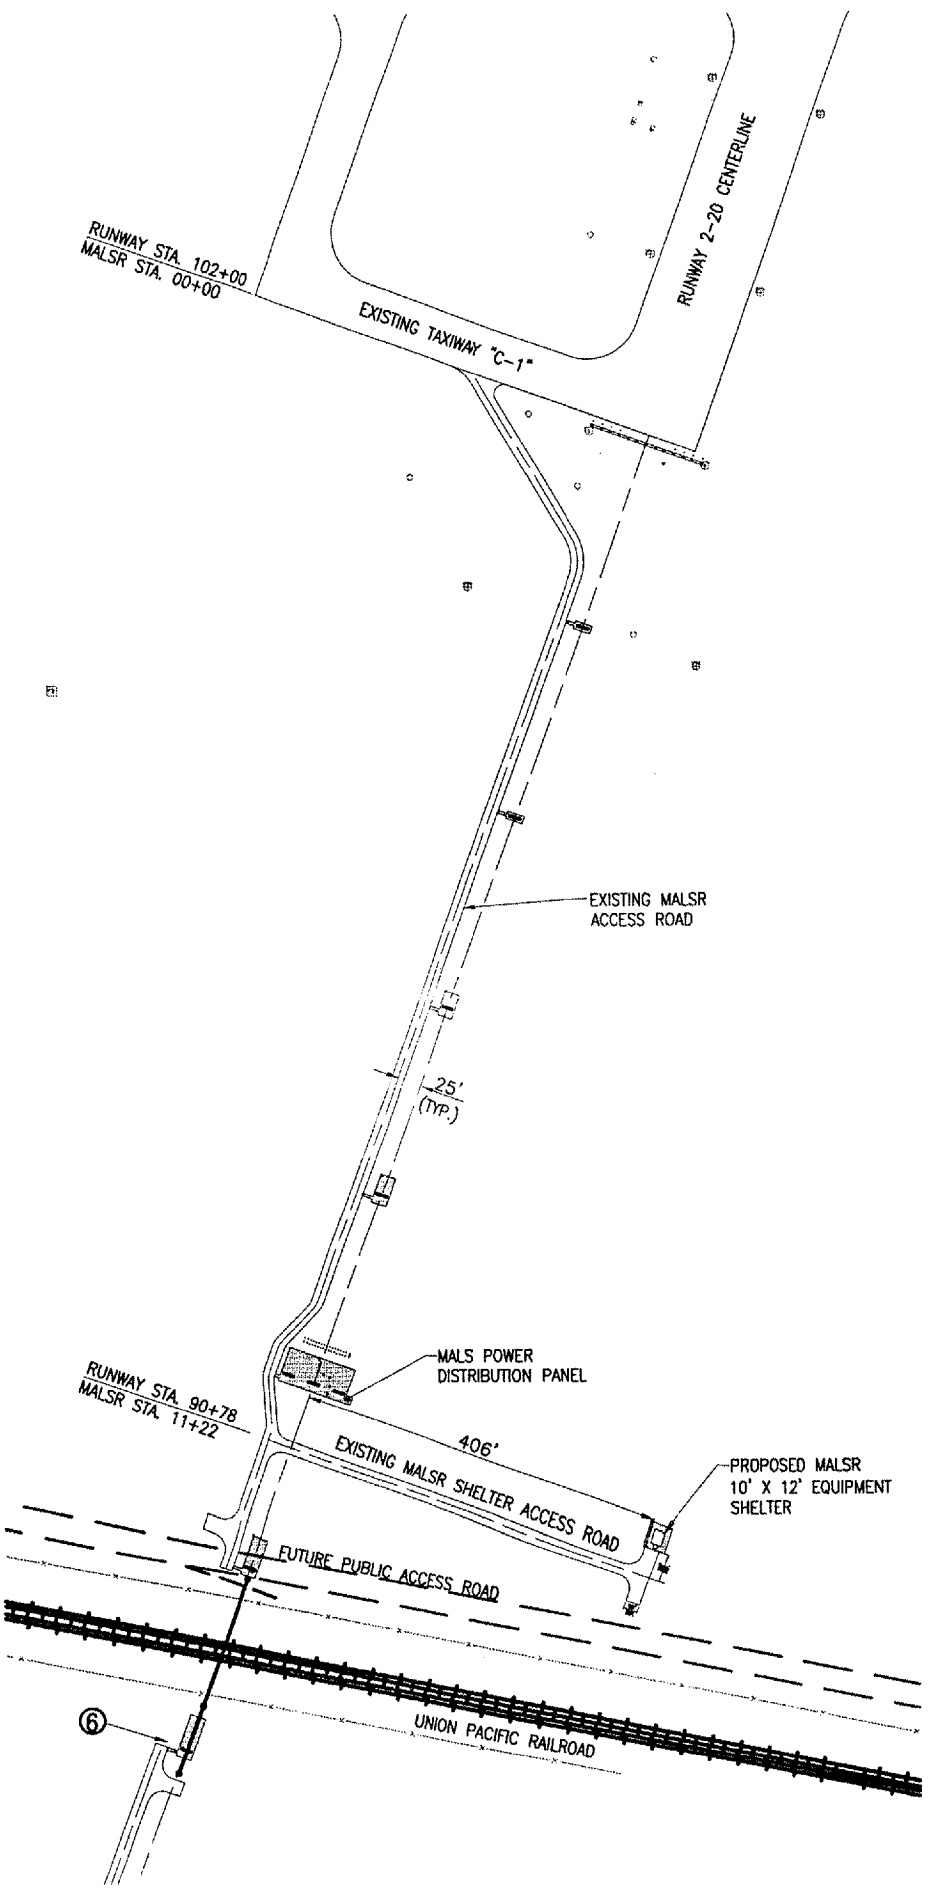

**NOTES:**

- COORDINATE ELECTRIC SERVICE WITH THE SERVING ELECTRIC UTILITY AND THE AIRPORT MANAGER. UTILITY CONTACT IS MR. JIM ACKERT, COM ED, 17028 S. STATE RT 23, DEKALB, IL 60115, PHONE 815-748-2271, FAX 815-748-2267. AIRPORT MANAGER IS MR. TOM CLEVELAND, CITY OF DEKALB AIRPORT DIVISION, 3232 PLEASANT STREET, DEKALB, IL 60115, PHONE 815-748-2020, FAX 815-748-2022.
- CONTRACTOR SHALL FURNISH & INSTALL UTILITY TRANSFORMER PAD PER SERVING ELECTRIC UTILITY CO. REQUIREMENTS. SEE "UTILITY TRANSFORMER PAD DETAIL" ON SHEET 42 FOR REQUIREMENTS.
- SEE MALS ELECTRICAL ONE LINE, RUNWAY 02, DKB-D-MALSRO2-E05 FOR ADDITIONAL REQUIREMENTS ON ELECTRIC SERVICE.

THE LOCATION, SIZE AND TYPE OF MATERIAL OF EXISTING UNDERGROUND UTILITIES INDICATED ON THE PLANS IS NOT REPRESENTED AS BEING ACCURATE, SUFFICIENT OR COMPLETE. IT SHALL BE THE CONTRACTOR'S RESPONSIBILITY TO DETERMINE THE ACTUAL LOCATION OF ALL SUCH FACILITIES, INCLUDING SERVICE CONNECTIONS TO UNDERGROUND UTILITIES. PRIOR TO CONSTRUCTION, THE CONTRACTOR SHALL NOTIFY THE UTILITY COMPANIES OF HIS OPERATIONAL PLANS AND SHALL OBTAIN FROM THE RESPECTIVE UTILITY COMPANIES DETAILED INFORMATION AND ASSISTANCE RELATIVE TO THE LOCATION OF THEIR FACILITIES AND THE WORKING SCHEDULE OF THE COMPANIES FOR REMOVAL OR ADJUSTMENT WHERE REQUIRED. IN THE EVENT AN UNEXPECTED UTILITY INTERFERENCE IS ENCOUNTERED DURING CONSTRUCTION, THE CONTRACTOR SHALL IMMEDIATELY NOTIFY THE UTILITY COMPANY OF JURISDICTION. THE ENGINEER SHALL ALSO BE IMMEDIATELY NOTIFIED. ANY SUCH MAINS AND SERVICES SHALL BE RESTORED TO SERVICE AT ONCE AND PAID FOR BY THE CONTRACTOR AT NO ADDITIONAL COST TO THE CONTRACT.

CALL J.U.L.I.E. FOR UTILITY INFORMATION AT 1-800-892-0123.

**LEGEND**

- EXISTING IMPROVEMENTS
- PROPOSED 209-CRUSHED AGGREGATE BASE COURSE (6" DEPTH)
- EXISTING STORM SEWER
- EXISTING UNDERDRAIN
- PROPOSED ELECTRIC CABLES
- PROPOSED UNDERGROUND ELECTRIC UTILITY PRIMARY
- EXISTING INLET
- EXISTING MANHOLE
- EXISTING UNDERAIN INSPECTION HOLE
- EXISTING HEADWALL
- UTILITY PAD MOUNT TRANSFORMER

