

 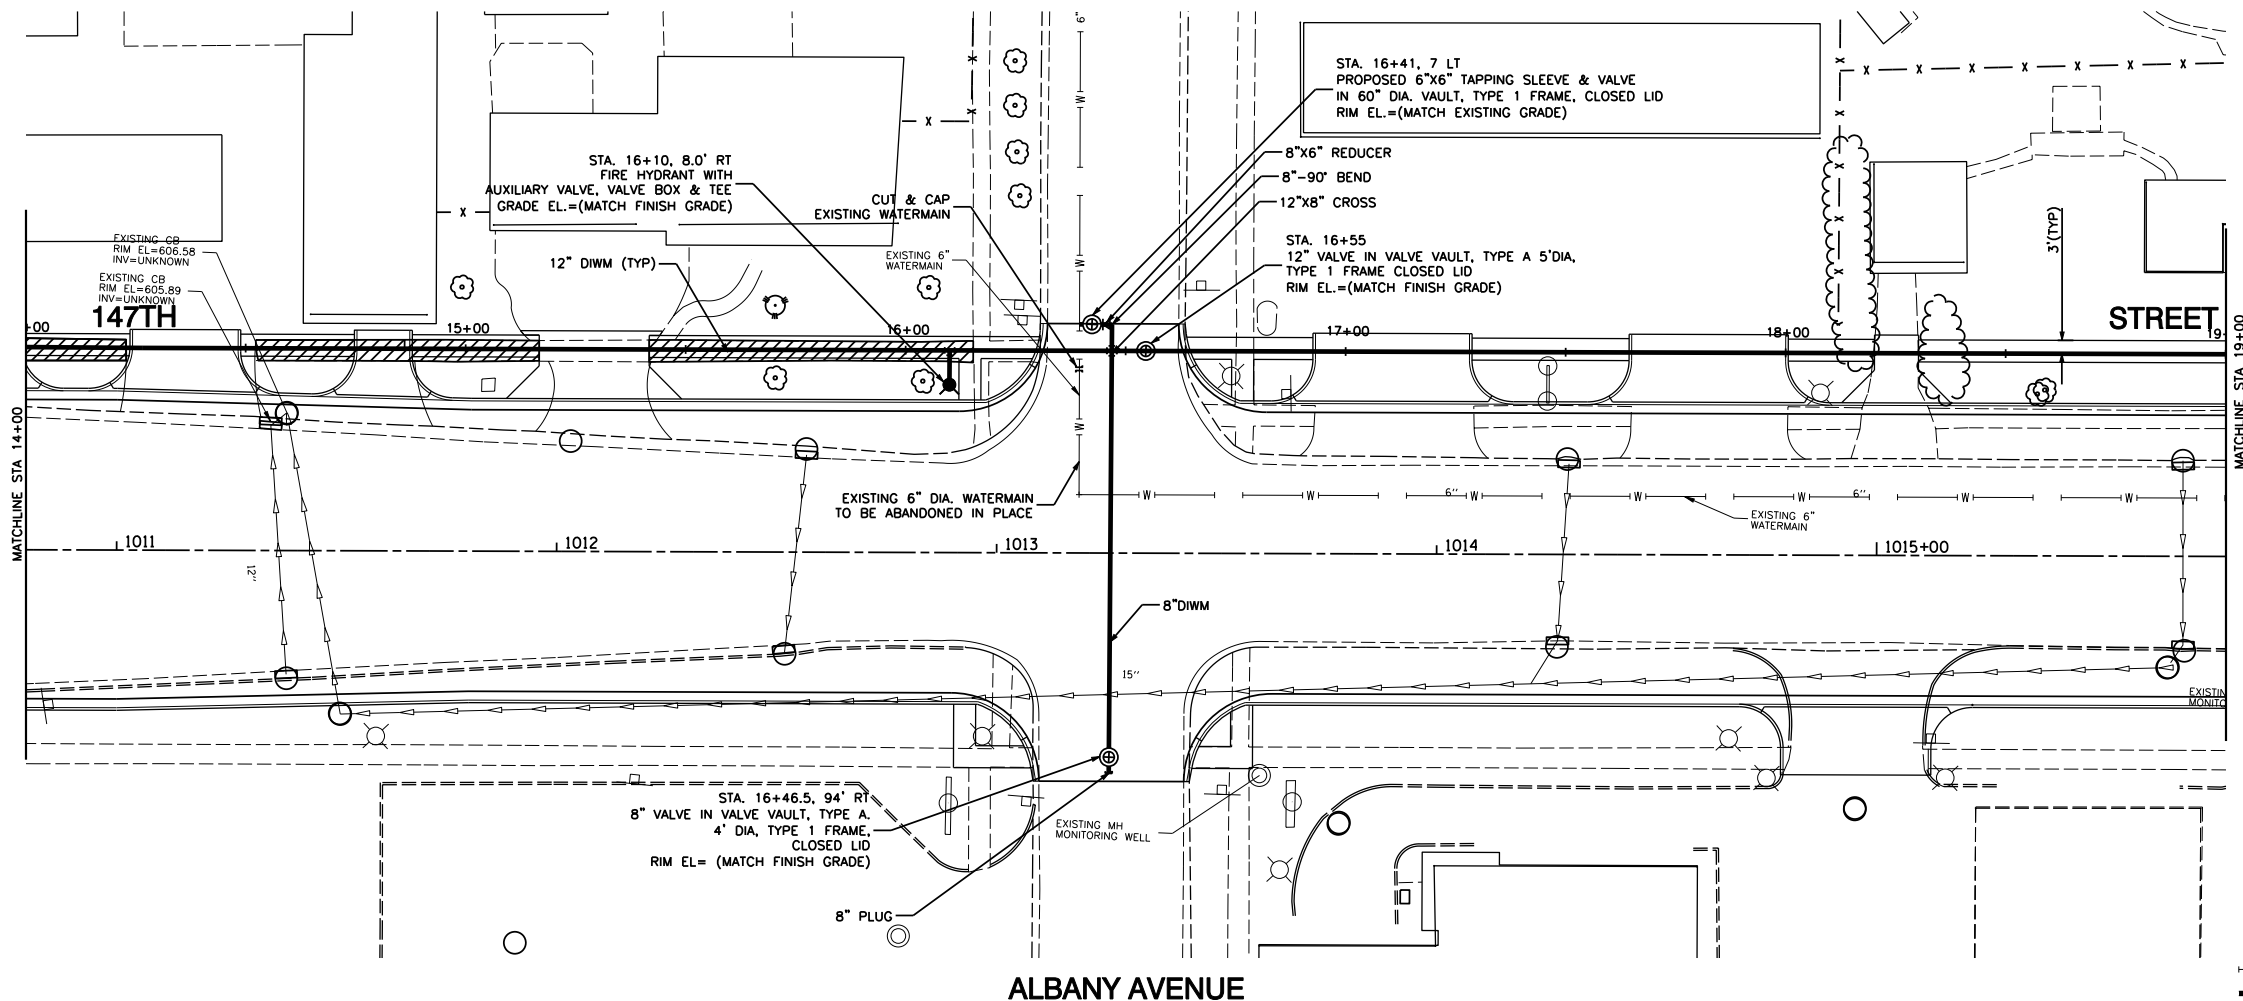


ALBANY AVENUE

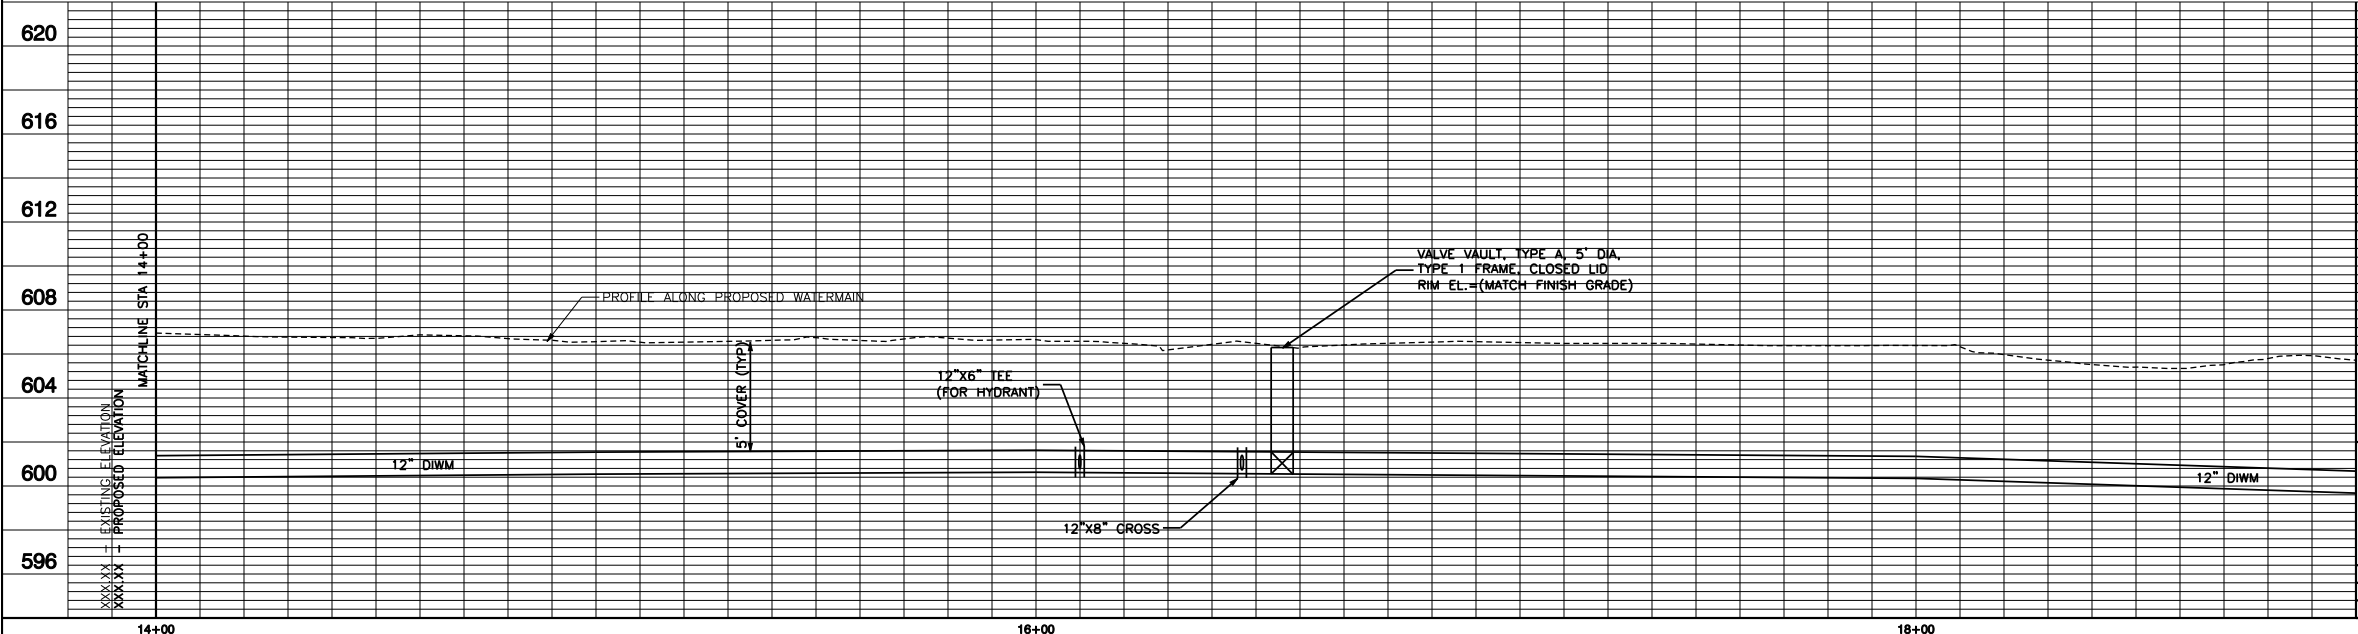

LEGEND:

- PROPOSED FIRE HYDRANT W/ AUX. VALVE, VALVE BOX & TEE
- PROPOSED VALVE VAULT, TYPE 1 FR., CL
- EXISTING WATER MAIN
- PROPOSED D.I.W.M., CLASS 52, WITH POLYETHYLENE ENCASEMENT
- EXISTING STORM SEWER
- SIDEWALK REMOVAL AND REPLACEMENT
- PORTLAND CEMENT CONCRETE 5 INCH
- AGGREGATE BASE COURSE, TYPE B 4 INCH



<p>ROBINSON ENGINEERING, LTD. CONSULTING REGISTERED PROFESSIONAL ENGINEERS AND PROFESSIONAL LAND SURVEYORS 17000 SOUTH PARK AVENUE SOUTH HOLLAND, ILLINOIS 60473 (708) 381-6700 FAX (708) 381-3826</p> <p>© COPYRIGHT 2011 ILLINOIS DESIGN FIRM REGISTRATION NO. 184001128.</p> <p>147TH STREET PROJECT PROPOSED WATERMAIN IMPROVEMENTS PLAN AND PROFILE STA 14+00 TO STA 19+00</p> <p>POSEN, ILLINOIS</p> <p>Drawn by: MED Date: 08/30/11 Checked by: VC Scale: H 1"= 20' V 1"= 4' Sheet 3 of 11 Project No. 10-432</p>		<p>REVISIONS</p> <table border="1"> <thead> <tr> <th>No.</th> <th>Date</th> <th>Remarks</th> </tr> </thead> <tbody> <tr> <td> </td> <td> </td> <td> </td> </tr> <tr> <td> </td> <td> </td> <td> </td> </tr> </tbody> </table>		No.	Date	Remarks						
		No.	Date	Remarks								