


I-294 NORHTBOUND

MOZART AVENUE

- LEGEND:**
- PROPOSED FIRE HYDRANT W/ AUX. VALVE, VALVE BOX & TEE
 - PROPOSED VALVE VAULT, TYPE 1 FR., CL
 - EXISTING WATER MAIN
 - PROPOSED D.I.W.M., CLASS 52, WITH POLYETHYLENE ENCASEMENT
 - EXISTING STORM SEWER
 - SIDEWALK REMOVAL AND REPLACEMENT
-PORTLAND CEMENT CONCRETE 5 INCH
-AGGREGATE BASE COURSE, TYPE B 4 INCH

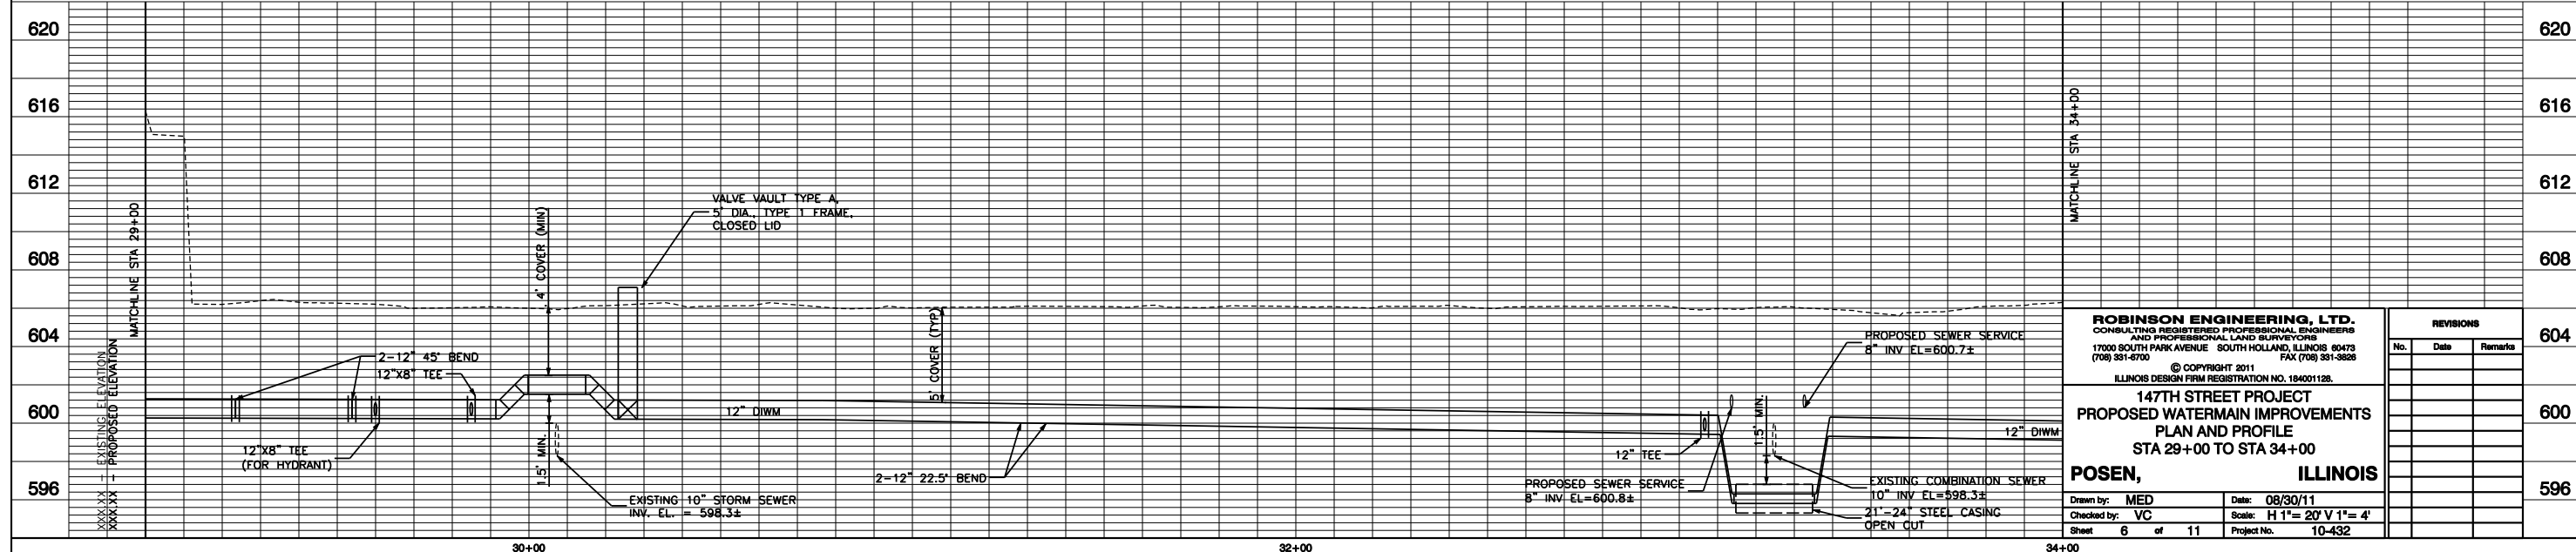

| <p>ROBINSON ENGINEERING, LTD. CONSULTING REGISTERED PROFESSIONAL ENGINEERS AND PROFESSIONAL LAND SURVEYORS 17000 SOUTH PARK AVENUE SOUTH HOLLAND, ILLINOIS 60473 (708) 381-6700 FAX (708) 381-3828</p> <p>© COPYRIGHT 2011 ILLINOIS DESIGN FIRM REGISTRATION NO. 184001128.</p> <p>147TH STREET PROJECT PROPOSED WATERMAIN IMPROVEMENTS PLAN AND PROFILE STA 29+00 TO STA 34+00</p> <p>POSEN, ILLINOIS</p> <p>Drawn by: MED Date: 08/30/11 Checked by: VC Scale: H 1"= 20' V 1"= 4' Sheet 6 of 11 Project No. 10-432</p> | | <p>REVISIONS</p> <table border="1"> <thead> <tr> <th>No.</th> <th>Date</th> <th>Remarks</th> </tr> </thead> <tbody> <tr> <td> </td> <td> </td> <td> </td> </tr> <tr> <td> </td> <td> </td> <td> </td> </tr> <tr> <td> </td> <td> </td> <td> </td> </tr> </tbody> </table> | No. | Date | Remarks | | | | | | | | | |
|---|------|--|-----|------|---------|--|--|--|--|--|--|--|--|--|
| No. | Date | Remarks | | | | | | | | | | | | |
| | | | | | | | | | | | | | | |
| | | | | | | | | | | | | | | |
| | | | | | | | | | | | | | | |