


- NOTES:**
- REFER TO TRAFFIC SIGNAL PLANS FOR LOCATIONS OF COMBINATION POLES.
  - CONTROLLER FOUNDATION SHALL BE PER DISTRICT ONE DETAIL BE-205.

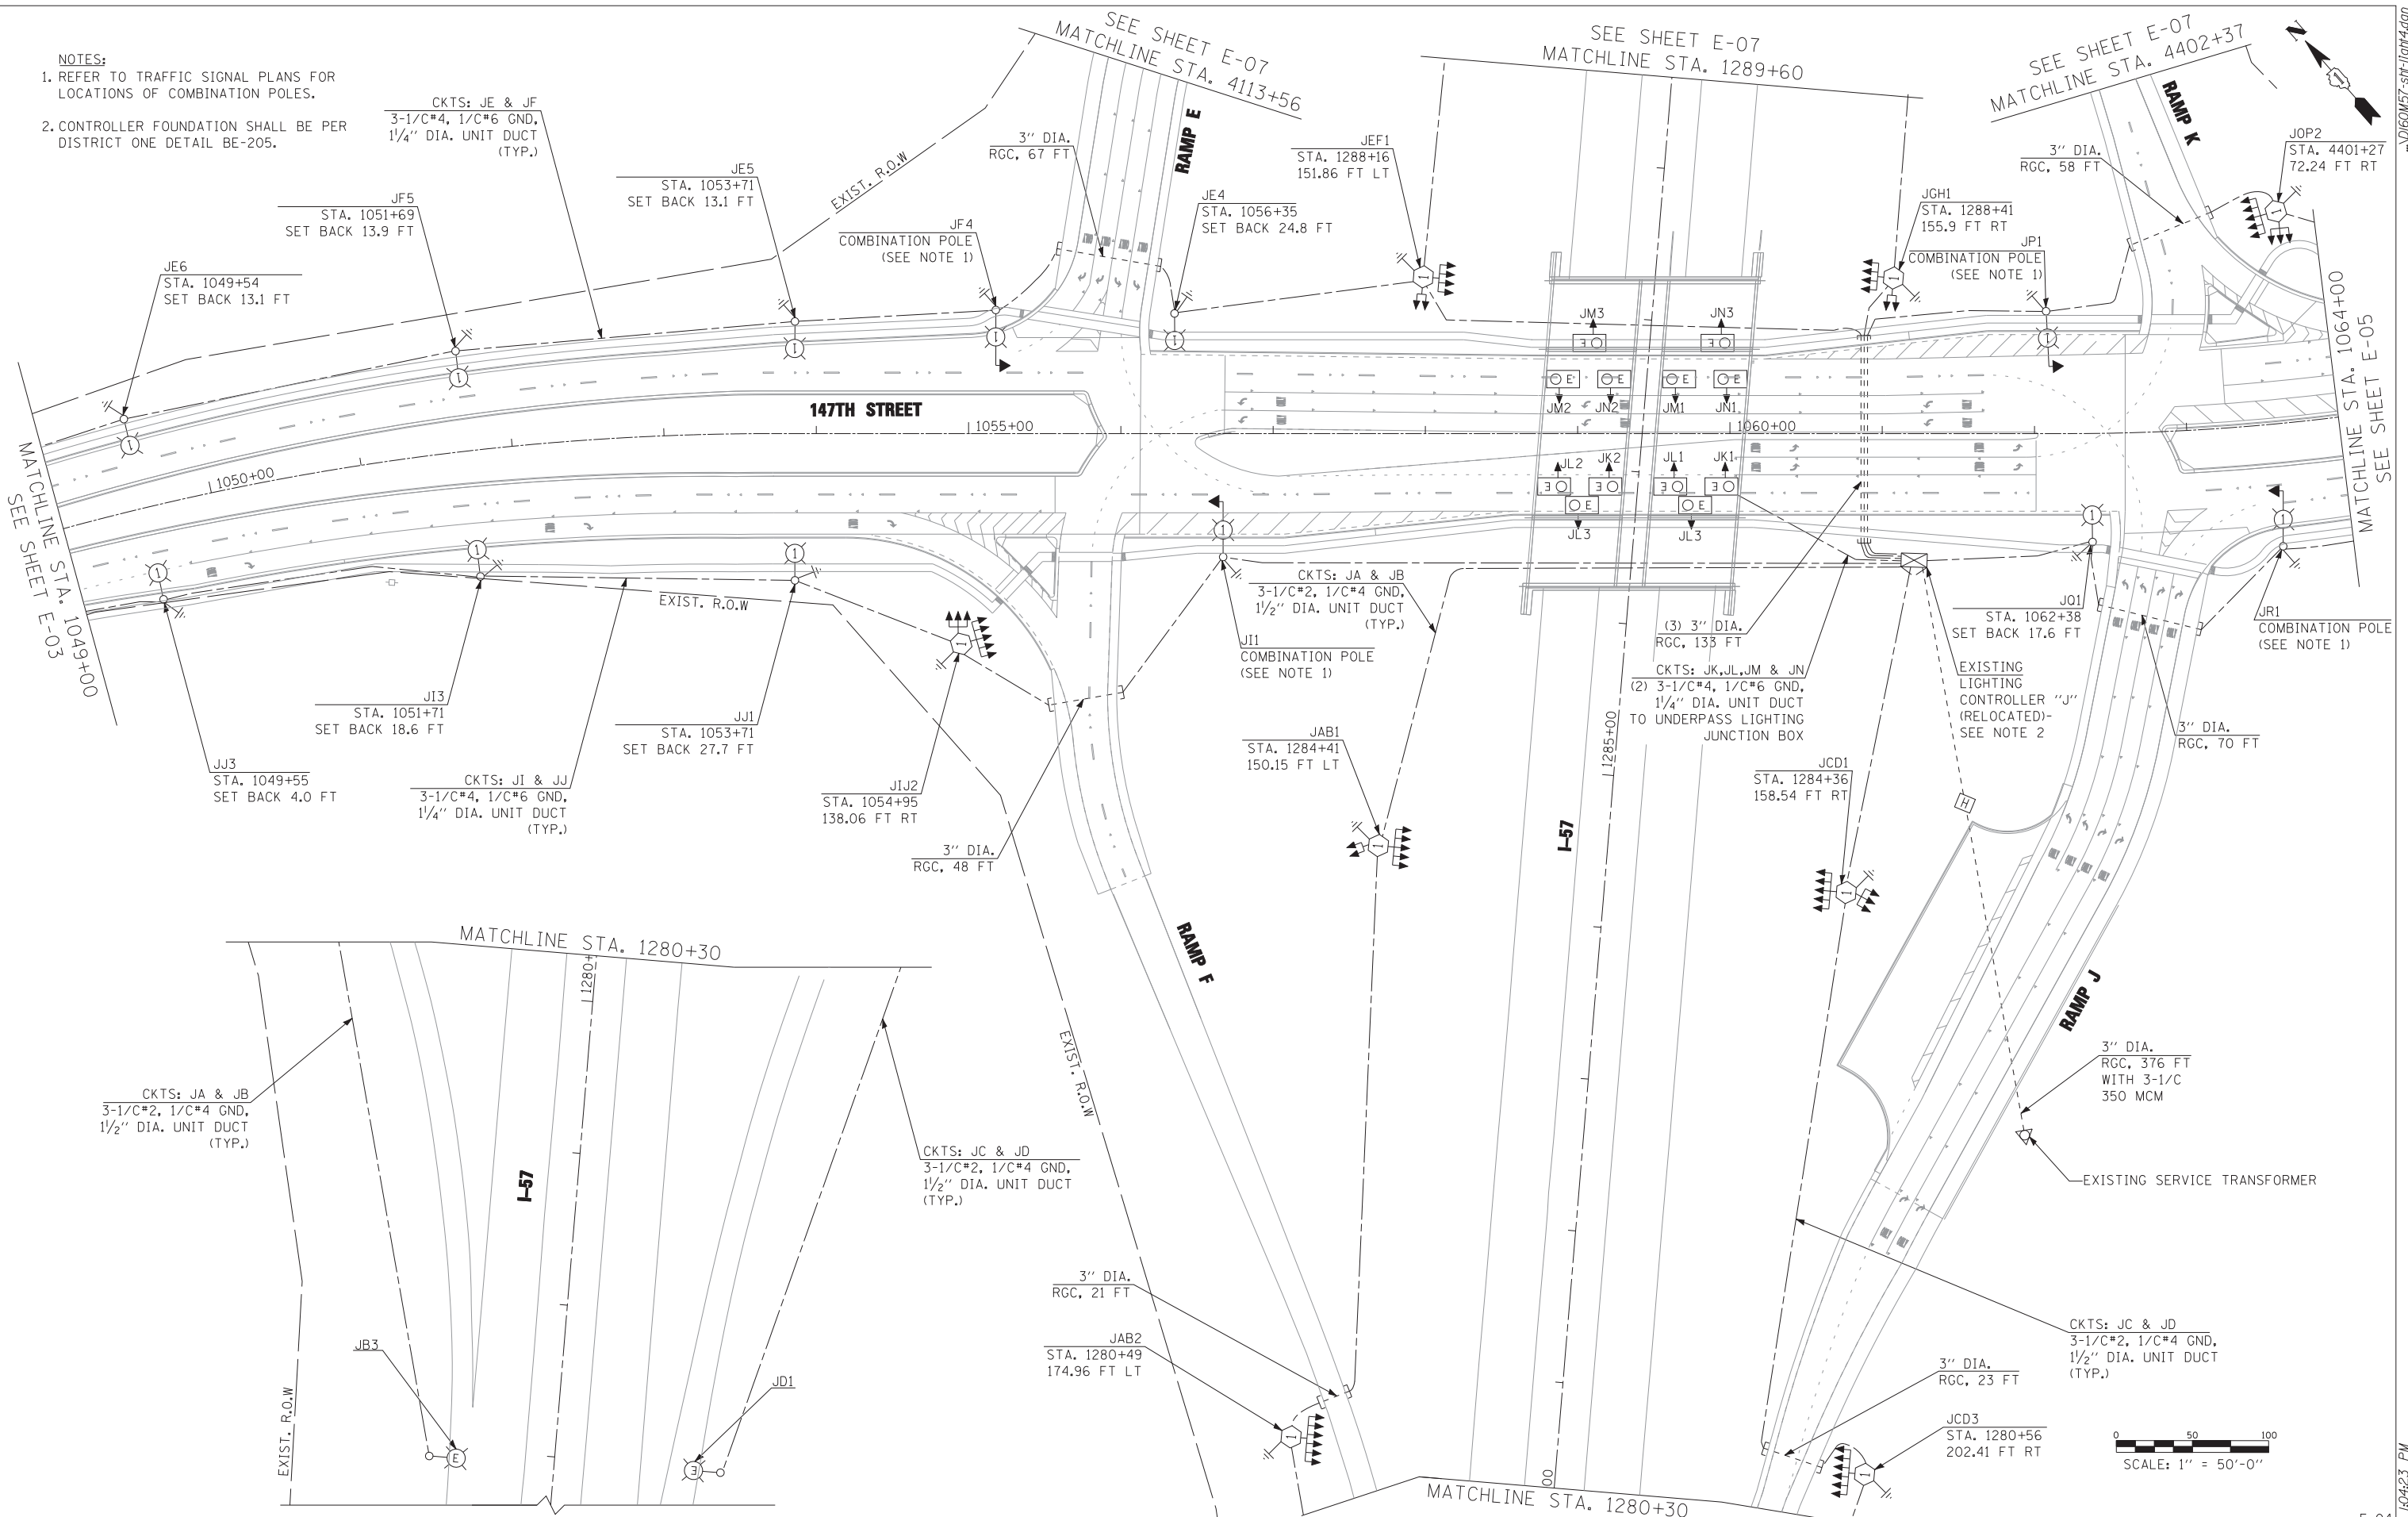

**EJM ENGINEERING, INC.**  
 411 South Wells Street Suite 1000  
 Chicago, Illinois 60607

USER NAME = rswanson	DESIGNED - RDP	REVISED -
PLOT SCALE = 50:1	DRAWN - PS	REVISED -
PLOT DATE = 4/23/2012	CHECKED - RAS	REVISED -
	DATE - 04/20/2012	REVISED -

**STATE OF ILLINOIS  
 DEPARTMENT OF TRANSPORTATION**

**147TH STREET  
 PROPOSED LIGHTING PLAN**

SCALE: 1"=50' SHEET NO. 3 OF 6 SHEETS STA. 1049+00 TO STA. 1064+00

F.A.I. RTE.	SECTION	COUNTY	TOTAL SHEETS	SHEET NO.
	(0405-1 & 0506-2) R-1	COOK	577	420
FED. ROAD DIST. NO.	ILLINOIS FED. AID PROJECT		CONTRACT NO.	60M57

