
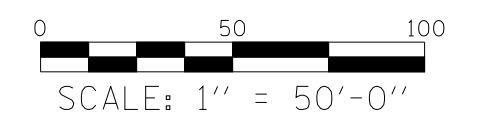


...\\D160M57-sht-light6.dgn

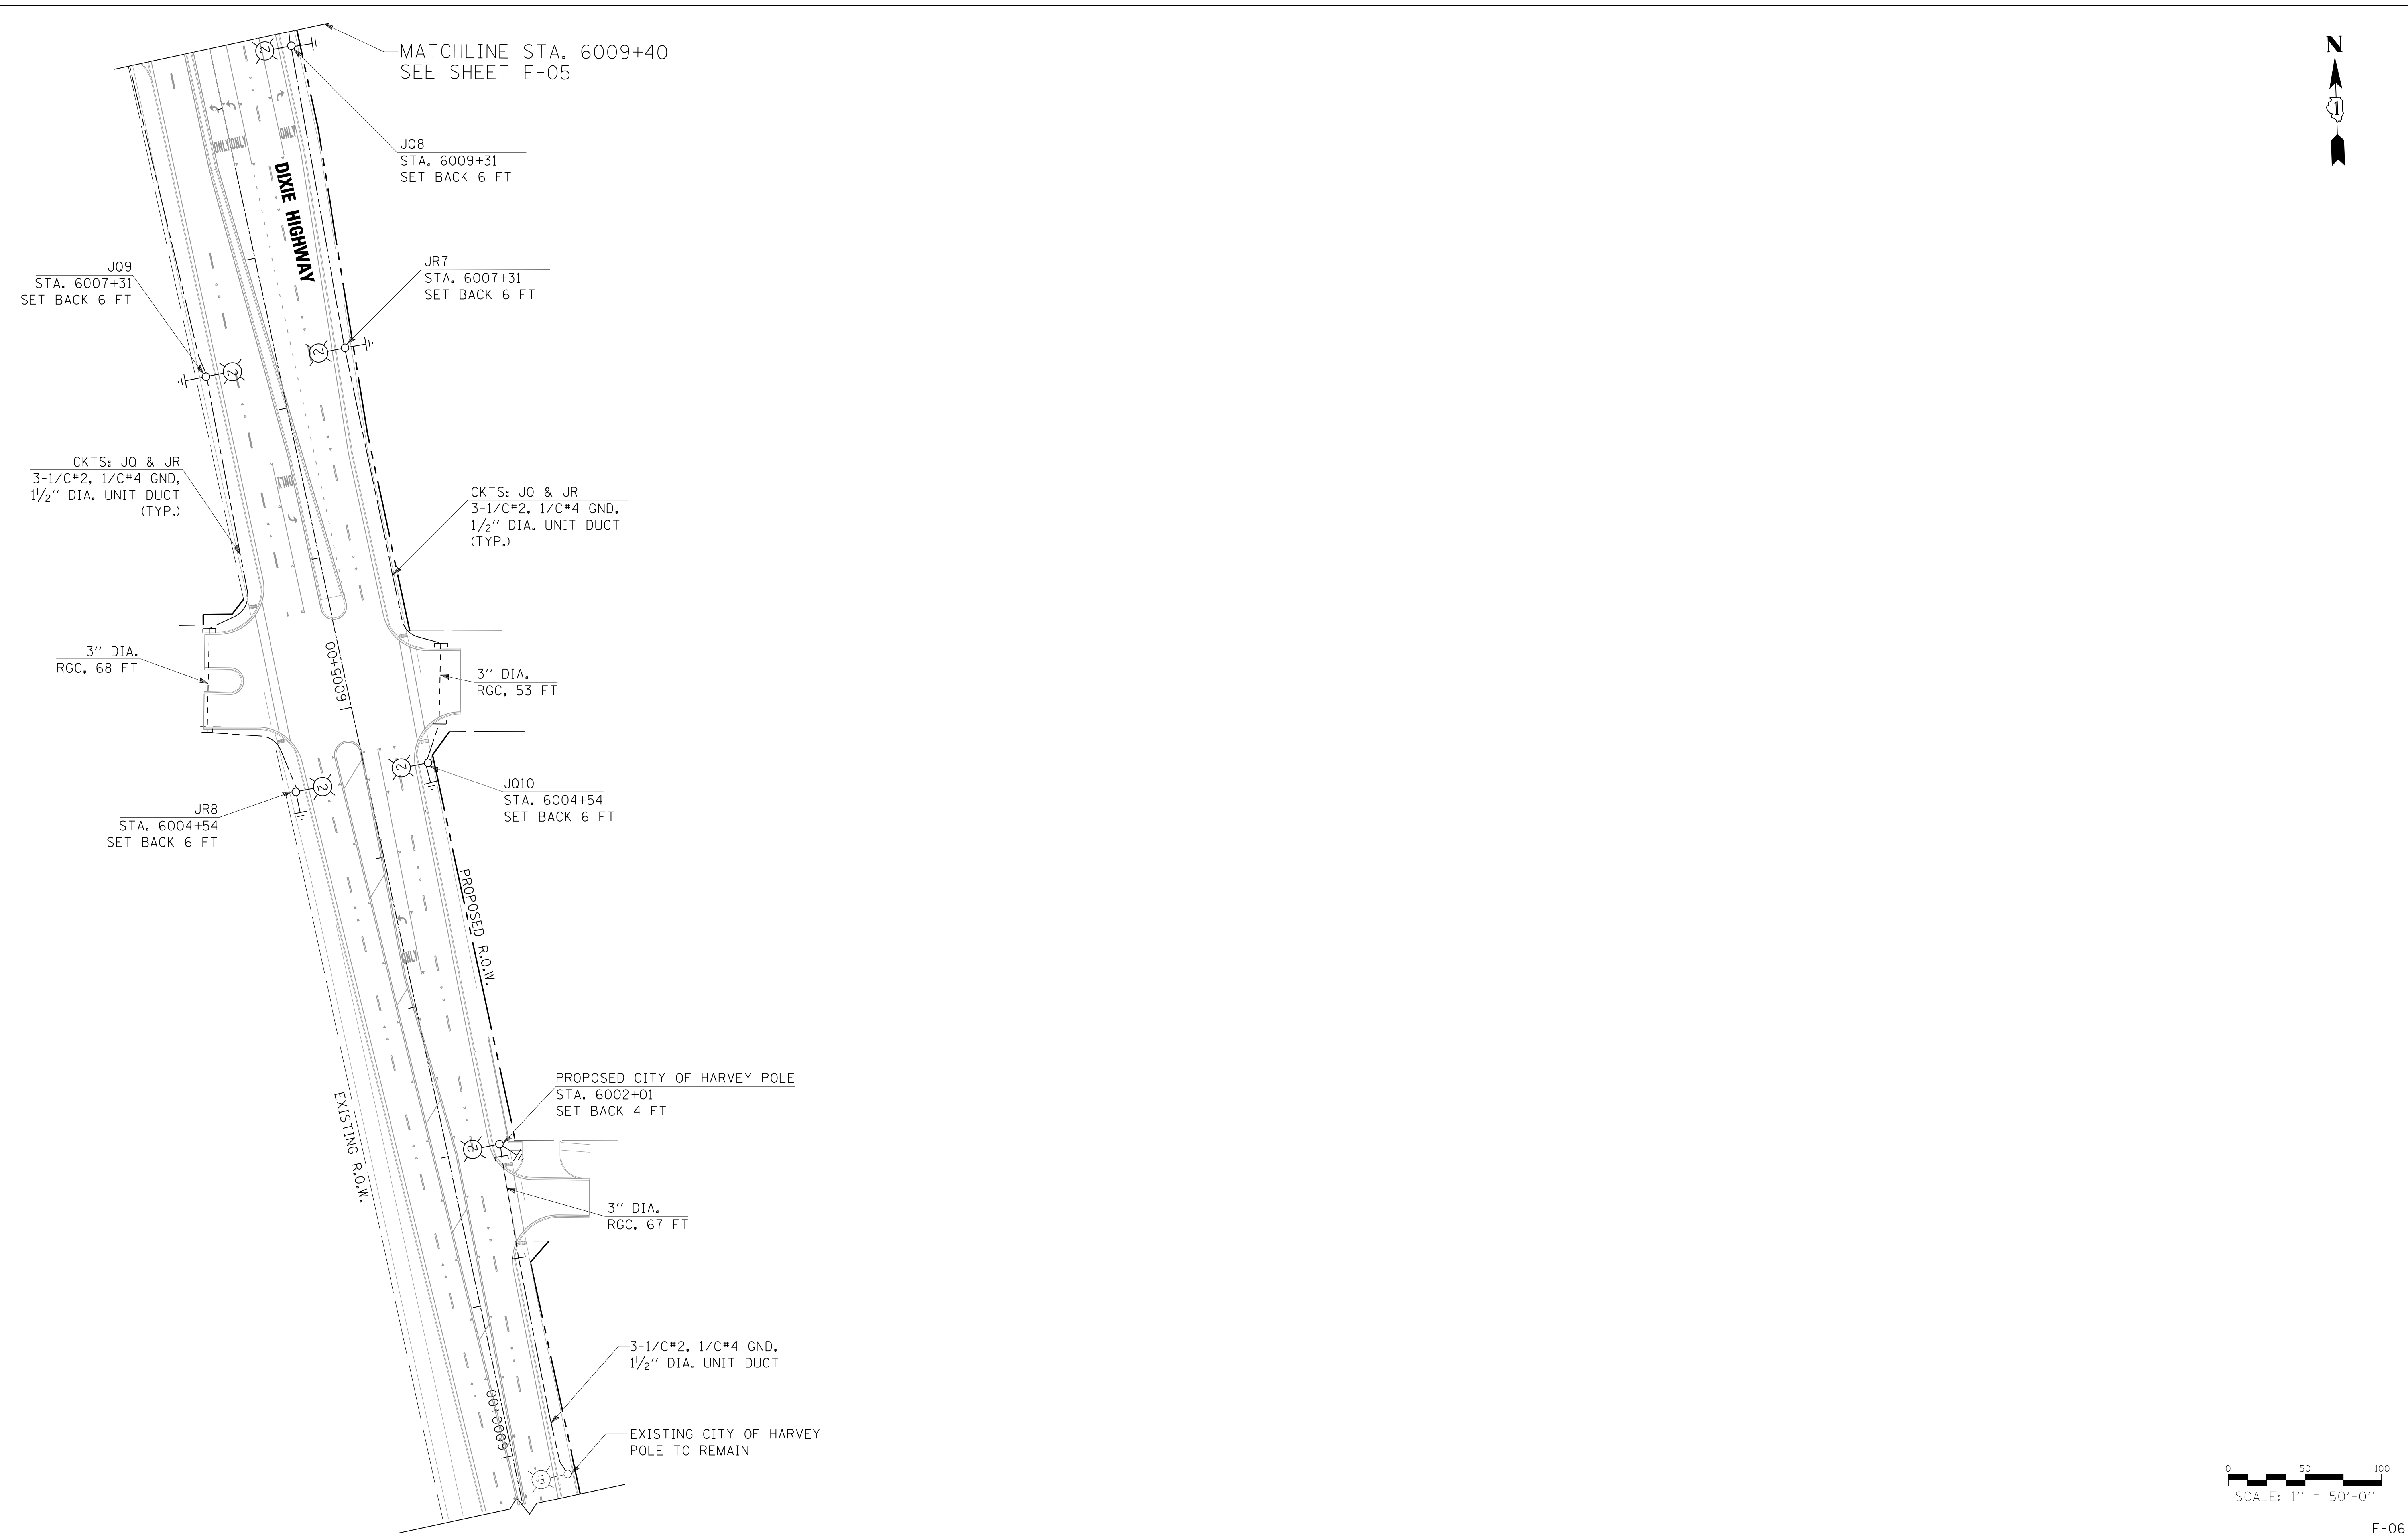

<p><b>EJM ENGINEERING, INC.</b> 411 South Wells Street Suite 1000 Chicago, Illinois 60607</p>	USER NAME = rswanson	DESIGNED - RDP	REVISED -
	PLOT SCALE = 50:1	DRAWN - PS	REVISED -
	PLOT DATE = 6/28/2012	CHECKED - RAS	REVISED -
		DATE - 04/20/2012	REVISED -

**STATE OF ILLINOIS**  
**DEPARTMENT OF TRANSPORTATION**

<b>147TH STREET</b> <b>PROPOSED LIGHTING PLAN</b>			
SCALE: 1"=50'	SHEET NO. 5 OF 6 SHEETS	STA. 5999+67 TO STA. 6023+00	

F.A.I. RTE.	SECTION	COUNTY	TOTAL SHEETS	SHEET NO.
	(0405-1 & 0506-2) R-1	COOK	577	422
CONTRACT NO. 60M57				
FED. ROAD DIST. NO.	ILLINOIS FED. AID PROJECT			

...\\D160M57-sht-light6.dgn

3:37:46 PM  
6/28/2012