


DEMOLITION

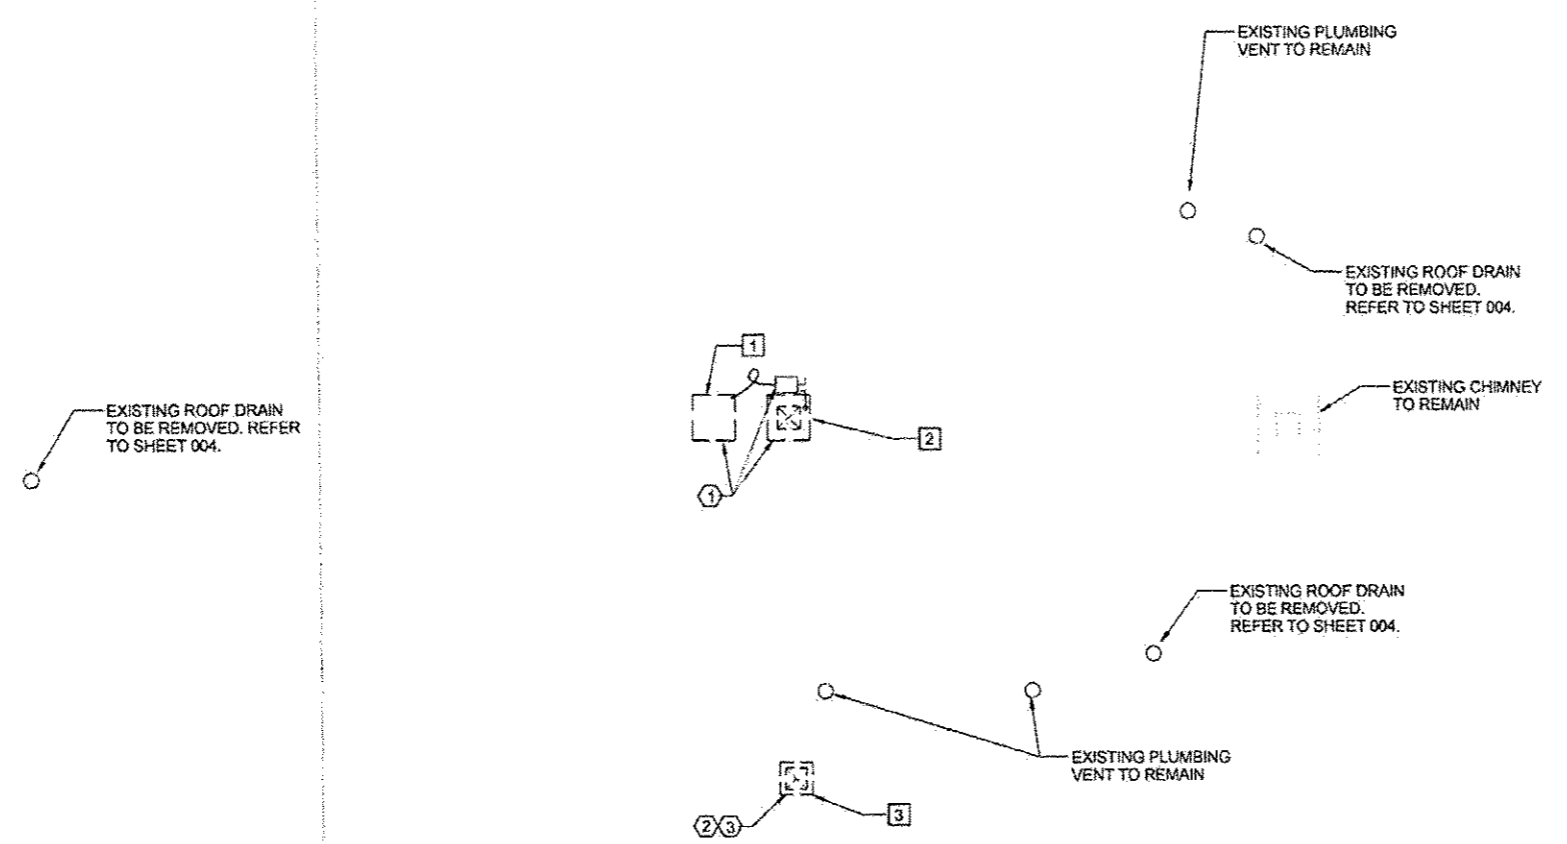

- MECHANICAL KEYED NOTES - DEMOLITION**
- 1 RECOVER SYSTEM REFRIGERANT FOR SAFE DISPOSAL. REFRIGERANT LINE SET CONNECTING EXISTING ROOF MOUNTED DX SPLIT SYSTEM AIR COOLED CONDENSING UNIT AND SECOND FLOOR FAN COIL UNIT SHALL BE REMOVED AND DISPOSED OF. CONDENSING UNIT SHALL THEN BE REMOVED FROM THE ROOF AND STORED IN A SECURE LOCATION DESIGNATED BY ENGINEER UNTIL REINSTALLATION AFTER THE INSTALLATION OF NEW ROOFING SYSTEM IS COMPLETE. REFER TO NEW WORK SHEETS FOR INFORMATION REGARDING THE REINSTALLATION OF CONDENSING UNIT. TEMPORARILY CAP OPEN ENDS OF PIPING AT CONDENSING UNIT AND AHU.
 - 2 REMOVE AND DISPOSE OF EXISTING GOOSENECK GRAVITY VENTILATOR. REFER TO NEW WORK SHEETS FOR INFORMATION REGARDING THE INSTALLATION OF A NEW GRAVITY INTAKE VENTILATOR IN THE SAME LOCATION.
 - 3 REMOVE AND DISPOSE OF EXISTING RESTROOM EXHAUST FAN AND MOTORIZED DAMPER INSTALLED IN EXISTING EXHAUST DUCT. REFER TO NEW WORK SHEETS FOR INFORMATION REGARDING THE INSTALLATION OF A NEW RESTROOM EXHAUST FAN IN THE SAME LOCATION.

- ELECTRICAL KEYED NOTES - DEMOLITION**
- 1 DISCONNECT AND REMOVE ELECTRICAL CIRCUIT TO CONDENSING UNIT BACK TO DISCONNECT AT SECOND FLOOR. REMOVE EXISTING DISCONNECT SWITCH ON ROOF.
 - 2 DISCONNECT ELECTRICAL CIRCUIT TO EXHAUST FAN. PROTECT CIRCUIT AND RECONNECT TO NEW EXHAUST FAN. SEE NEW WORK PLANS.
 - 3 DISCONNECT EXISTING MOTORIZED DAMPER. REMOVE CONDUIT AND WIRE COMPLETE. NEW DAMPER WILL BE NON-POWERED.

MECHANICAL & ELECTRICAL ROOF PLAN - DEMOLITION

2
1/4" = 1'-0"

ASIP T. KADIANI
 082-047857
 State of Illinois
 Date: 8-31-2012
 Lic. Exp: 11-30-2013
 (For Mechanical System)

	USER NAME: #	DESIGNED: JPD/ATK	REVISED: 09/04/12 NEWLY ADDED SHEET	STATE OF ILLINOIS DEPARTMENT OF TRANSPORTATION	MECHANICAL & ELECTRICAL ROOF PLAN - DEMOLITION	F.P. RTE.	SECTION	COUNTY	TOTAL SHEETS	SHEET NO.		
	PLOT SCALE: #	DRAWN: HWH	REVISED:				2012-0451	WILL	11	0011A		
	PLOT DATE: #	CHECKED: JPD	REVISED:				CONTRACT NO. 60V37					
		APPROVED: ATK	REVISED:				ILLINOIS FED AID PROJECT					