
 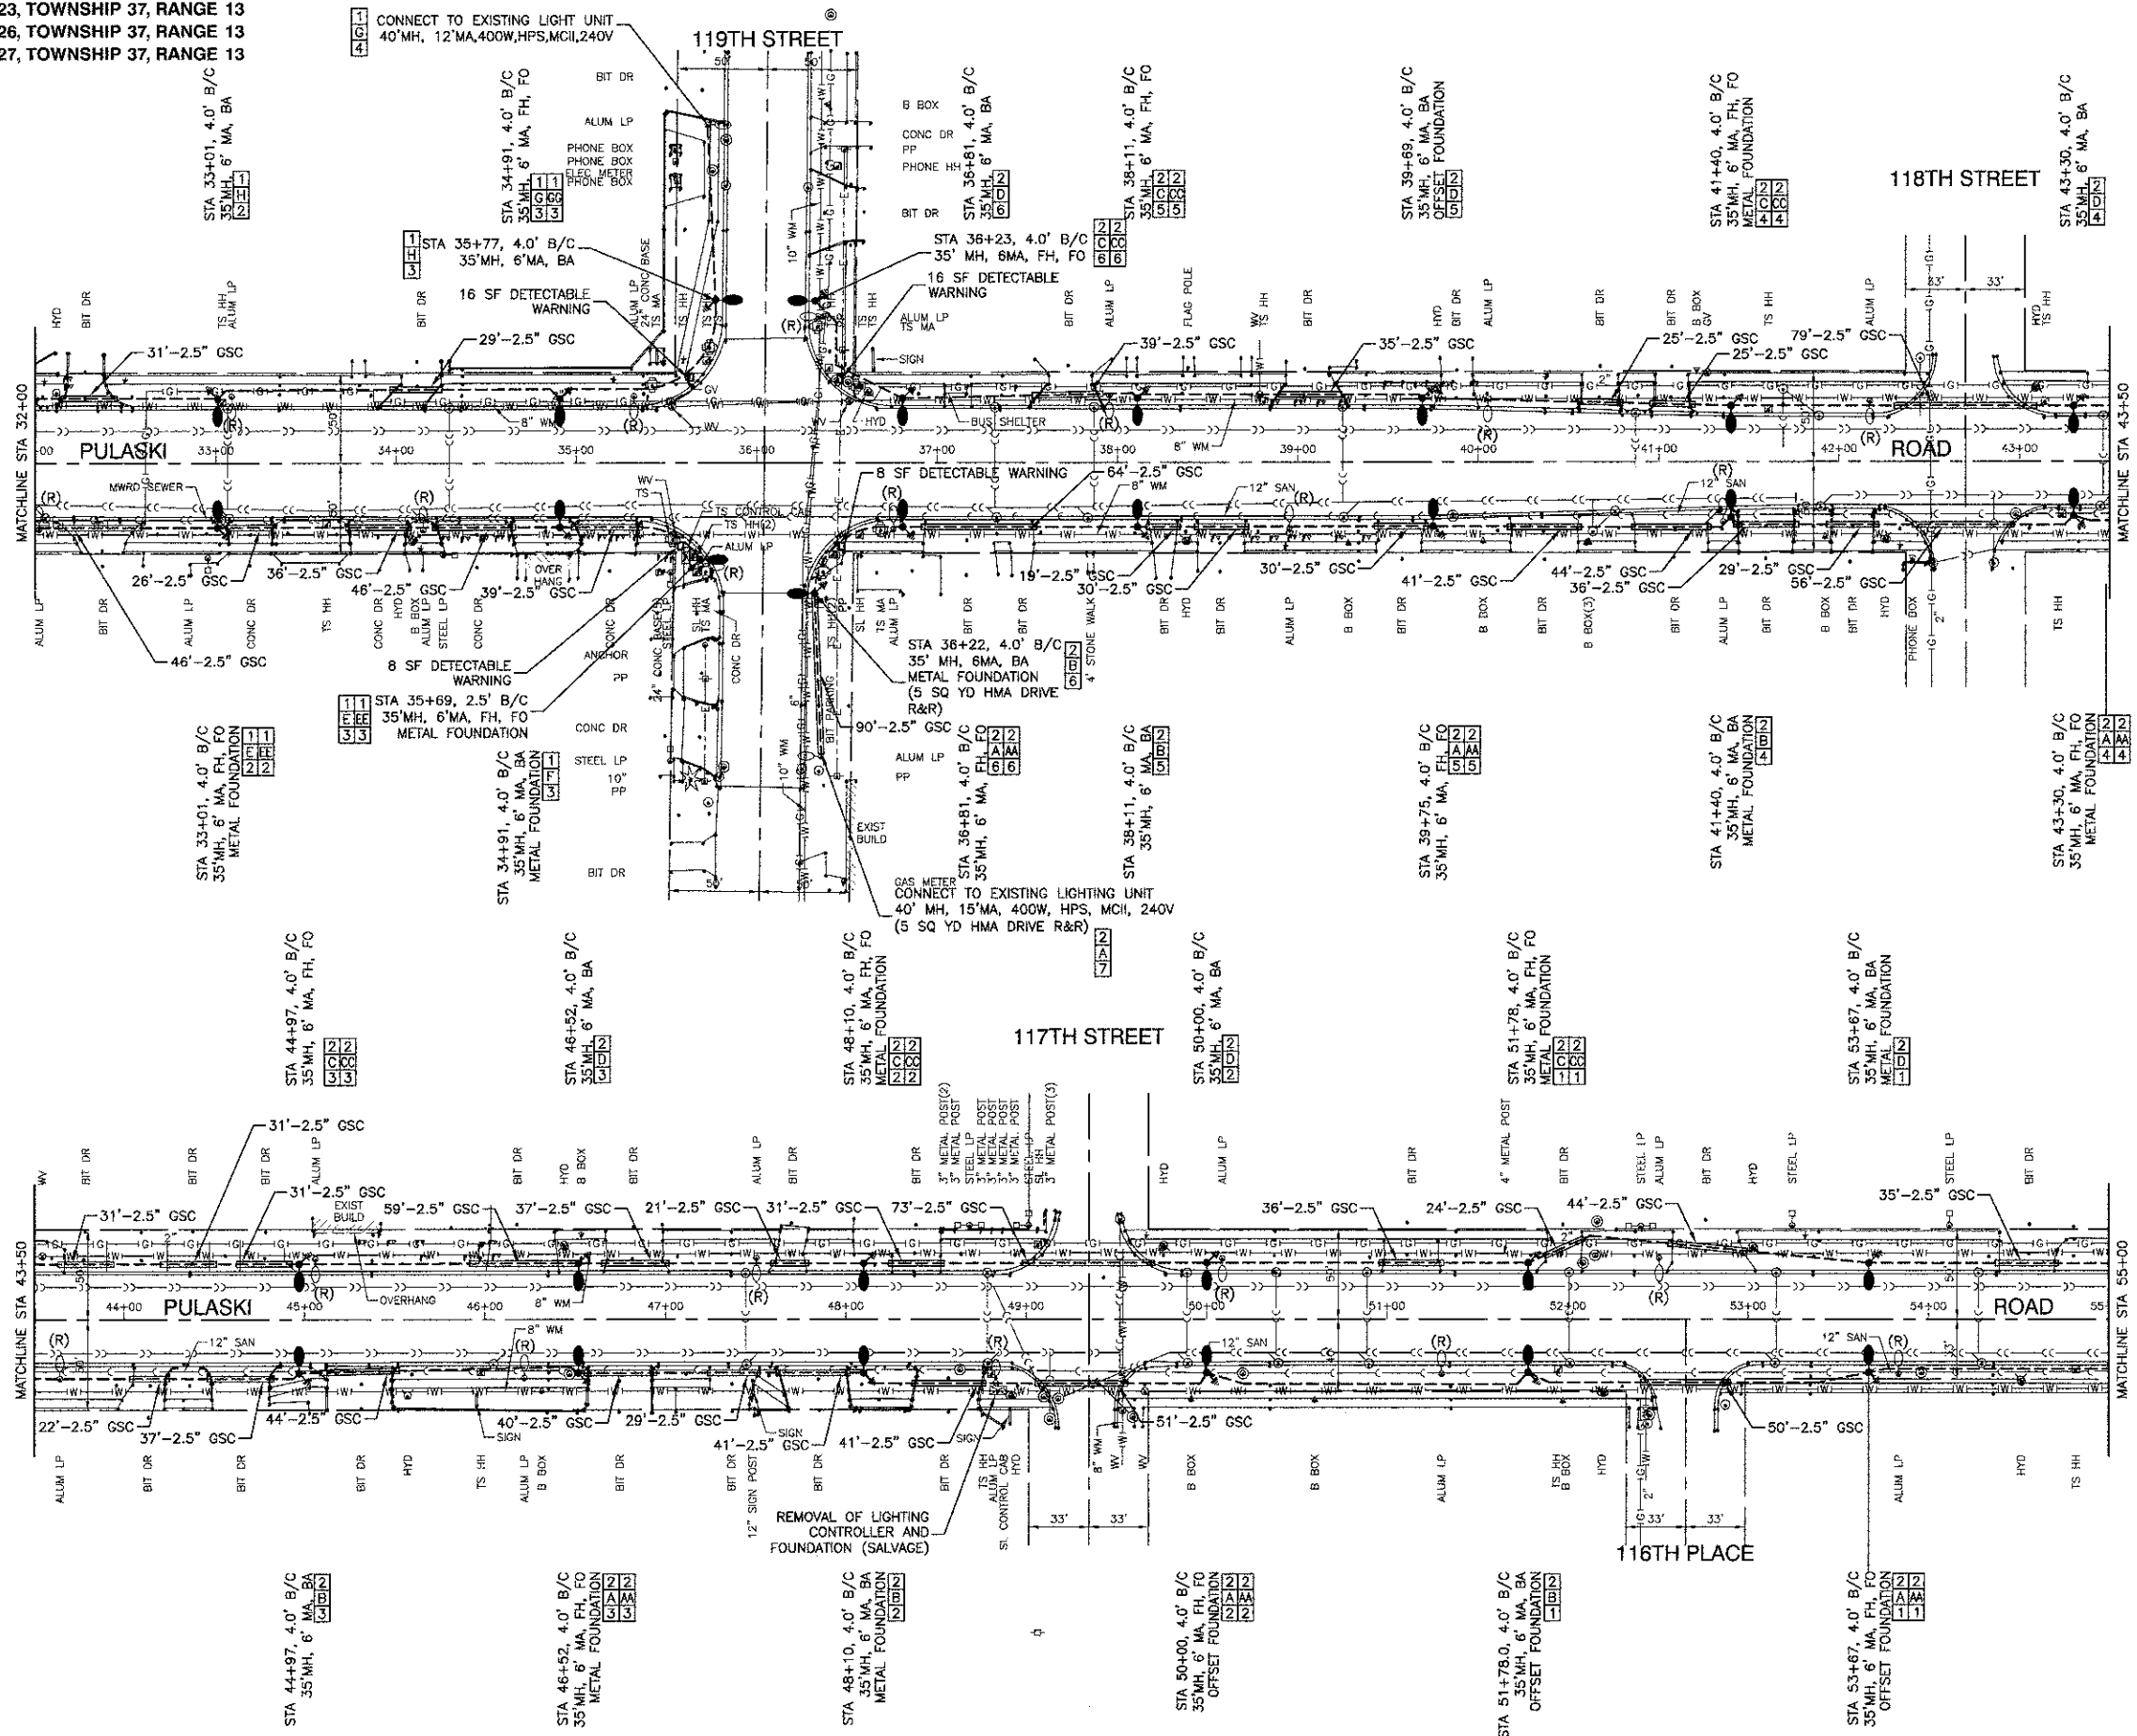


SECTION 22, TOWNSHIP 37, RANGE 13
 SECTION 23, TOWNSHIP 37, RANGE 13
 SECTION 26, TOWNSHIP 37, RANGE 13
 SECTION 27, TOWNSHIP 37, RANGE 13



- LEGEND:**
- EXISTING STREET LIGHT
 - PROPOSED STREET LIGHT -- 315W CMH & 35 W LED
 - PROPOSED CONTROLLER
 - UNDERGROUND CONDUIT, GALVANIZED STEEL (GSC)
 - - - UNIT DUCT, 5-1/2", NO.4 AWG AND NO.6 GROUND, 600V IN 1-1/2" DUCT
 - ==== SERVICE WIRE, 3-1/2", NO. 1/0 AWG.
 - GR GROUND ROD, 5/8" DIA. x 10'
 - (R) REMOVAL OF EXISTING STREET LIGHT (SALVAGE)
 - (RO) REMOVAL OF EXISTING STREET LIGHT (BY OTHERS)
 - MH MOUNTING HEIGHT
 - MA MAST ARM
 - B/C BACK OF CURB -- SETBACK MEASURED FROM BACK OF CURB TO CENTER OF POLE
 - FO FESTOON OUTLET
 - FH FLAG HOLDER
 - BA BANNER ARMS
- POLE IDENTIFICATION**
- 1 CABINET NUMBER
 - 2 CIRCUIT
 - 3 POLE POSITION

FILE NAME = 06626_02-PLAN-01 - IDOT P02

USER NAME =	DESIGNED -- DWS	REVISED --
	CHECKED -- PAP	REVISED --
PLOT SCALE =	DRAWN -- MED	REVISED --
PLOT DATE = 06/27/12	CHECKED -- AG	REVISED --

STATE OF ILLINOIS
 DEPARTMENT OF TRANSPORTATION

PULASKI ROAD
 STREET LIGHTING
 STREET LIGHTING PLANS

SCALE: 1"=50' SHEET NO. 5 OF 17 SHEETS STA. 32+00 TO STA. 55+00

F.A.U. RITE.	SECTION	COUNTY	TOTAL SHEETS	SHEET NO.
3778	06-00082-01-LT	COOK	17	5
CONTRACT NO. 6372Lb				
RED. ROAD DIST. NO. 1 ILLINOIS FED. AID PROJECT HPP M-9003(774)				

PREPARED BY:
 Robinson ENGINEERING