




PLAN	SURVEYED	DATE
	PLOTTED	BY
	CHECKED	
	AT	
	FILE NAME	
	NO.	

PROFILE	SURVEYED	DATE
	PLOTTED	BY
	CHECKED	
	AT	
	STRUCTURE	
	NOT AT THIS OFFICE	
	NO.	

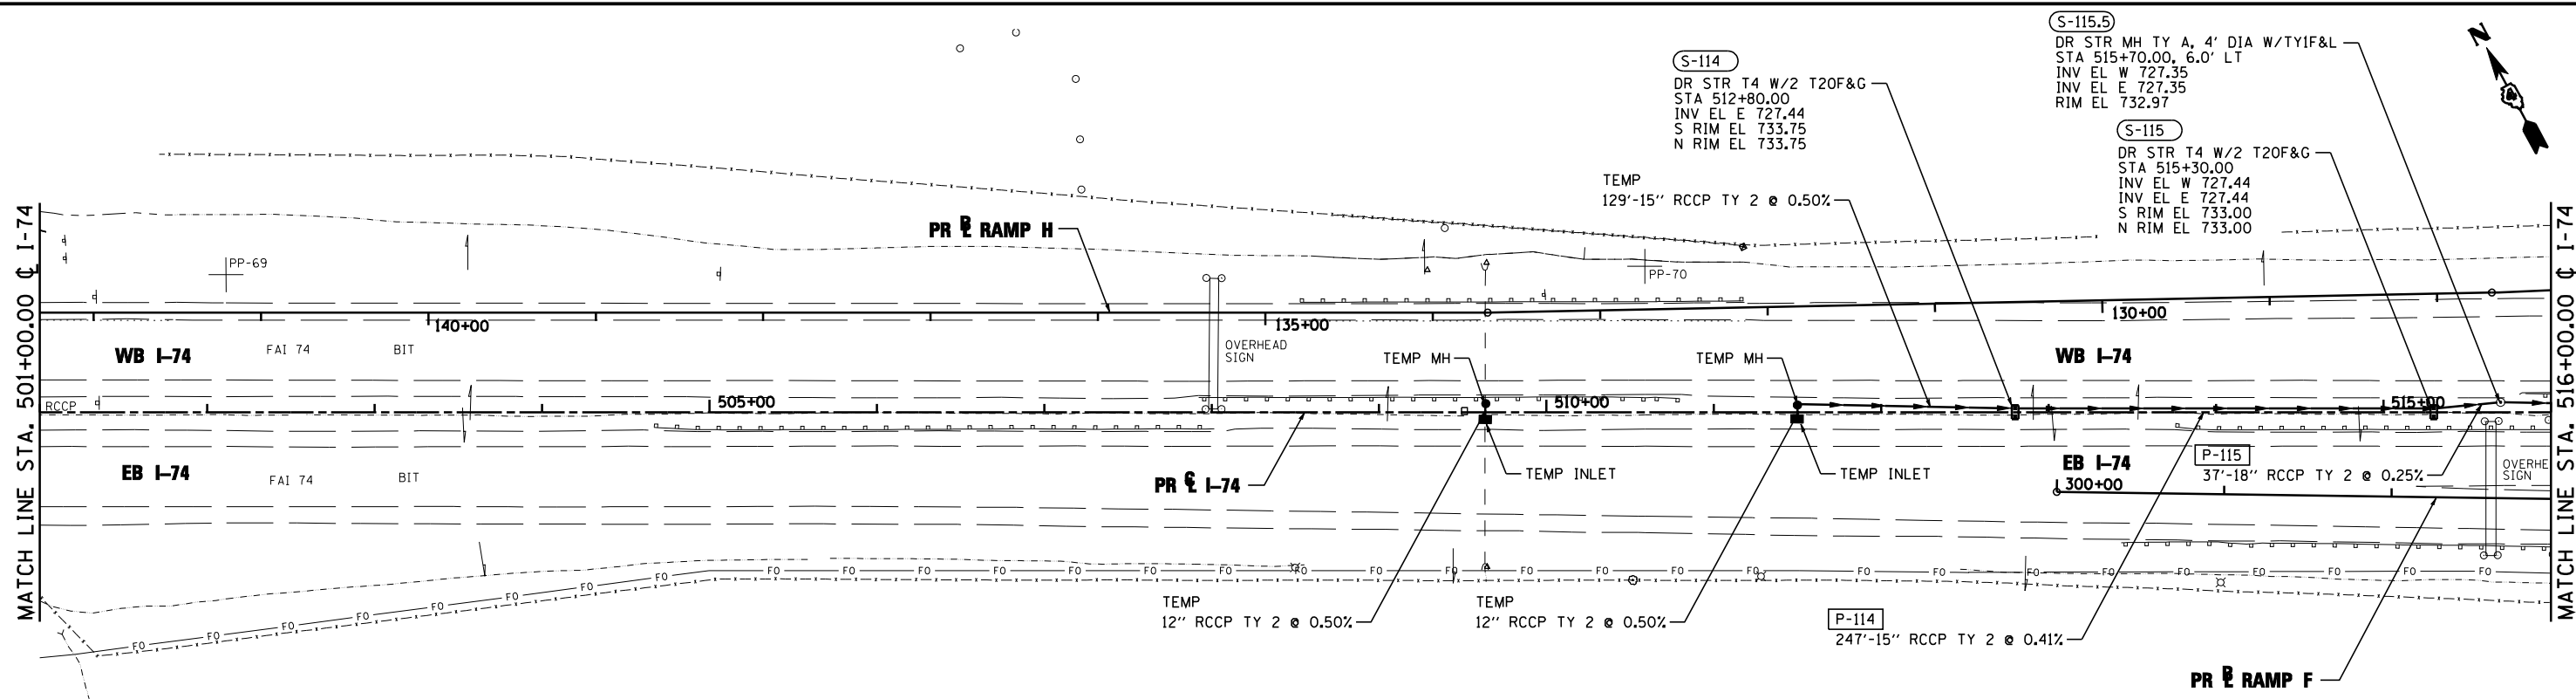

LEGEND:

- A - EXISTING AERIAL LINE
- CTV - EXISTING UNDERGROUND CABLE TV
- E - EXISTING UNDERGROUND ELECTRIC
- FO - EXISTING UNDERGROUND FIBER OPTIC
- G - EXISTING UNDERGROUND GAS LINE
- S - EXISTING UNDERGROUND SANITARY SEWER
- T - EXISTING UNDERGROUND TELEPHONE
- W - EXISTING UNDERGROUND WATER
- → → PROPOSED STORM SEWER
- → → PROPOSED PIPE UNDERDRAIN
- (S-101B) PROPOSED STORM SEWER STRUCTURE CALLOUTS
- (P-101) PROPOSED STORM SEWER PIPE CALLOUTS
- ~ SAG
- ↑ SUMMIT
- - - DITCH
- SWALE
- MANHOLE

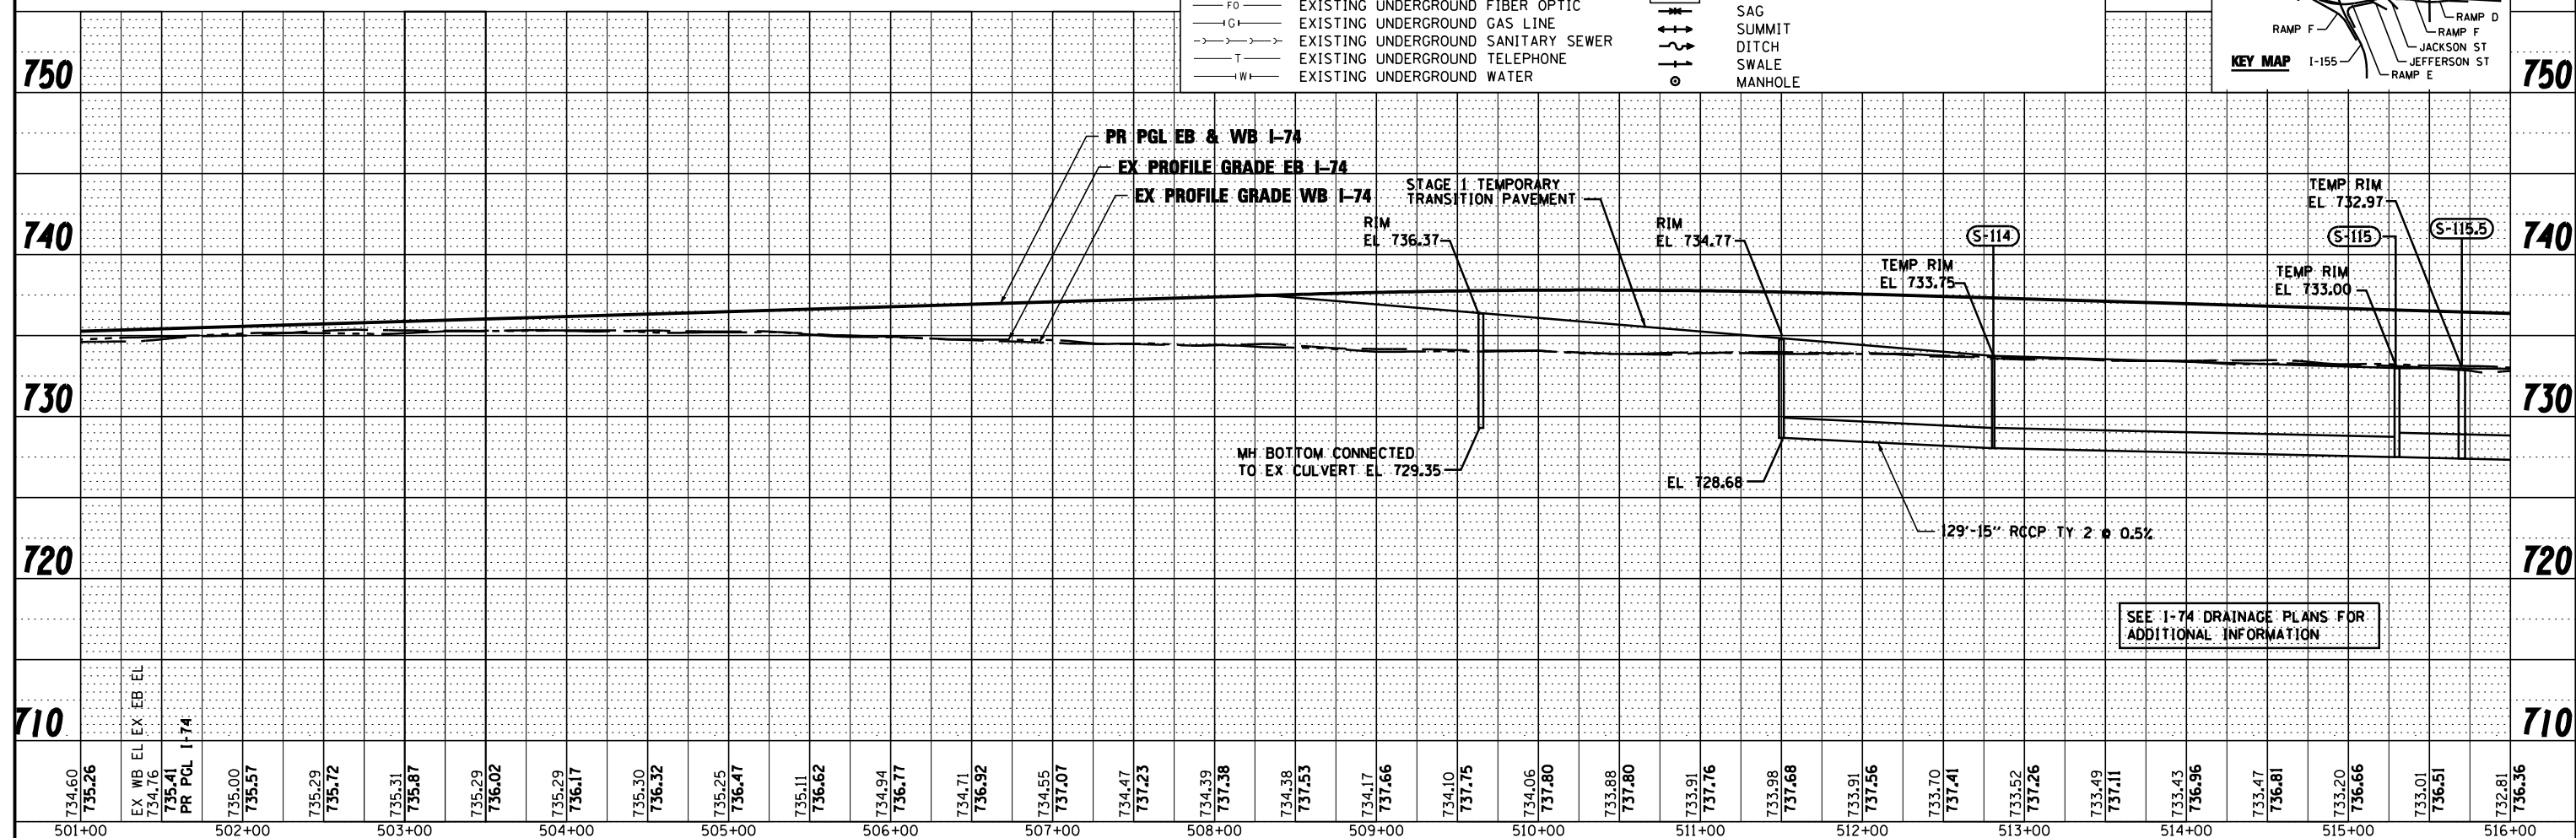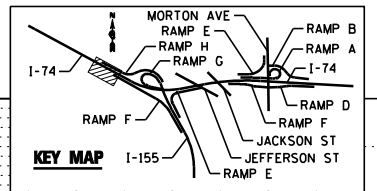

SEE I-74 DRAINAGE PLANS FOR ADDITIONAL INFORMATION

FILE NAME : ...D468620-shr-1-74-TEMP-M0Td-ain16a.dgn	DESIGNED - WLS	REVISED -		STATE OF ILLINOIS DEPARTMENT OF TRANSPORTATION		I-74 TEMPORARY STORM SEWER PLAN STA 501+00 TO STA 516+00		F.A.I. RTE.	SECTION	COUNTY	TOTAL SHEETS	SHEET NO.
USER NAME : jreambillo	DRAWN - I S	REVISED -						90-114R(14HB-4,14,14HB)BR	TAZEWELL	2433	1327	
PLOT DATE : 7/26/2012	CHECKED - JNR	REVISED -						CONTRACT NO. 68620				
DATE - JULY 20, 2012	DATE - JULY 20, 2012	REVISED -						ILLINOIS FED. AID PROJECT				