


DATE	
BY	
PLAN	SURVEYED
	NOTED
	CHECKED
	ATTESTED
	NO. _____
	NO. _____
	NO. _____
	NO. _____
	NO. _____
	NO. _____



DATE	
BY	
PROFILE	SURVEYED
	NOTED
	CHECKED
	ATTESTED
	NO. _____
	NO. _____
	NO. _____
	NO. _____
	NO. _____
	NO. _____

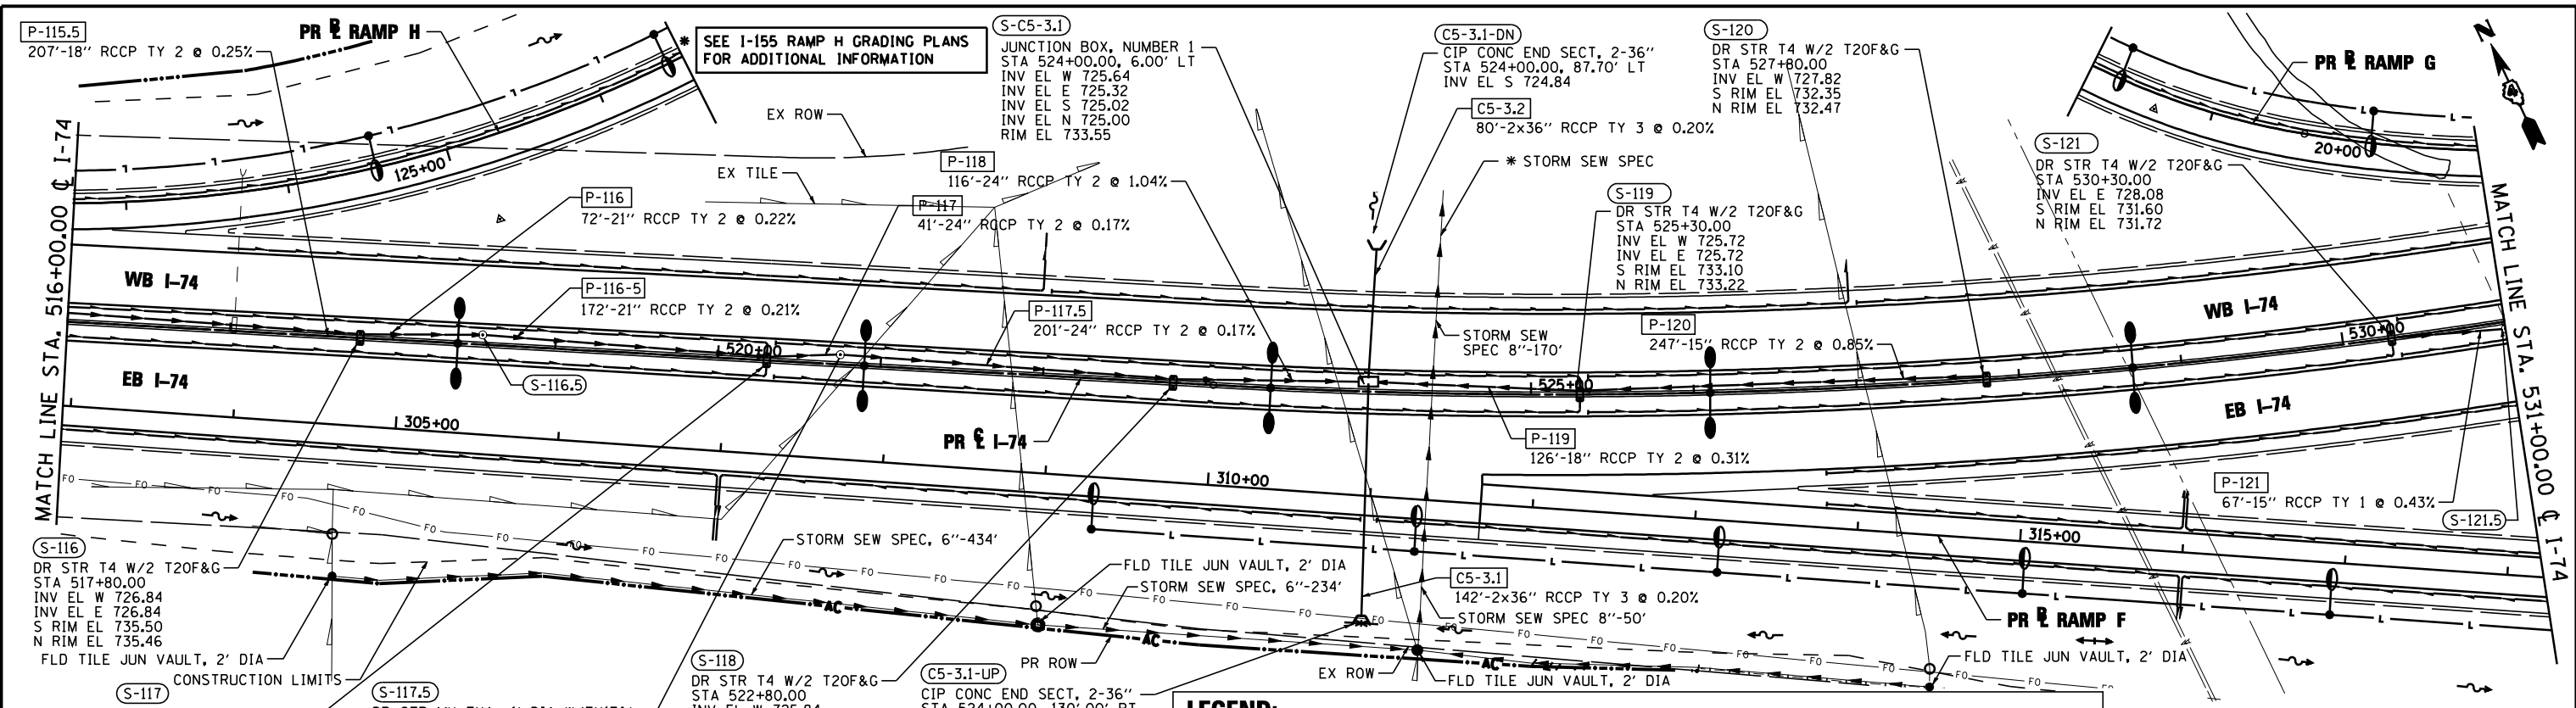

LEGEND:

- A — EXISTING AERIAL LINE
- CTV — EXISTING UNDERGROUND PIPE
- E — EXISTING UNDERGROUND ELECTRIC
- FO — EXISTING UNDERGROUND FIBER OPTIC
- G — EXISTING UNDERGROUND GAS LINE
- S — EXISTING UNDERGROUND SANITARY SEWER
- T — EXISTING UNDERGROUND TELEPHONE
- W — EXISTING UNDERGROUND WATER

- PROPOSED STORM SEWER
- PROPOSED PIPE UNDERDRAIN
- PROPOSED STORM SEWER STRUCTURE CALLOUTS
- PROPOSED STORM SEWER PIPE CALLOUTS
- SAG
- SUMMIT
- DITCH
- SWALE
- MANHOLE

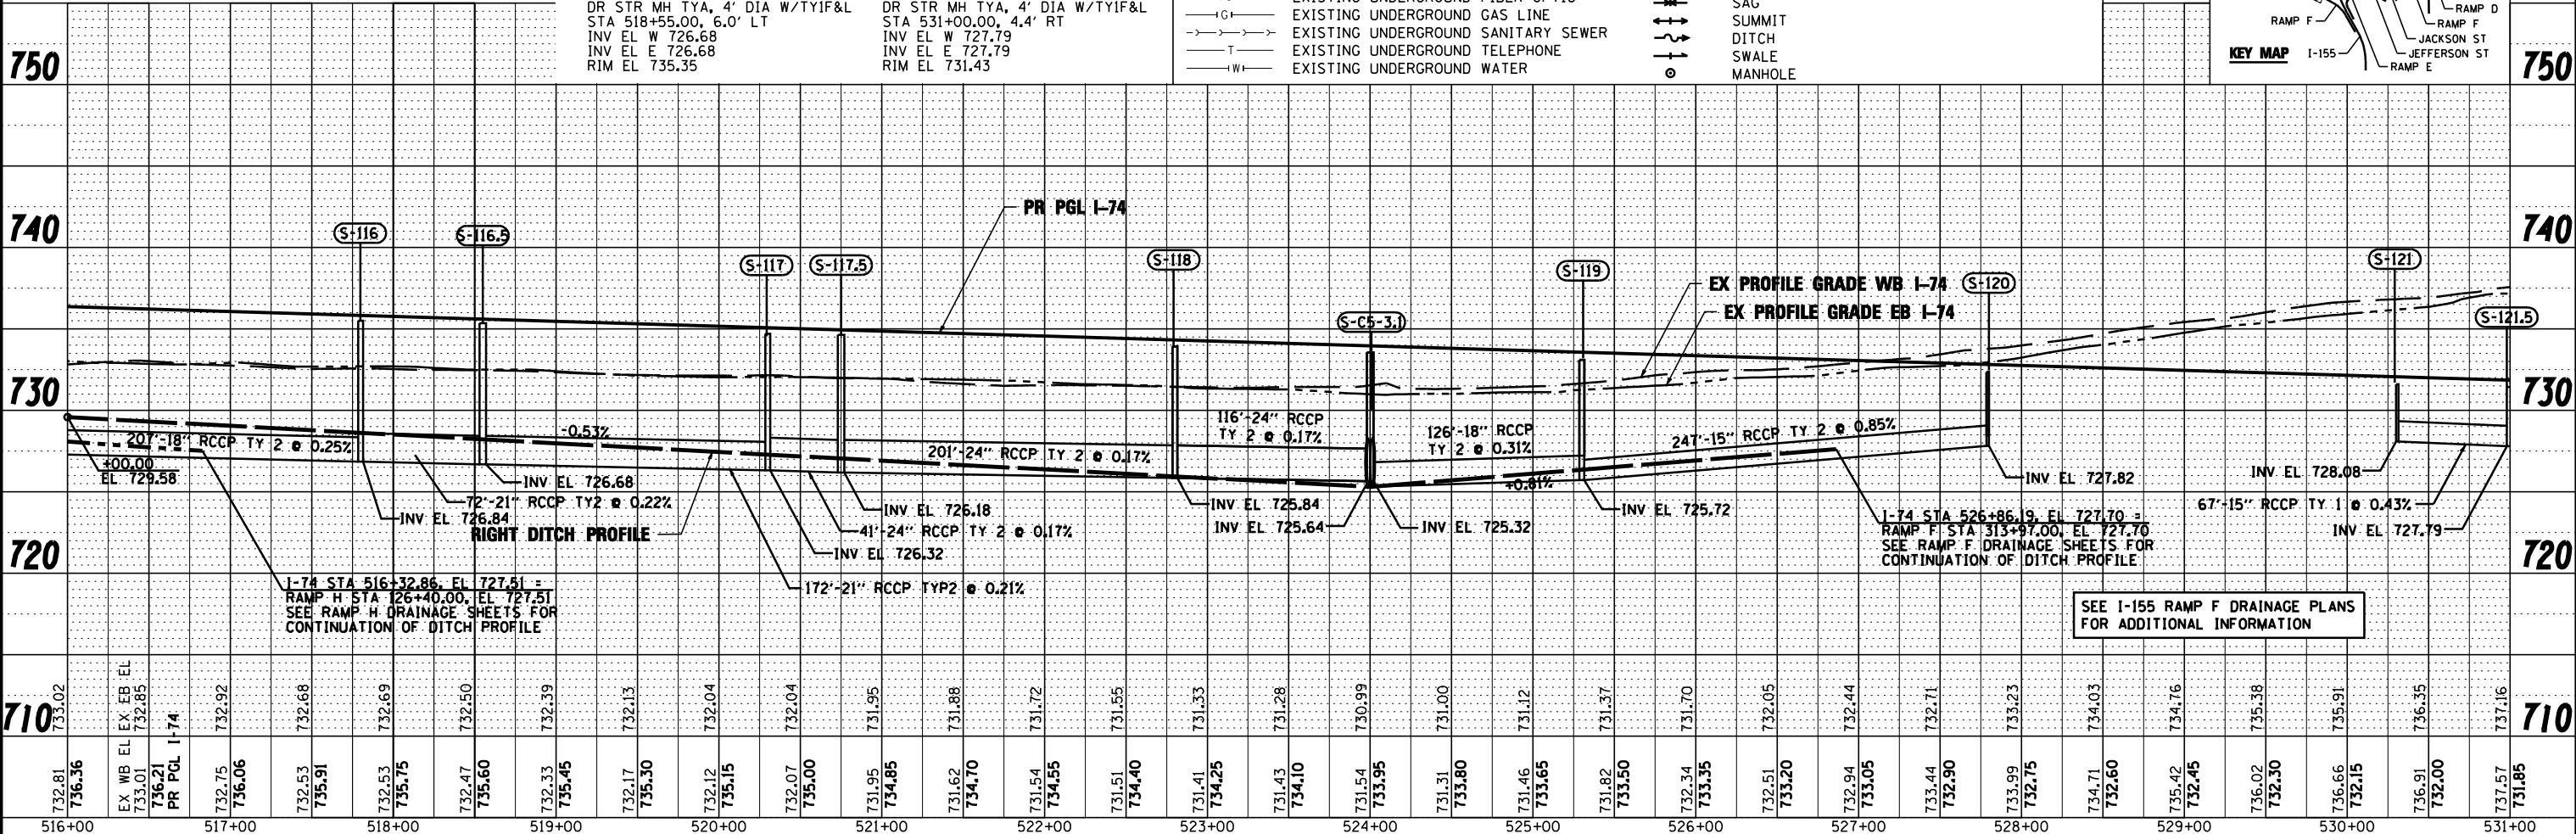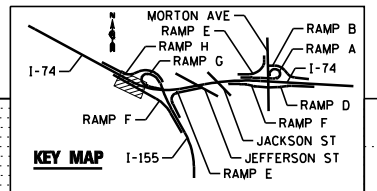

FILE NAME =	DESIGNED - EJA	REVISED -		STATE OF ILLINOIS DEPARTMENT OF TRANSPORTATION DRAINAGE AND UTILITY PLAN AND PROFILE I-74		SECTION COUNTY TAZEWELL CONTRACT NO. 68620 ILLINOIS FED. AID PROJECT
...D468620-sht-1-74-drain05.dgn	DRAWN - TMB	REVISED -				
USER NAME = jreambillo	CHECKED - JNR	REVISED -				
PLOT DATE = 7/26/2012	DATE - JULY 20, 2012	REVISED -	SCALE: 1"=50' SHEET NO. 5 OF 13 SHEETS STA. 516+00.00 TO STA. 531+00.00		TOTAL SHEETS NO. 2433 1418	