


SIGN DETAIL
1:100

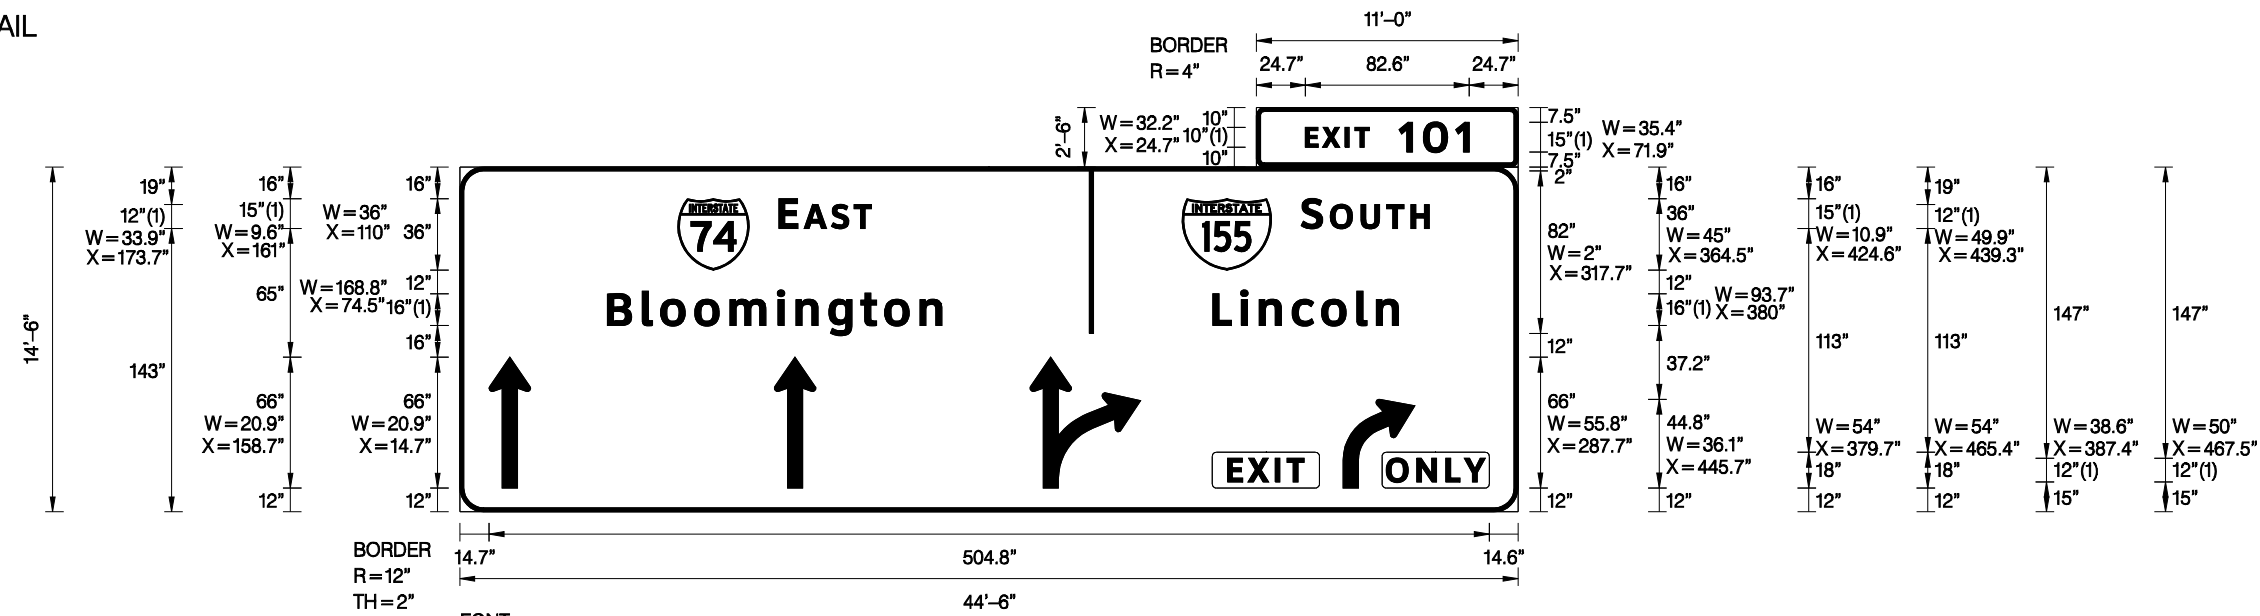

Panel Style: guide_fwy_overhead_arrow-per-lane_clearview.ssi
 Dimensions are in inches.tenths
 FONT: (1) ClearviewHwy-5-W
 M.U.T.C.D.: 2009 Edition

Letter locations are panel edge to lower left corner

SIGN NUMBER	4S0901074R100.6
WIDTH x HGHT.	44'-6" x 14'-6", 11'-0" x 2'-6"
BORDER WIDTH	2"
CORNER RADIUS	12"
MOUNTING	Overhead
BACKGROUND	TYPE: ZZ Retro Reflective COLOR: Color 24
LEGEND/BORDER	TYPE: ZZ Retro Reflective COLOR: Color 100 /Color 240

Color 92/Color 92					
SYMBOL	ROT	X	Y	WID	HT
M1_1	0	110	122	36	36
M1_1	0	364.5	122	45	36
AR_THRU	0	14.7	12	20.9	66
AR_THRU	0	158.7	12	20.9	66
AR_THRU_RIGHT	0	287.7	12	55.8	66
AR_RIGHT_ONLY	0	445.7	12	36.1	44.8

LETTER POSITIONS (X)

												LENGTH	SERIES	SIZE	
E	X	I	T	1	0	1								ClearviewHwy-5-W	
24.7	33.3	44.7	49.7	71.9	84.2	100.5								82.6	10,15
E	A	S	T											ClearviewHwy-5-W	
161	173.7	187.5	199											46.7	15,12
S	O	U	T	H										ClearviewHwy-5-W	
424.6	439.3	454.8	467.7	480										64.6	15,12
B	I	O	O	M	I	N	G	T	O	N				ClearviewHwy-5-W	
74.5	92.1	101.3	118.5	136.3	160.2	169.7	186.2	202.3	214.4	232.2				168.8	16/13
L	I	N	C	O	L	N								ClearviewHwy-5-W	
380	394	403.5	420	434.9	452.7	462.6								93.7	16/13
E	X	I	T											ClearviewHwy-5-W	
387.4	397.7	411.4	417.4											38.6	12
O	N	L	Y											ClearviewHwy-5-W	
467.5	482.9	497.6	506.9											50	12

FILE NAME =	DESIGNED - SMS	REVISED -
...D468620-sh1-signdetail106.dgn	DRAWN - SMS	REVISED -
USER NAME = IDDT	CHECKED - LDC	REVISED -
PLOT DATE = 7/16/2012	DATE - JULY 20, 2012	REVISED -



STATE OF ILLINOIS
DEPARTMENT OF TRANSPORTATION

SIGN PANEL DETAILS

SCALE: SHEET NO. 6 OF 37 SHEETS STA. TO STA.

F.A.I. RTE.	SECTION	COUNTY	TOTAL SHEETS	SHEET NO.
• 90-[14R;14HB-4,14,14HV]BR]	TAZEWELL	ILLINOIS	2433	1589
CONTRACT NO. 68620				ILLINOIS FED. AID PROJECT