


| | | | | |
|---------------------|-------------|---------------------------|--------------|-----------|
| F.A.T. RTE. | SECTION | COUNTY | TOTAL SHEETS | SHEET NO. |
| 55 | 2006-031 BY | WILL | 137 | 50 |
| STA. TO STA. | | ILLINOIS FED. AID PROJECT | | |
| FED. ROAD DIST. NO. | | | | |

MATCH LINE 157+00.00

MATCH LINE 172+00.00

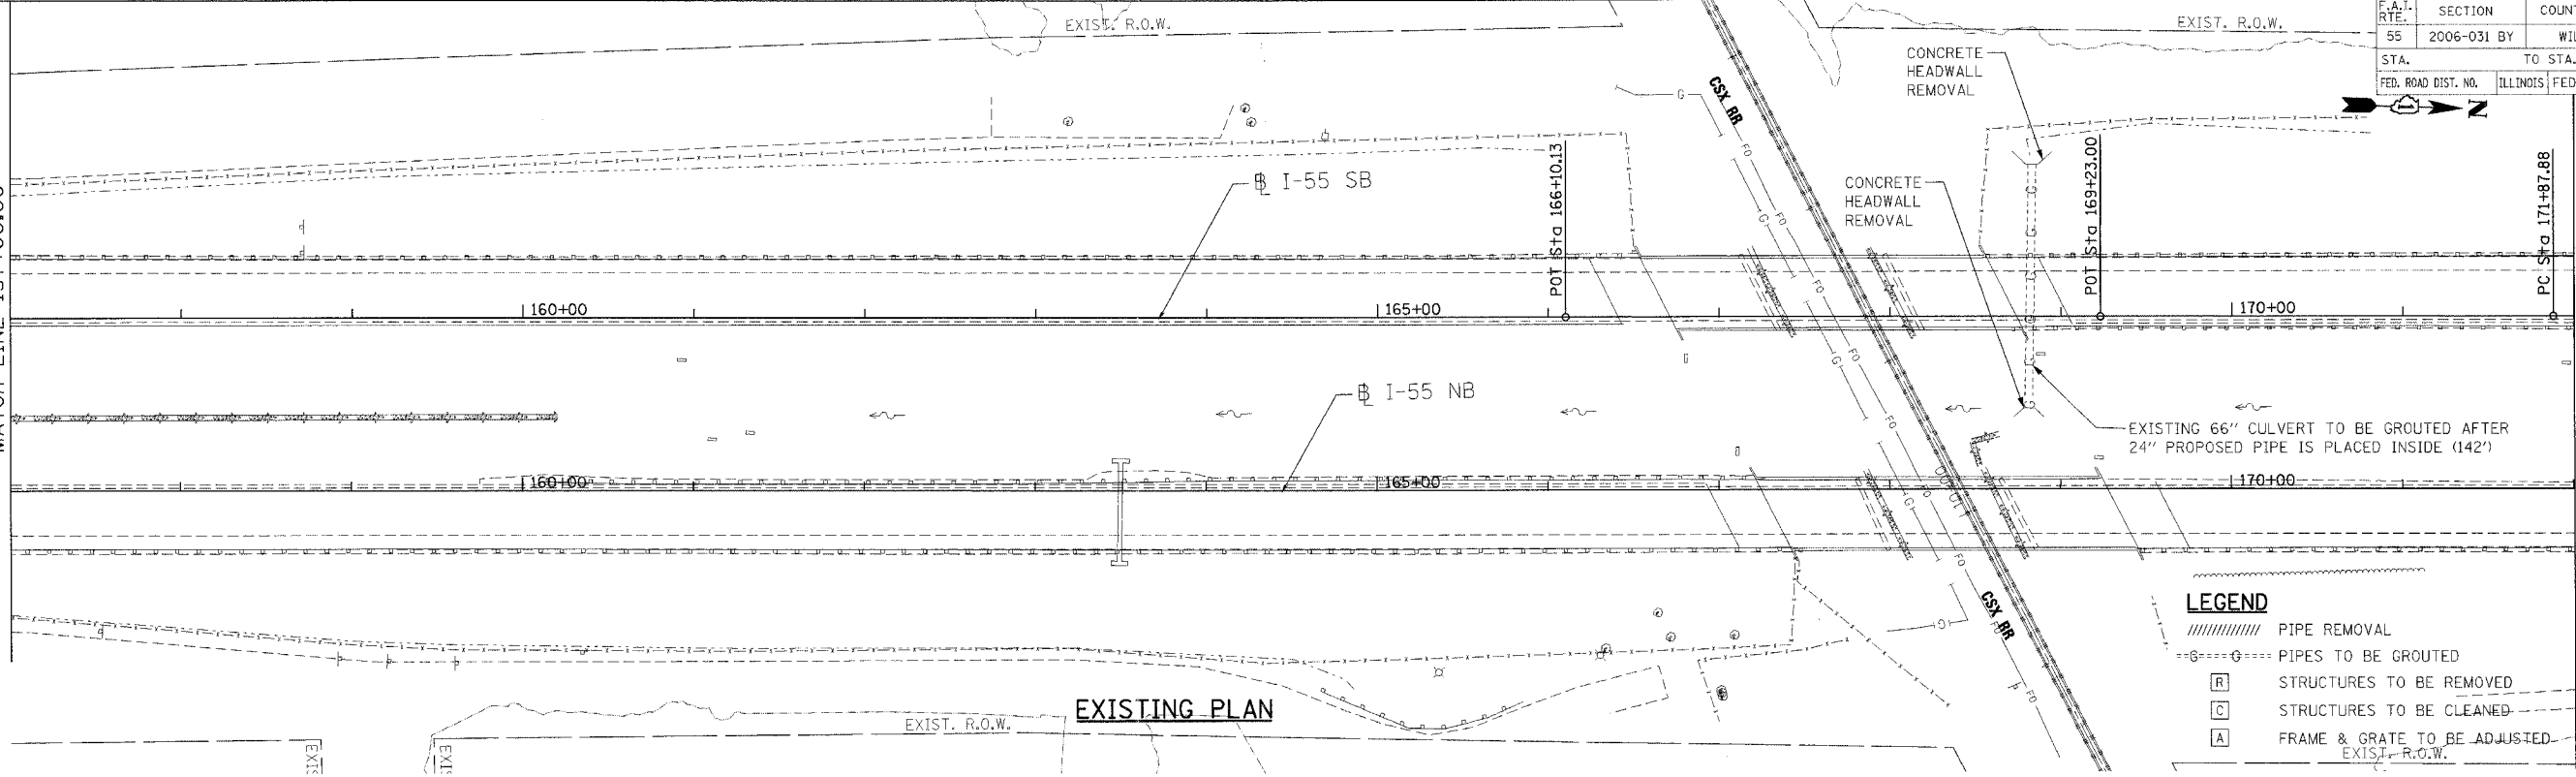


LEGEND

- ////// PIPE REMOVAL
- G---G--- PIPES TO BE GROUTED
- [R] STRUCTURES TO BE REMOVED
- [C] STRUCTURES TO BE CLEANED
- [A] FRAME & GRATE TO BE ADJUSTED-EXIST. R.O.W.

EXISTING PLAN

MATCH LINE 157+00.00

MATCH LINE 172+00.00

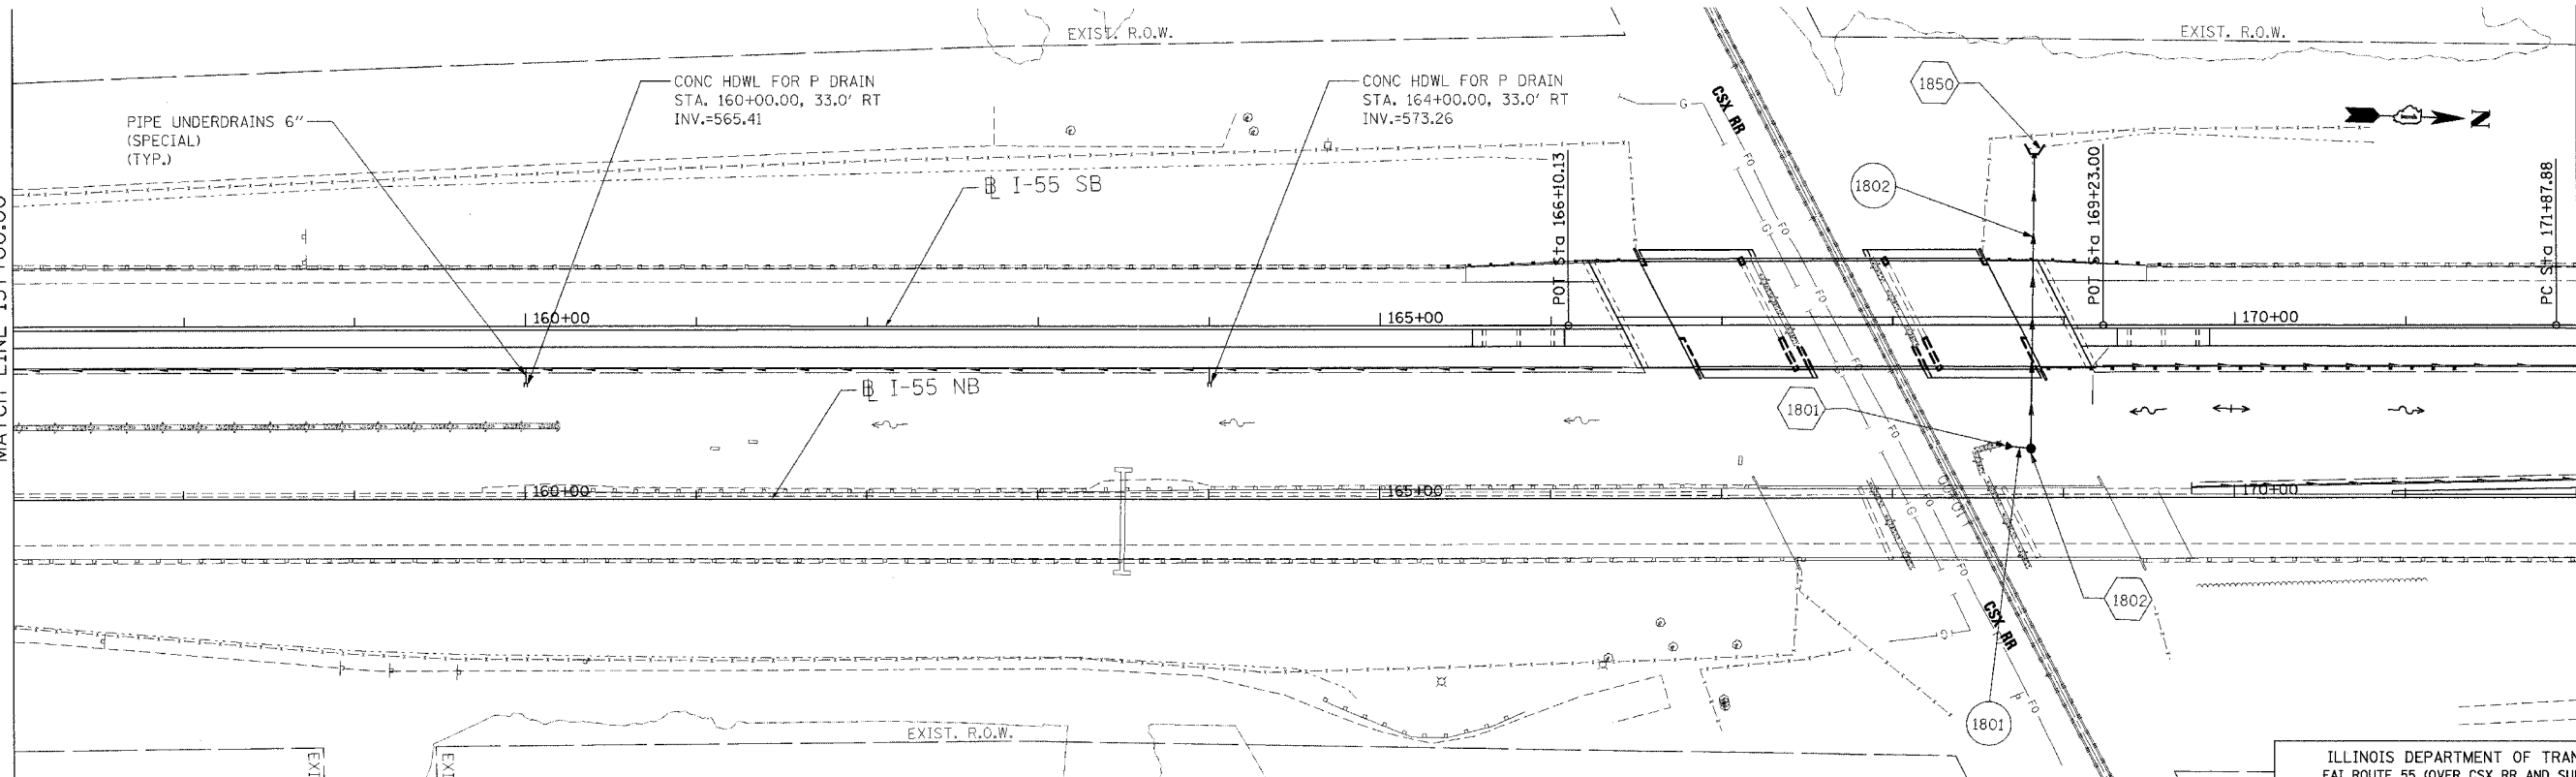

LEGEND

- (1001) STRUCTURE NUMBER
- (1001) GRATING FOR STRUCTURE
- (1001) PIPE NUMBER
- STORM SEWER
- ~ PROPOSED DITCH
- CATCH BASIN
- MANHOLE
- ▲ FLARED END SECTION
- ▴ HEADWALL
- ▬ PIPE UNDERDRAINS
- HEADWALL FOR PIPE UNDERDRAIN

NOTES

1. FOR STRUCTURE AND PIPE INFORMATION, SEE DRAINAGE SCHEDULES, SHEETS 53, 54.

2. FOR GRADING AROUND CSX BRIDGE, SEE SHEET 61.

PROPOSED PLAN

REVISIONS

| NAME | DATE |
|------|------|
| | |
| | |
ILLINOIS DEPARTMENT OF TRANSPORTATION
 FAI ROUTE 55 (OVER CSX RR AND SUNNYLAND DRAIN)
 BRIDGE WIDENING

DRAINAGE AND UTILITY PLAN
FAI 55
STA. 157+00.00 TO STA. 172+00.00

SCALE: 1"=50' DRAWN BY: MRK
 DATE: 07/21/06 CHECKED BY: TKL

TENG TENG & ASSOCIATES, INC.
 ENGINEERS/ARCHITECTS/PLANNERS
 CHICAGO, ILLINOIS

PLOT DATE = 07/21/06 PLOT SCALE = 1"=50' USER NAME = tk1
 FILE NAME = 072106.DWG PLOT SCALE = 1"=50' USER NAME = tk1
 PLOT SCALE = 1"=50' USER NAME = tk1
 7-28-2006 15:44:40 PAPER NAME = 072106.DWG