


F.A.I.	SECTION	COUNTY	TOTAL SHEETS	SHEET NO.
94/90		COOK	565	305
STA. 1572+00		TO STA. 1584+00		
FED. ROAD DIST. NO.	ILLINOIS	FED. AID PROJECT		
62301 • (2021-922 PT2 ETC 2324.6-1P) R-10				

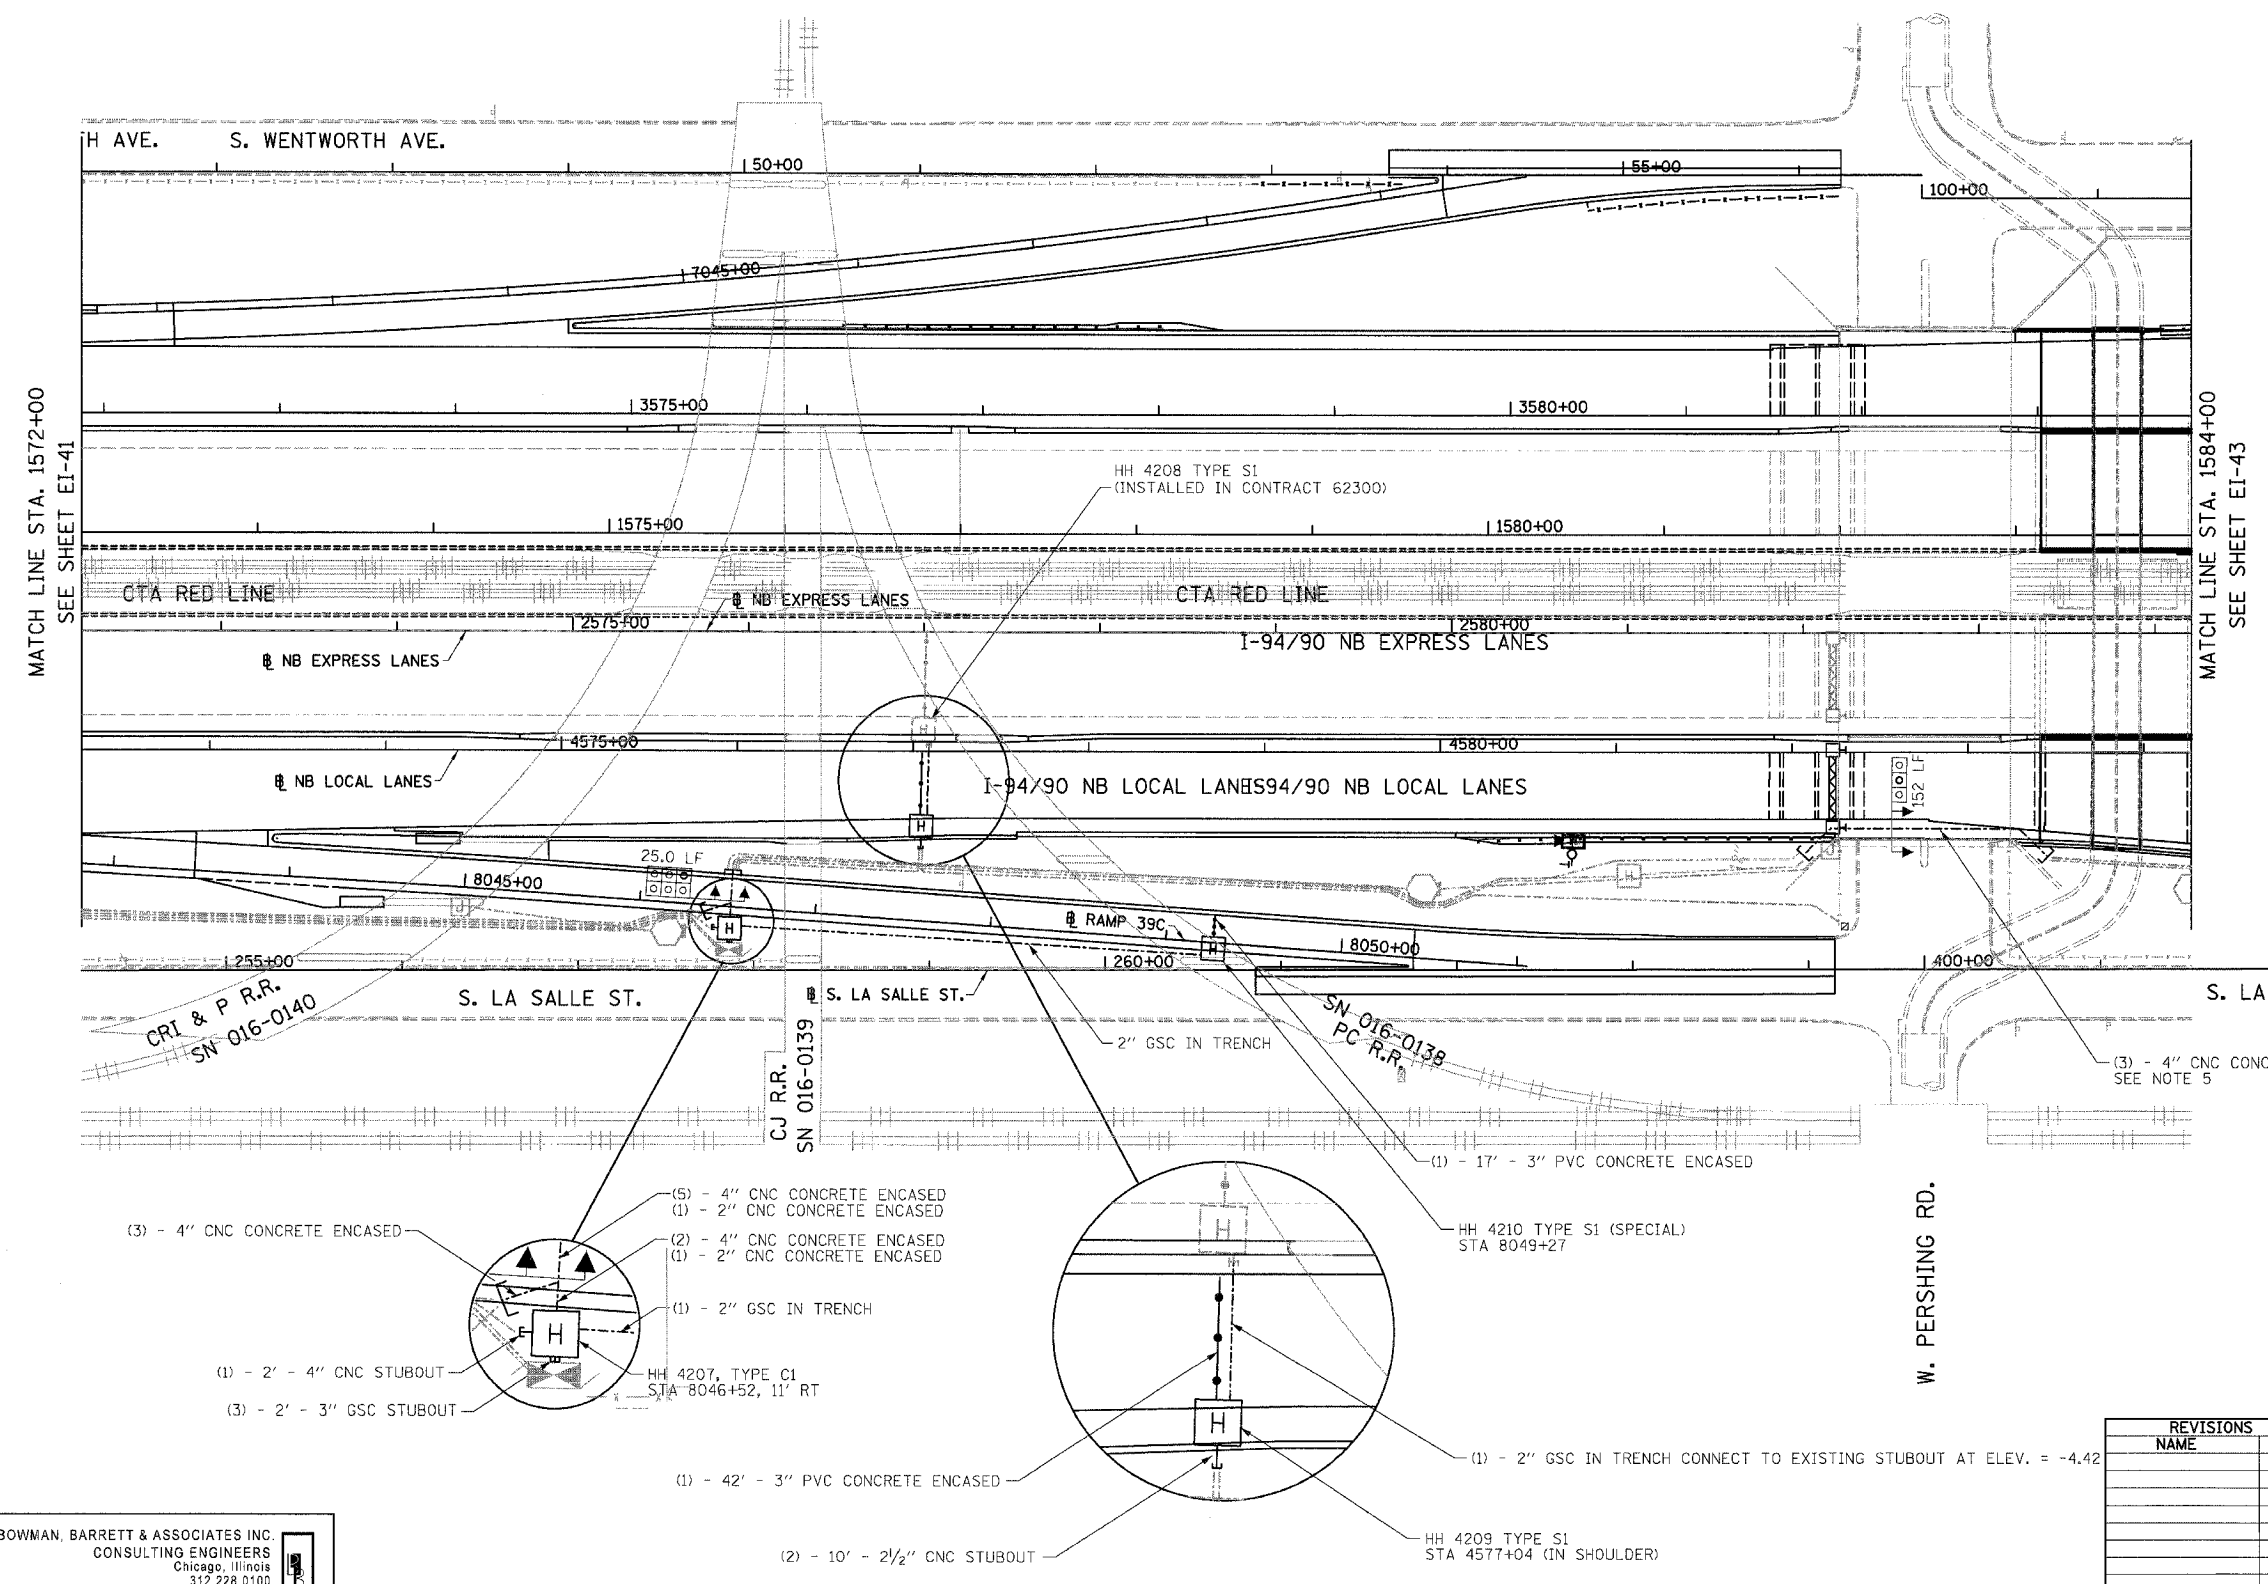

- NOTES:**
- SEE DRAWINGS EI-100 AND EI-101 FOR ELECTRICAL SYMBOLS AND ABBREVIATIONS.
 - SEE DRAWINGS EI-102, EI-103, AND EI-104 FOR TYPICAL HANDHOLE INSTALLATION DETAILS
 - TRENCHED CONDUITS INSTALLED IN PARALLEL ARE TO BE INSTALLED IN COMMON TRENCH.
 - THIS CONTRACT IS RESPONSIBLE FOR PROPOSED ITEMS THAT ARE LABELED. UNLABELLED ITEMS ARE THE RESPONSIBILITY OF CONTRACT 62583. ALL WORK MUST BE COORDINATED BY BOTH CONTRACTS.
 - ELECTRICAL DUCTBANKS AROUND BRIDGE ABUTMENTS MUST CLEAR ALL PROPOSED DRAINAGE STRUCTURES. SEE DRAINAGE PLANS FOR DETAILS.

MATCH LINE STA. 1572+00
SEE SHEET EI-41

 
MATCH LINE STA. 1584+00
SEE SHEET EI-43

- (3) - 4" CNC CONCRETE ENCASED
- (1) - 2" CNC CONCRETE ENCASED
- (2) - 4" CNC CONCRETE ENCASED
- (1) - 2" CNC CONCRETE ENCASED
- (1) - 2" GSC IN TRENCH
- HH 4207, TYPE C1
STA 8046+52, 11' RT
- (1) - 2' - 4" CNC STUBOUT
- (3) - 2' - 3" GSC STUBOUT

- (1) - 42' - 3" PVC CONCRETE ENCASED
- (2) - 10' - 2 1/2" CNC STUBOUT

HH 4210 TYPE S1 (SPECIAL)
STA 8049+27

HH 4209 TYPE S1
STA 4577+04 (IN SHOULDER)



EI-42

BOWMAN, BARRETT & ASSOCIATES INC.
CONSULTING ENGINEERS
Chicago, Illinois
312.228.0100
www.bbainc.com

REVISIONS	
NAME	DATE

ILLINOIS DEPARTMENT OF TRANSPORTATION
F.A.I. 94/90 (DAN RYAN EXPRESSWAY)
59TH STREET TO 31ST STREET (NB LOCAL LANES)
ELECTRICAL INFRASTRUCTURE PLANS

SCALE: 1"=50'
DATE: 06/09/06

DRAWN BY: JDC
CHECKED BY: RS

12/25/05 PM
6/7/2006