


F.A.I. RT.:	SECTION	COUNTY	TOTAL SHEETS	SHEET NO.
94/90	*	COOK	565	328
STA.	TO STA.			
FED. ROAD DIST. NO. 1 ILLINOIS		FED. AID PROJECT		

62301 *1818, ETC. 2324.6-1PIR-10

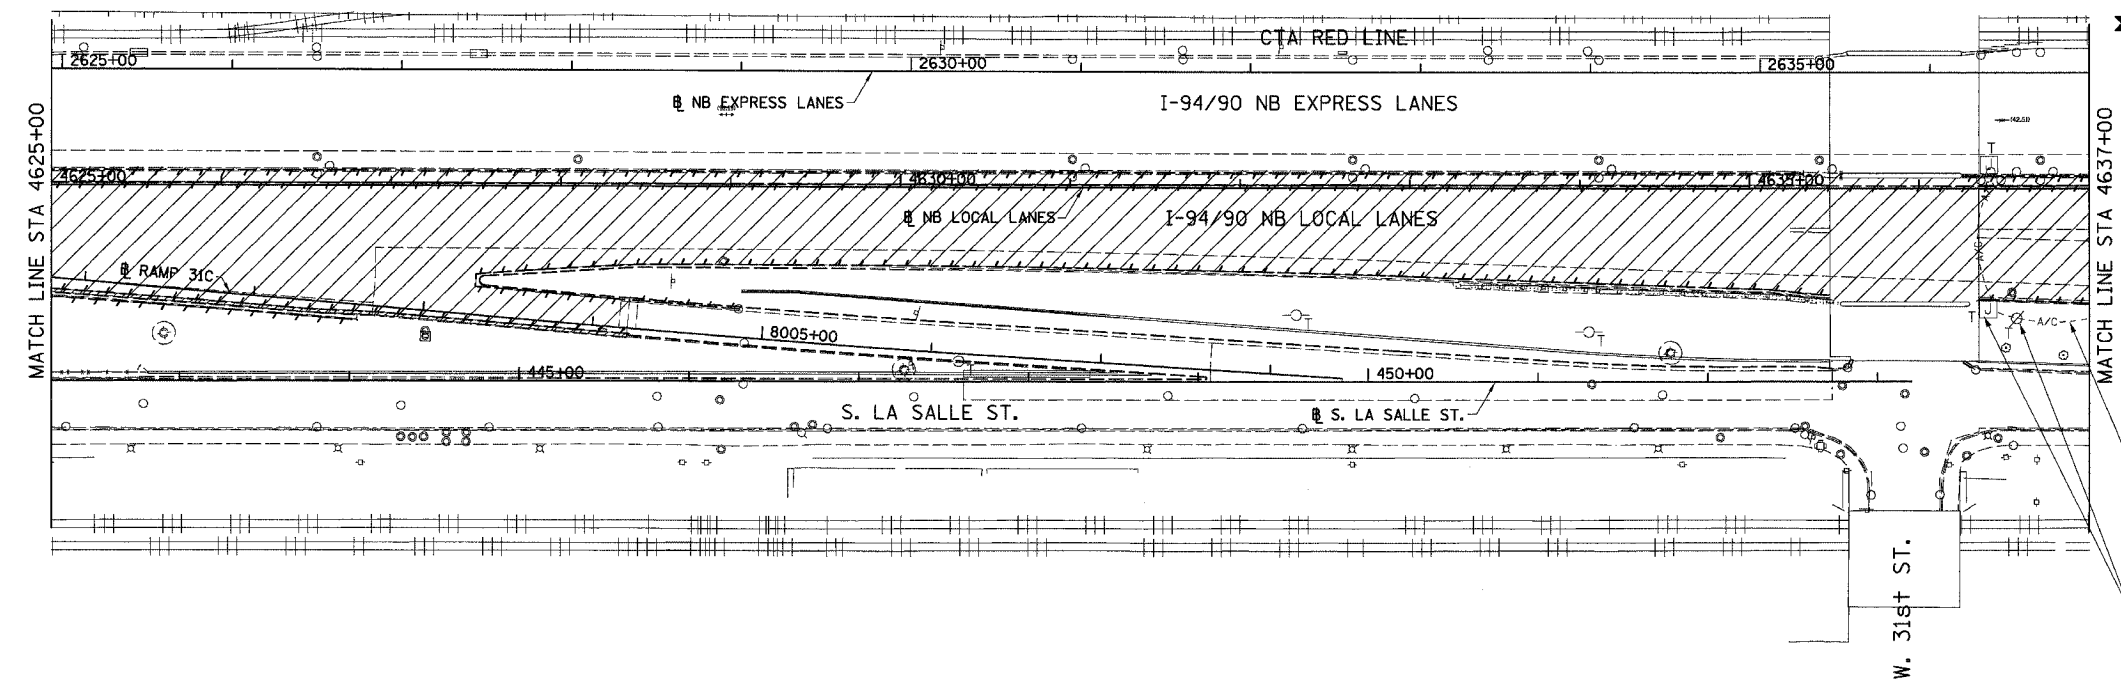


- NOTES:**
1. TEMPORARY AERIAL CABLE, JUNCTION BOXES AND WOOD POLES SHALL BE REMOVED WHEN PROPOSED MEDIAN LIGHTING IS INSTALLED AND OPERATIONAL.
 2. REMOVAL OF JUNCTION BOXES SHALL BE INCLUDED IN COST OF AERIAL CABLE REMOVAL.
 3. EQUIPMENT TO BE REMOVED SHALL BE CONFIRMED BASED ON EQUIPMENT ACTUALLY INSTALLED CONTRACT 62580.

CKT. E&F: AERIAL CABLE INSTALLED CONTRACT 62580


TEMPORARY JUNCTION BOX AND WOOD POLE INSTALLED CONTRACT 62580

**EXISTING CONDITIONS AND REMOVAL
PROPOSED IMPROVEMENTS**

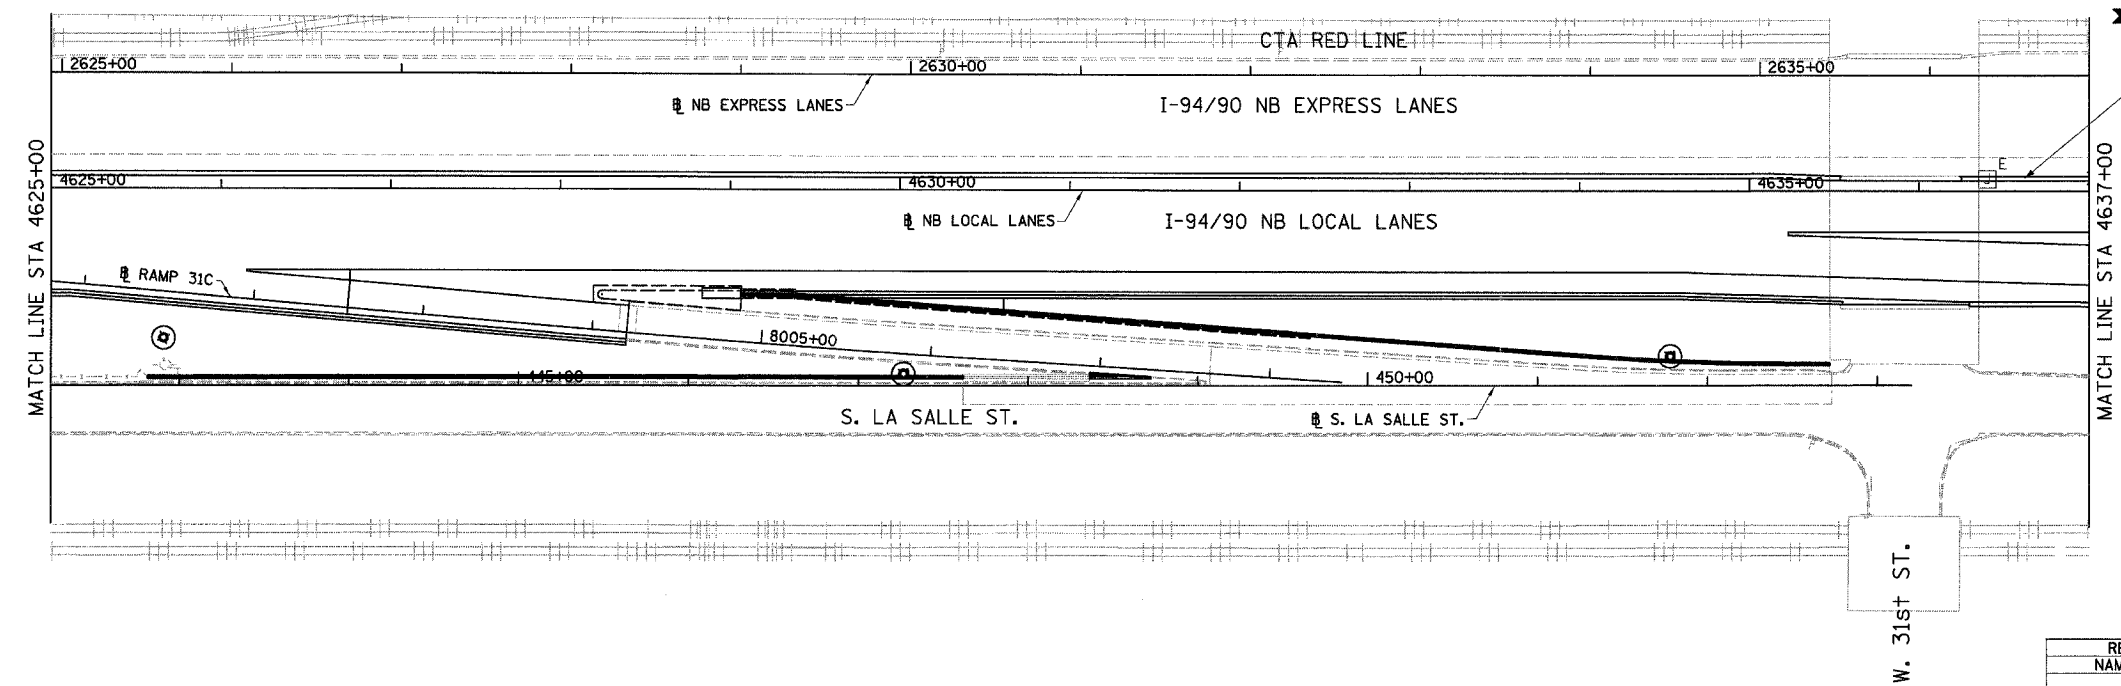

CKT. E&F: 3*2, 1*4 GND 1/4" UD PULLED IN EMBEDDED 4" CONDUIT (TYP)

 - NOTES:**
1. PROPOSED CIRCUIT SHALL CONTINUE TO THE EXISTING JUNCTION BOX ATTACHED TO STRUCTURE.



EL-01

REVISIONS	
NAME	DATE

ILLINOIS DEPARTMENT OF TRANSPORTATION
F.A.I. 94/90 (DAN RYAN EXPRESSWAY)
 GARFIELD BLVD TO 31ST STREET (NB LOCAL LANES)
 EXISTING AND PROPOSED LIGHTING PLANS

SCALE: 1"=50'
 DATE: 06/09/06

DRAWN BY: BL
 CHECKED BY: SM

KET KAM ENGINEERING, INC.
 CONSULTING ENGINEERS
 707A Davile Road, Suite 205
 Elgin, Illinois 60123-1369

6/7/2006 10:25:37 PM