


F.A.I. RTE.	SECTION	COUNTY	TOTAL SHEETS	SHEET NO.
94/90		COOK	588	255
STA.		TO STA.		
FED. ROAD DIST. NO.		ILLINOIS FED. AID PROJECT		
62303		*(2021-922 PT2 ETC 2324.6-IP1R-11		

**SIGN DETAIL**  
1:100

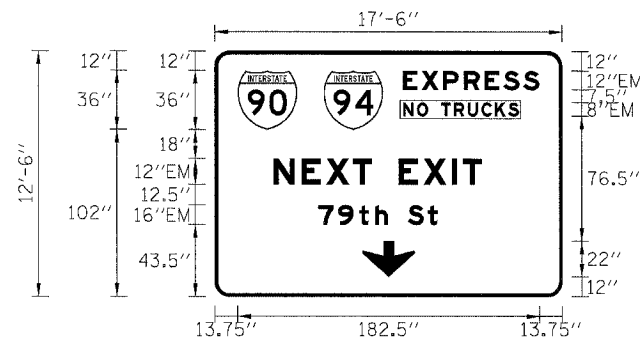

SIGN NUMBER	IS016I094R056.67 LT
WIDTH x HGHT.	17'-6" x 12'-6"
BORDER WIDTH	2"
CORNER RADIUS	9"
MOUNTING	Overhead
BACKGROUND	TYPE: Reflective COLOR: Green
LEGEND/BORDER	TYPE: Reflective COLOR: White


SYMBOL	X	Y	WID	HT
M1_1	13.7	102	36	36
M1_1	65.7	102	36	36
ARDOWN	89	12	32	22

Panel Style:guide\_exp\_advance\_b.ssi  
Dimensions are in inches,tenths

Letter locations are panel edge to lower left corner

LETTER POSITIONS (X)													LENGTH	SERIESSIZE
E	X	P	R	E	S	S							EM12	82.5
113.7	125	137.8	150.5	163.1	174.4	186.5							EM8	70.2
N	O		T	R	U	C	K	S					EM12	126
113.8	122.2	128.8	136.8	144.4	152.8	161.2	169.3	177.4					EM16/12	72.4
N	E	X	T		E	X	I	T						
35.4	52.3	67.4	83.4	95.1	111.1	126.1	143.2	149.7						
7	9	t	h		S	t								
62.3	74.3	87	96.8	104.5	116.5	128.6								

**SIGN DETAIL**  
1:100

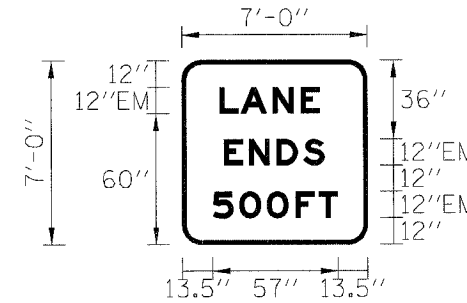

SIGN NUMBER	IS016I094R056.47CN
WIDTH x HGHT.	7'-0" x 7'-0"
BORDER WIDTH	2"
CORNER RADIUS	9"
MOUNTING	Overhead
BACKGROUND	TYPE: Reflective COLOR: Green
LEGEND/BORDER	TYPE: Reflective COLOR: White


SYMBOL	X	Y	WID	HT

Panel Style:guide\_exp\_advance\_b.ssi  
Dimensions are in inches,tenths

Letter locations are panel edge to lower left corner

LETTER POSITIONS (X)													LENGTH	SERIESSIZE
L	A	N	E										EM12	45.6
17	26.6	41.1	53.7										EM12	45.8
E	N	D	S										EM12	56.8
18.9	30.2	42.8	54.8											
5	0	0	F	T										
13.7	25.8	38.2	51.3	61.7										

**SIGN DETAIL**  
1:100

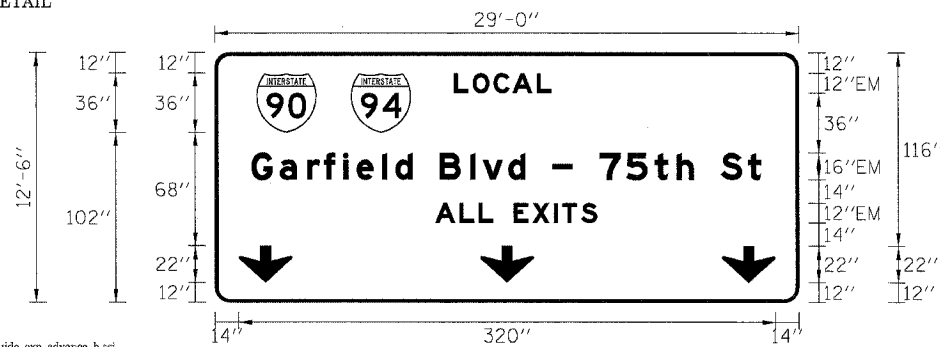

SIGN NUMBER	IS016I094R056.67 RT
WIDTH x HGHT.	29'-0" x 12'-6"
BORDER WIDTH	2"
CORNER RADIUS	9"
MOUNTING	Overhead
BACKGROUND	TYPE: Reflective COLOR: Green
LEGEND/BORDER	TYPE: Reflective COLOR: White


SYMBOL	X	Y	WID	HT
M1_1	24.6	102	36	36
M1_1	81	102	36	36
ARDOWN	14	12	32	22
ARDOWN	168	12	32	22
ARDOWN	302	12	32	22

Panel Style:guide\_exp\_advance\_b.ssi  
Dimensions are in inches,tenths

Letter locations are panel edge to lower left corner

LETTER POSITIONS (X)													LENGTH	SERIESSIZE
L	O	C	A	L									EM12	58.2
142.4	153.6	166.1	177.3	191.8									EM16/12	308.9
G	a	r	f	i	e	l	B	l	v	d	-	7	EM12	96.6
21.5	38.6	54.9	64.9	76.3	84.3	90.6	117.7	133.7	152.2	159.7	174.7	185		
A	L	L	E	X	I	T	S							
131.2	145.7	167	166.8	177.8	189.1	201.9	206.3	218						

**SIGN DETAIL**  
1:100

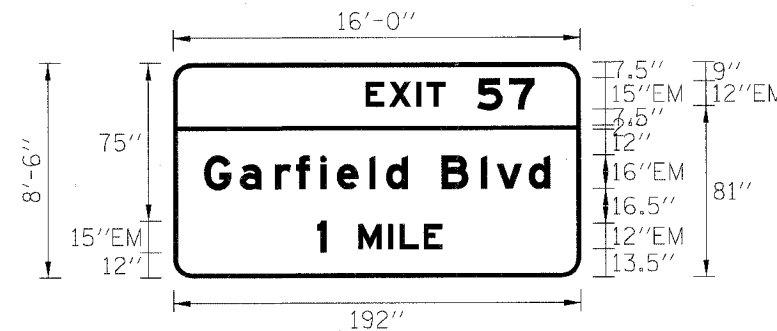

SIGN NUMBER	IS016I094R056.47 CN
WIDTH x HGHT.	16'-0" x 8'-6"
BORDER WIDTH	2"
CORNER RADIUS	9"
MOUNTING	Overhead
BACKGROUND	TYPE: Reflective COLOR: Green
LEGEND/BORDER	TYPE: Reflective COLOR: White

SYMBOL	X	Y	WID	HT

Panel Style:guide\_exp\_advance\_b.ssi  
Dimensions are in inches,tenths

Letter locations are panel edge to lower left corner

LETTER POSITIONS (X)													LENGTH	SERIESSIZE
E	X	I	T	5	7								EM12,EM15	79.8
90.6	101.9	114.7	119.6	143.3	158.4								EM16/12	163.4
G	a	r	f	i	e	l	B	l	v	d			EM15,EM12	59.1
14.3	31.3	47.6	57.7	69	77.1	92.3	100.2	110.5	126.5	144.9	152.4	167.5		
1	M	I	L	E										
67.7	87.1	101.2	106.7	118										

REVISIONS	
NAME	DATE
ADDENDUM 2	8/04/06

ILLINOIS DEPARTMENT OF TRANSPORTATION  
F.A.I. 90/94 (DAN RYAN EXPRESSWAY)  
GARFIELD BLVD TO 31ST STREET (SB LOCAL LANES)  
SIGN PANEL DETAILS

SCALE: 1"=50'  
DATE: 06/09/06  
DRAWN BY: RV  
CHECKED BY: AS