


| | | | | |
|--------------------------|---------------|---|--------------|-----------|
| F.A.I. RTE. | SECTION | COUNTY | TOTAL SHEETS | SHEET NO. |
| 290 | 0305-302K-L-3 | COOK | 55 | 21 |
| STA. _____ TO STA. _____ | | FED. ROAD DIST. NO. 1 ILLINOIS FED. AID PROJECT | | |

LEGEND

| | | | |
|--|---|-------|-------------------------|
| | EXISTING LIGHTING UNIT | | UNIT DUCT |
| | REINSTALLED EXISTING LIGHTING UNIT | | GROUND ROD |
| | EXISTING LIGHTING CONTROLLER SINGLE TYPE EXISTING | XA12 | PROPOSED LIGHTING DECAL |
| | LIGHTING CONTROLLER, DUPLEX TYPE PROPOSED | OXA12 | EXISTING LIGHTING DECAL |
| | CONDUIT PUSHED | | |

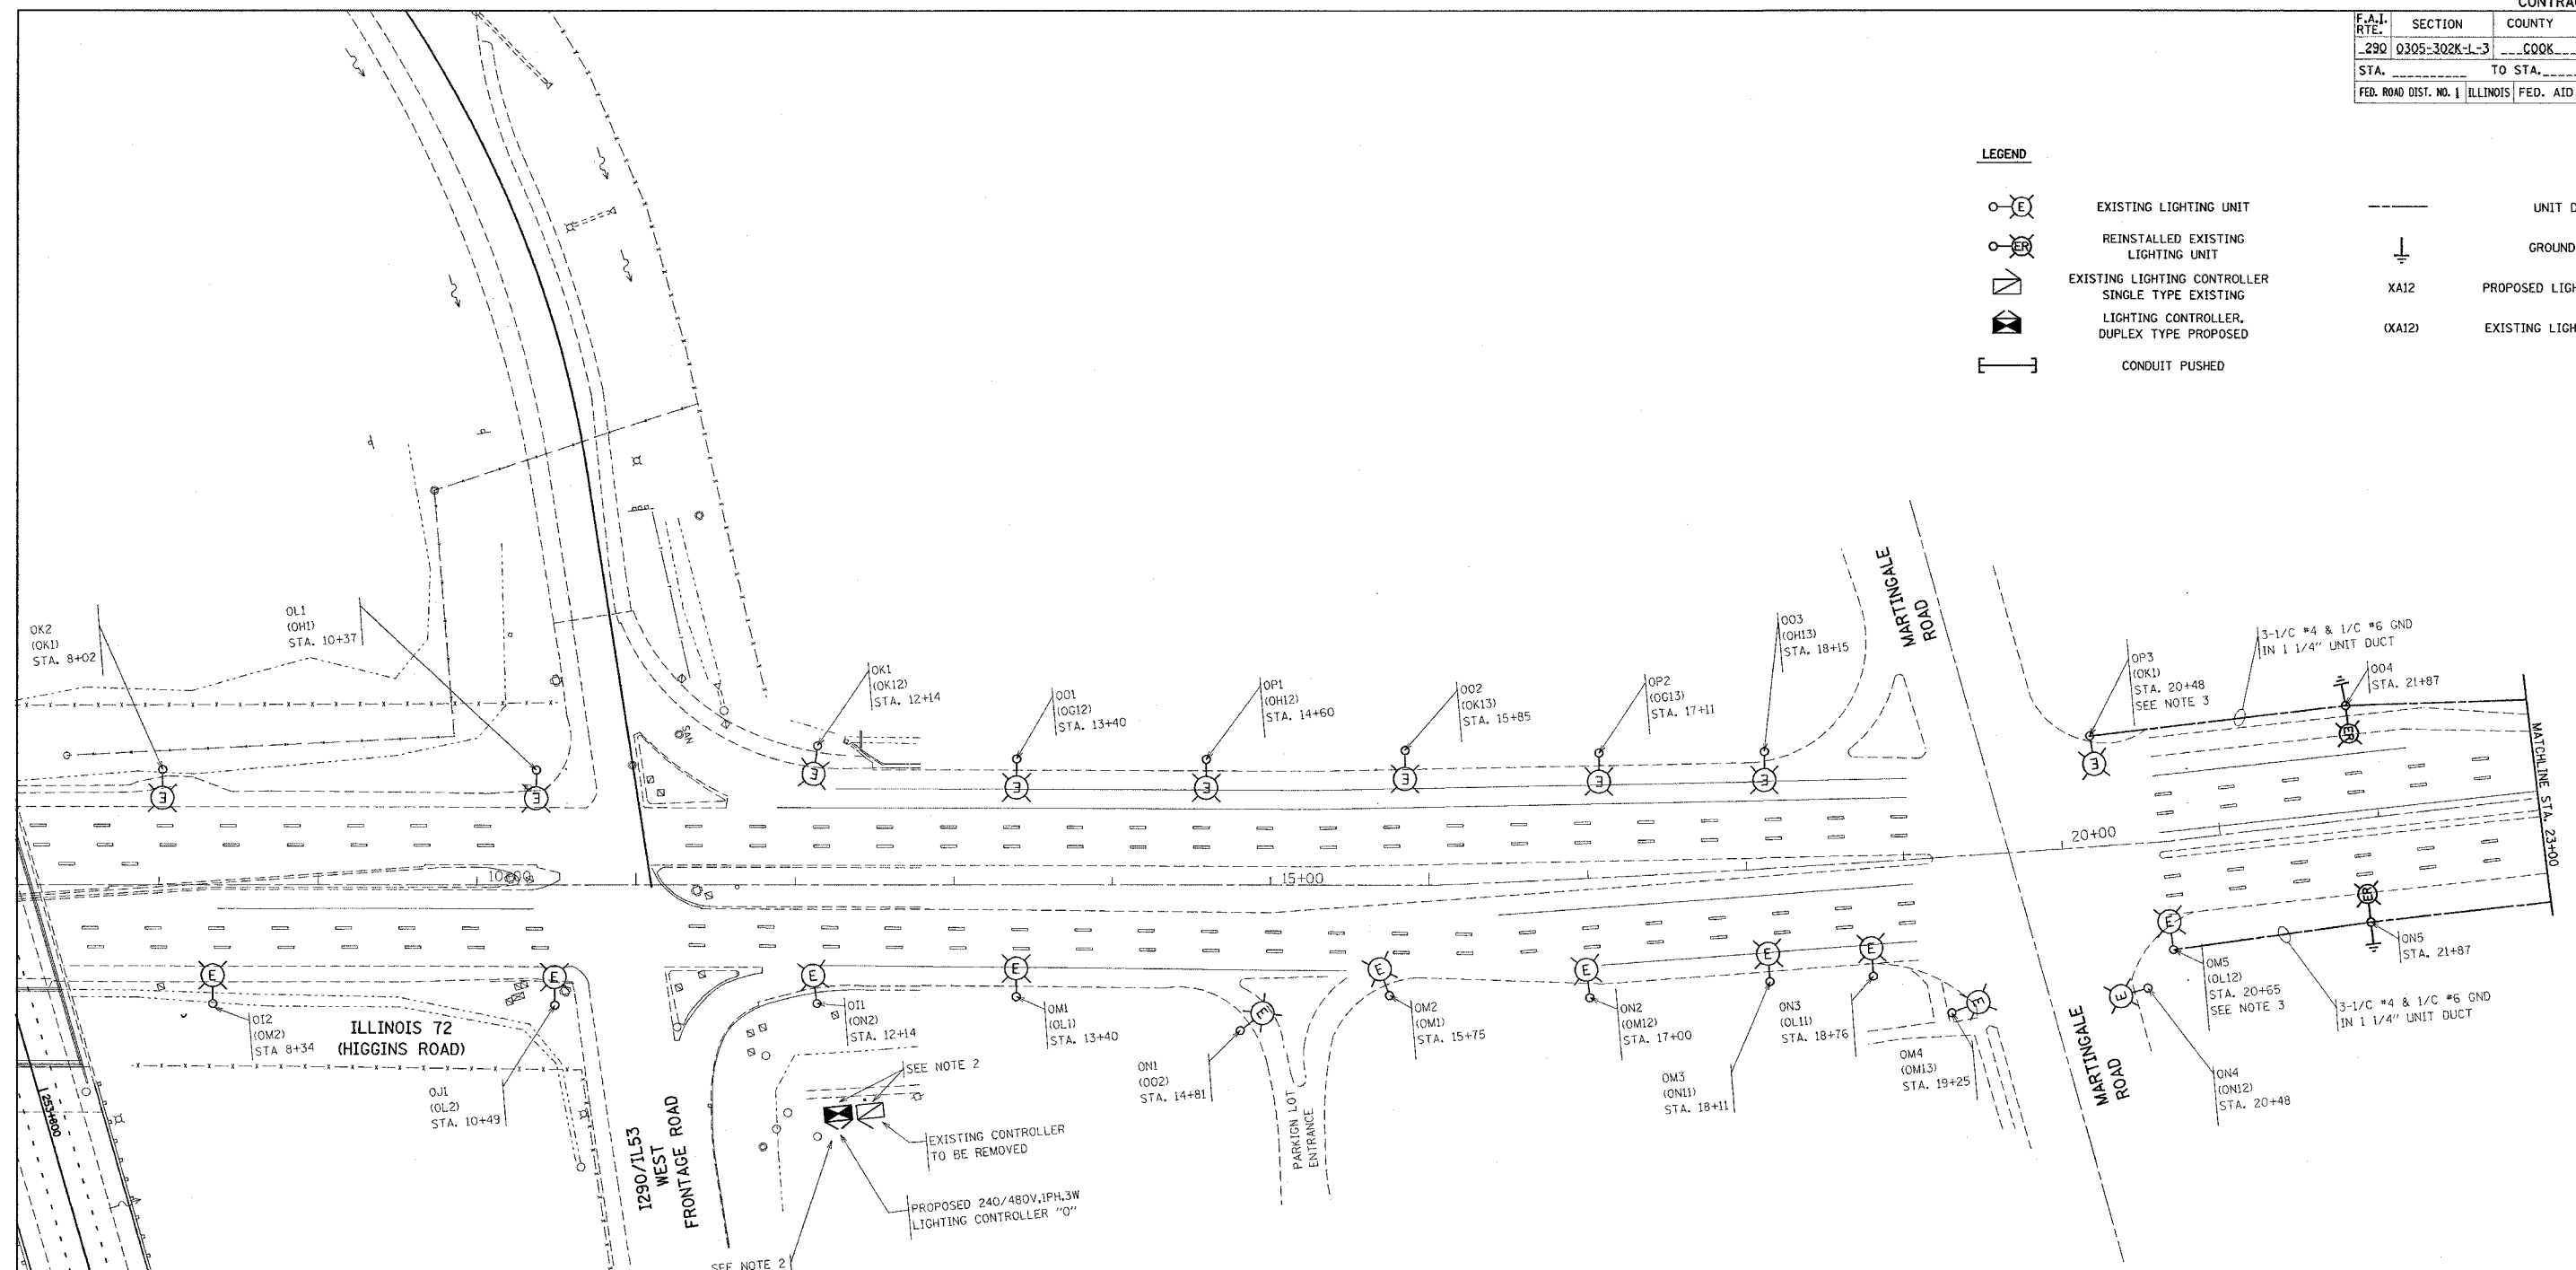

NOTES:

- EXISTING LIGHT POLES EAST OF I-290 TO BE RELABELLED AS SHOWN ON ONE LINE DIAGRAM SHEET E-11.
- FOR EXISTING CONTROLLER REMOVAL, PROPOSED CONTROLLER INSTALLATION, AND RECONNECTION OF EXISTING ROADWAY LIGHTING UNITS TO THE PROPOSED CONTROLLER, SEE SHEETS E-1 AND E-11.
- THE CONTRACTOR SHALL INTERCEPT THE EXISTING CIRCUITS AND EXTEND TO THE RELOCATED LIGHTING UNITS. PROVIDE NEW UNIT DUCT. COORDINATE EXACT ROUTING OF UNIT DUCT IN THE FIELD. THIS WORK IS PAID FOR UNDER THE PAY ITEM FOR UNIT DUCT OF THE TYPE SPECIFIED.
- REINSTALLED LIGHTING UNITS ARE TO MATCH THE EXISTING POLES IN MOUNTING HEIGHT, MAST ARM, SET BACK, LUMINAIRE TYPE, AND LUMINAIRE WATTAGE. IF EXISTING SET BACK CAN NOT BE MATCHED, MINIMUM SET BACK SHALL BE 12 FEET FROM THE EDGE OF TRAVELED PAVEMENT.
- REINSTALLED EXISTING LIGHTING UNITS SHALL BE RELOCATED FROM I-290/IL 53 PROJECT LIMITS OR DELIVERED FROM STATE STOCK, AS DIRECTED BY THE ENGINEER.
- REPLACEMENT LUMINAIRES FOR THE EXISTING AND RELOCATED LIGHTING UNITS ON HIGGINS ROAD RECONNECTED TO PROPOSED CONTROLLER "O" SHALL BE DELIVERED FROM STATE STOCK. BALLASTS SHALL BE SET FOR 240 VOLT OPERATION. THIS WORK SHALL BE PAID FOR UNDER THE PAY ITEM FOR LUMINAIRE (INSTALL ONLY), OF THE TYPE SPECIFIED.

DATE = 4/7/2005
 FILE NAME = c:\projects\1153\1153.dgn
 PLOT SCALE = 1/8"=1'-0"
 USER NAME = jason

| REVISIONS | |
|-----------|------|
| NAME | DATE |
| | |
| | |
| | |
| | |
| | |
| | |
| | |

ILLINOIS DEPARTMENT OF TRANSPORTATION

**IL-72 (HIGGINS ROAD)
 LIGHTING RELOCATION
 PLANS**

SCALE: VERT. 1"=50'
 HORIZ. 1"=50'
 DATE 4/7/2005

DRAWN BY MP
 CHECKED BY SL