
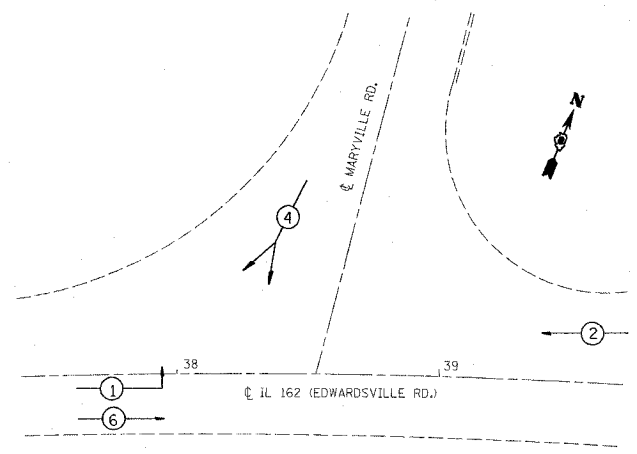


F.A.P. RTE.	SECTION	COUNTY	TOTAL SHEETS	SHEET NO.
586	57-TS-1	MADISON	8	5
STA.		TO STA.		
FED. ROAD DIST. NO.	ILLINOIS	FED. AID PROJECT		


IL 162 @ MARYVILLE ROAD

EXISTING SEQUENCE OF OPERATION								
PHASE	1	2	3	4	5	6	7	8
MOVEMENT	EB LT	WB	NOT	SB	NOT	EB	NOT	NOT
CONCURRENT MOVEMENT PERMITTED	6	6	USED	NONE	USED	1 OR 2	USED	USED

NOTE: EXISTING CONTROLLER IS ECONOLITE ASC 8000

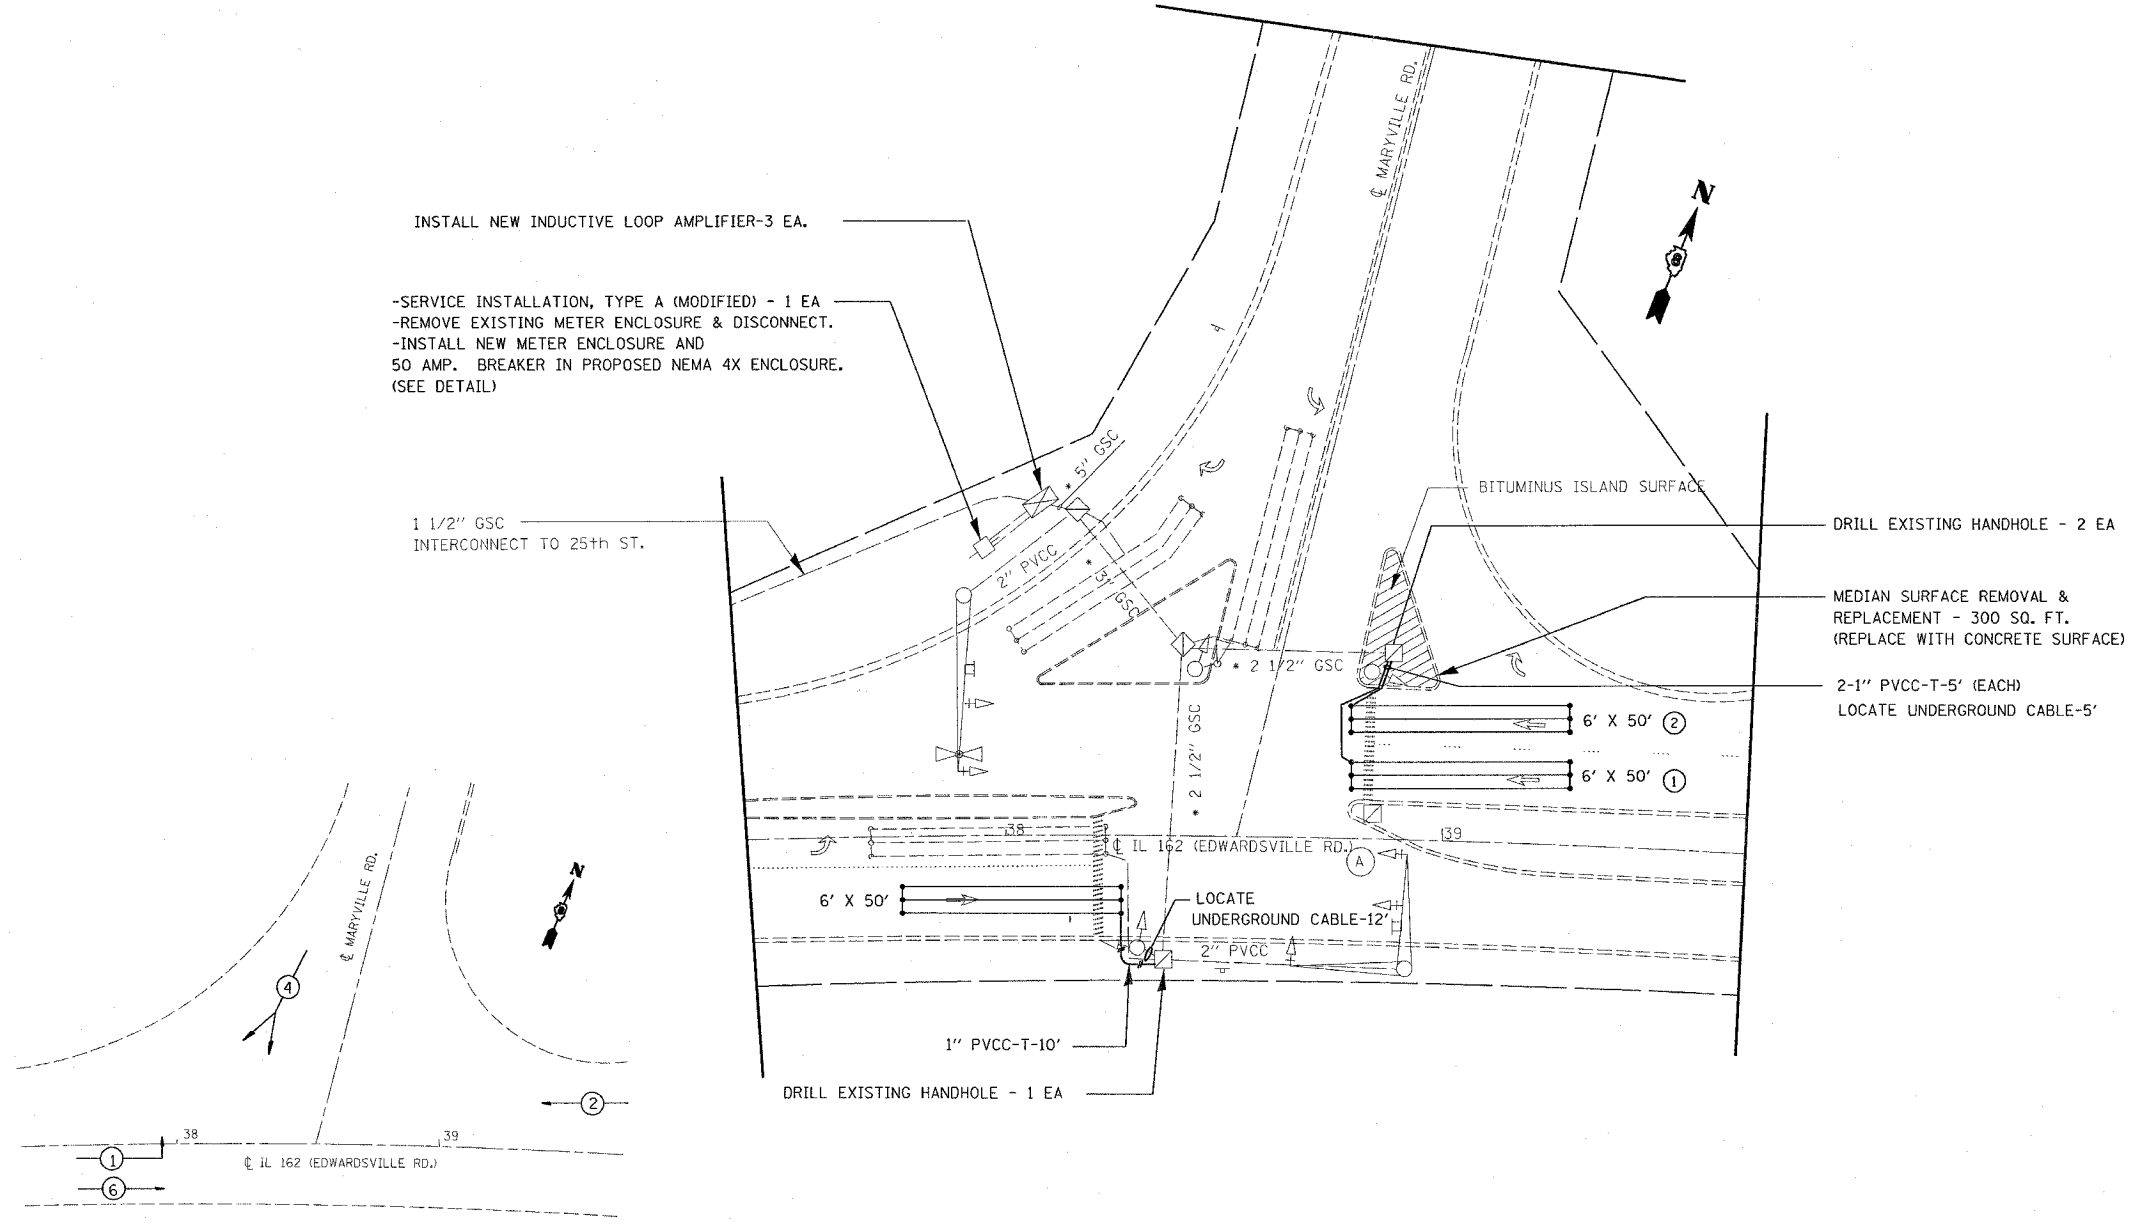

 PHASE DESIGNATION DIAGRAM



• REMOVE & REINSTALL ELECTRIC CABLE FROM CONDUIT - 500 FT.

REVISIONS	
NAME	DATE

ILLINOIS DEPARTMENT OF TRANSPORTATION
PLAN VIEW
 FAP ROUTE 586
 SECTION 57-TS-1
 MADISON COUNTY
 IL 162 @ MARYVILLE RD.
 VERT. SCALE: DRAWN BY
 HORIZ. SCALE: CHECKED BY
 DATE: DATE:

PLOT DATE = #DATE#
 FILE NAME = #FILE#
 PLOT SCALE = #SCALE#
 REFERENCE = #REF#