


F.A.P. RTE.	SECTION	COUNTY	TOTAL SHEETS	SHEET NO.
586	57-TS-1	MADISON	8	6
STA.		TO STA.		
FED. ROAD DIST. NO.	ILLINOIS	FED. AID PROJECT		

IL 162 @ 23rd STREET

EXISTING SEQUENCE OF OPERATION								
PHASE	1	2	3	4	5	6	7	8
MOVEMENT	NOT	← WB	NOT	↙ SB	NOT	→ EB	NOT	NOT
CONCURRENT MOVEMENT PERMITTED	USED	6	USED	NONE	USED	2	USED	USED

NOTE: EXISTING CONTROLLER IS ECONOLITE ASC 8000

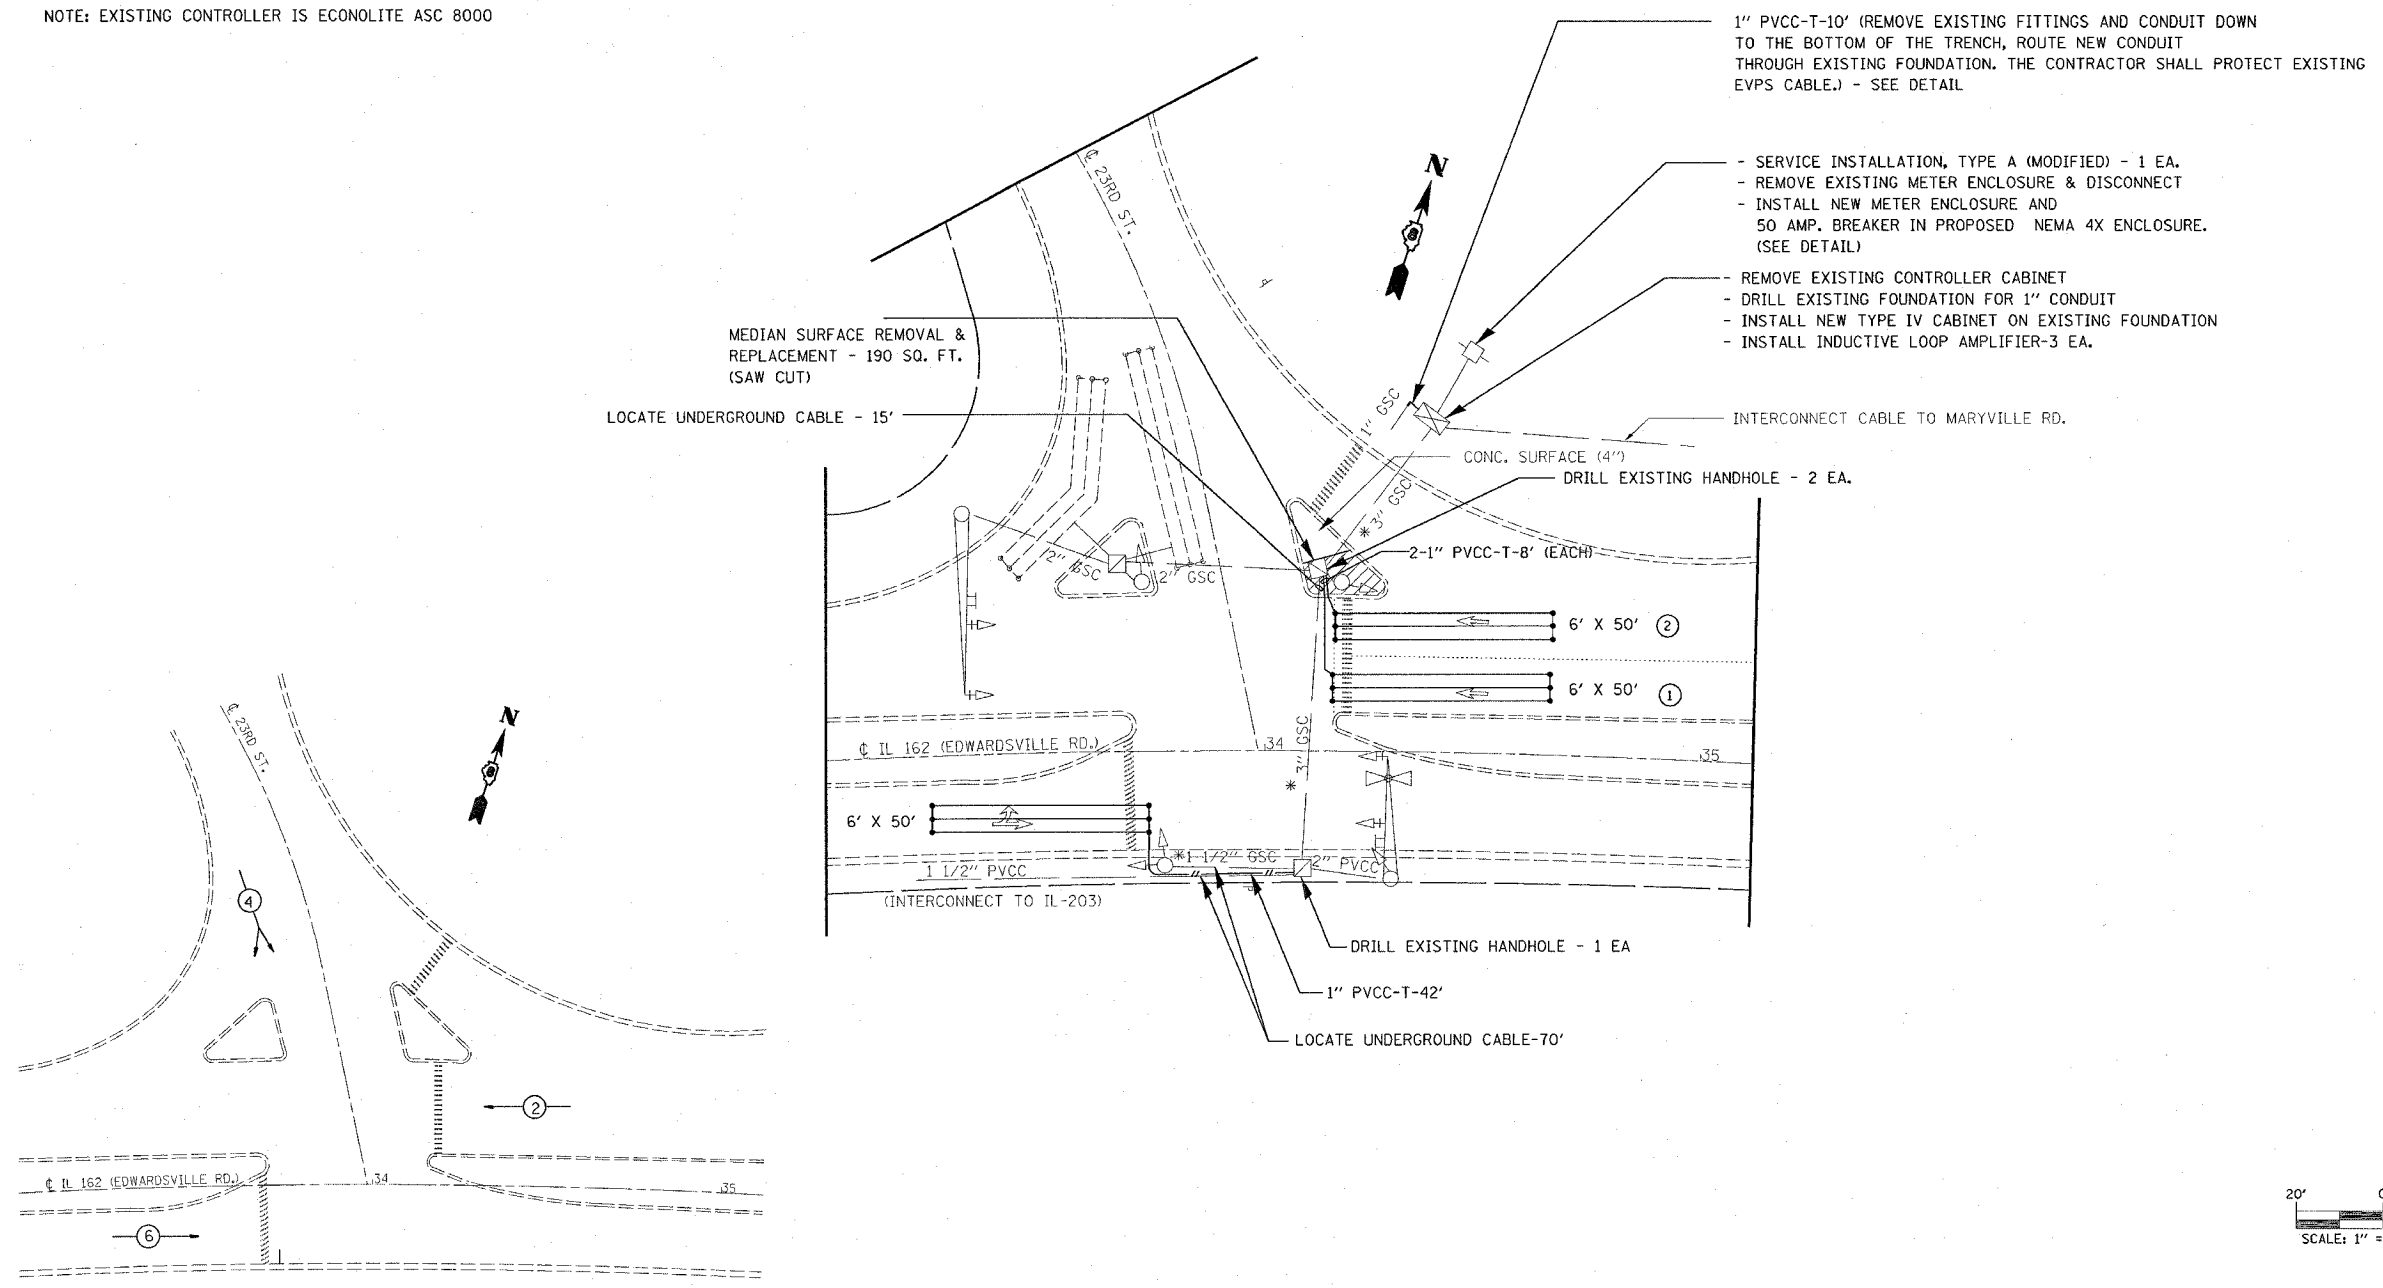

PHASE DESIGNATION DIAGRAM

\* REMOVE & REINSTALL ELECTRIC CABLE FROM CONDUIT - 400 FT.

REVISIONS	
NAME	DATE

ILLINOIS DEPARTMENT OF TRANSPORTATION

**PLAN VIEW**

FAP ROUTE 586  
SECTION 57-TS-1  
MADISON COUNTY  
IL 162 @ 23rd ST.

SCALE: VERT. DATE      HORIZ. DRAWN BY CHECKED BY

PLOT DATE = #DATE#  
FILE NAME = #FILE#  
PLOT SCALE = #SCALE#  
REFERENCE = #REF#