
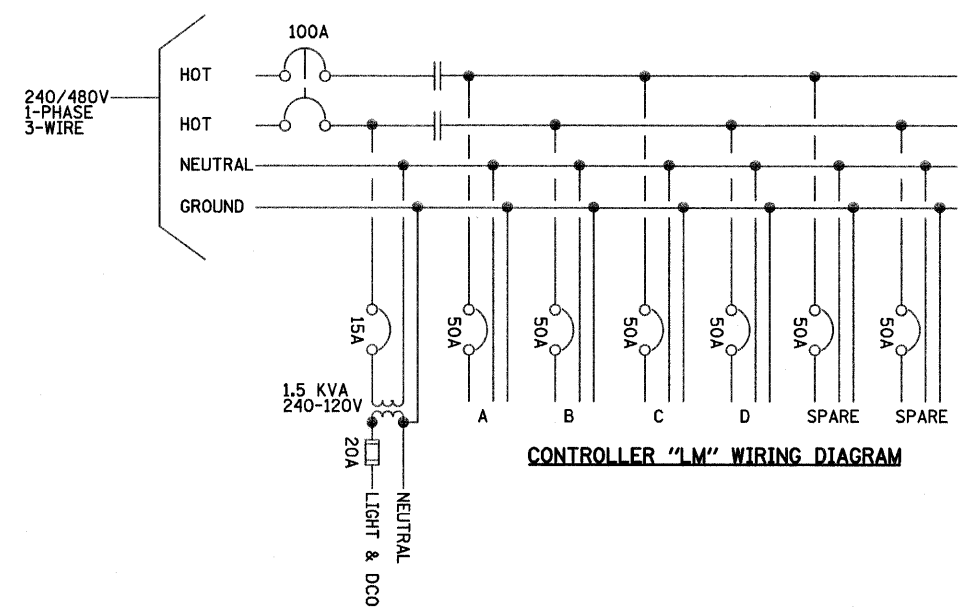


PANEL SCHEDULE AND LOAD TABULATION
LIGHTING CONTROLLER LM
240 / 480 VOLTS 1-PHASE, 3-WIRE
MAIN BREAKER: 100A

CIRCUIT	BREAKER TRIP AMPS	KW		AMPS
		BLACK	RED	
A	50	--	3.3	13.9
B	50	3.8	--	15.9
C	50	--	2.4	9.9
D	50	2.4	--	9.9
SPARE	50			
SPARE	50			
SUBTOTAL		6.2	5.7	--
TOTAL		11.9		24.8

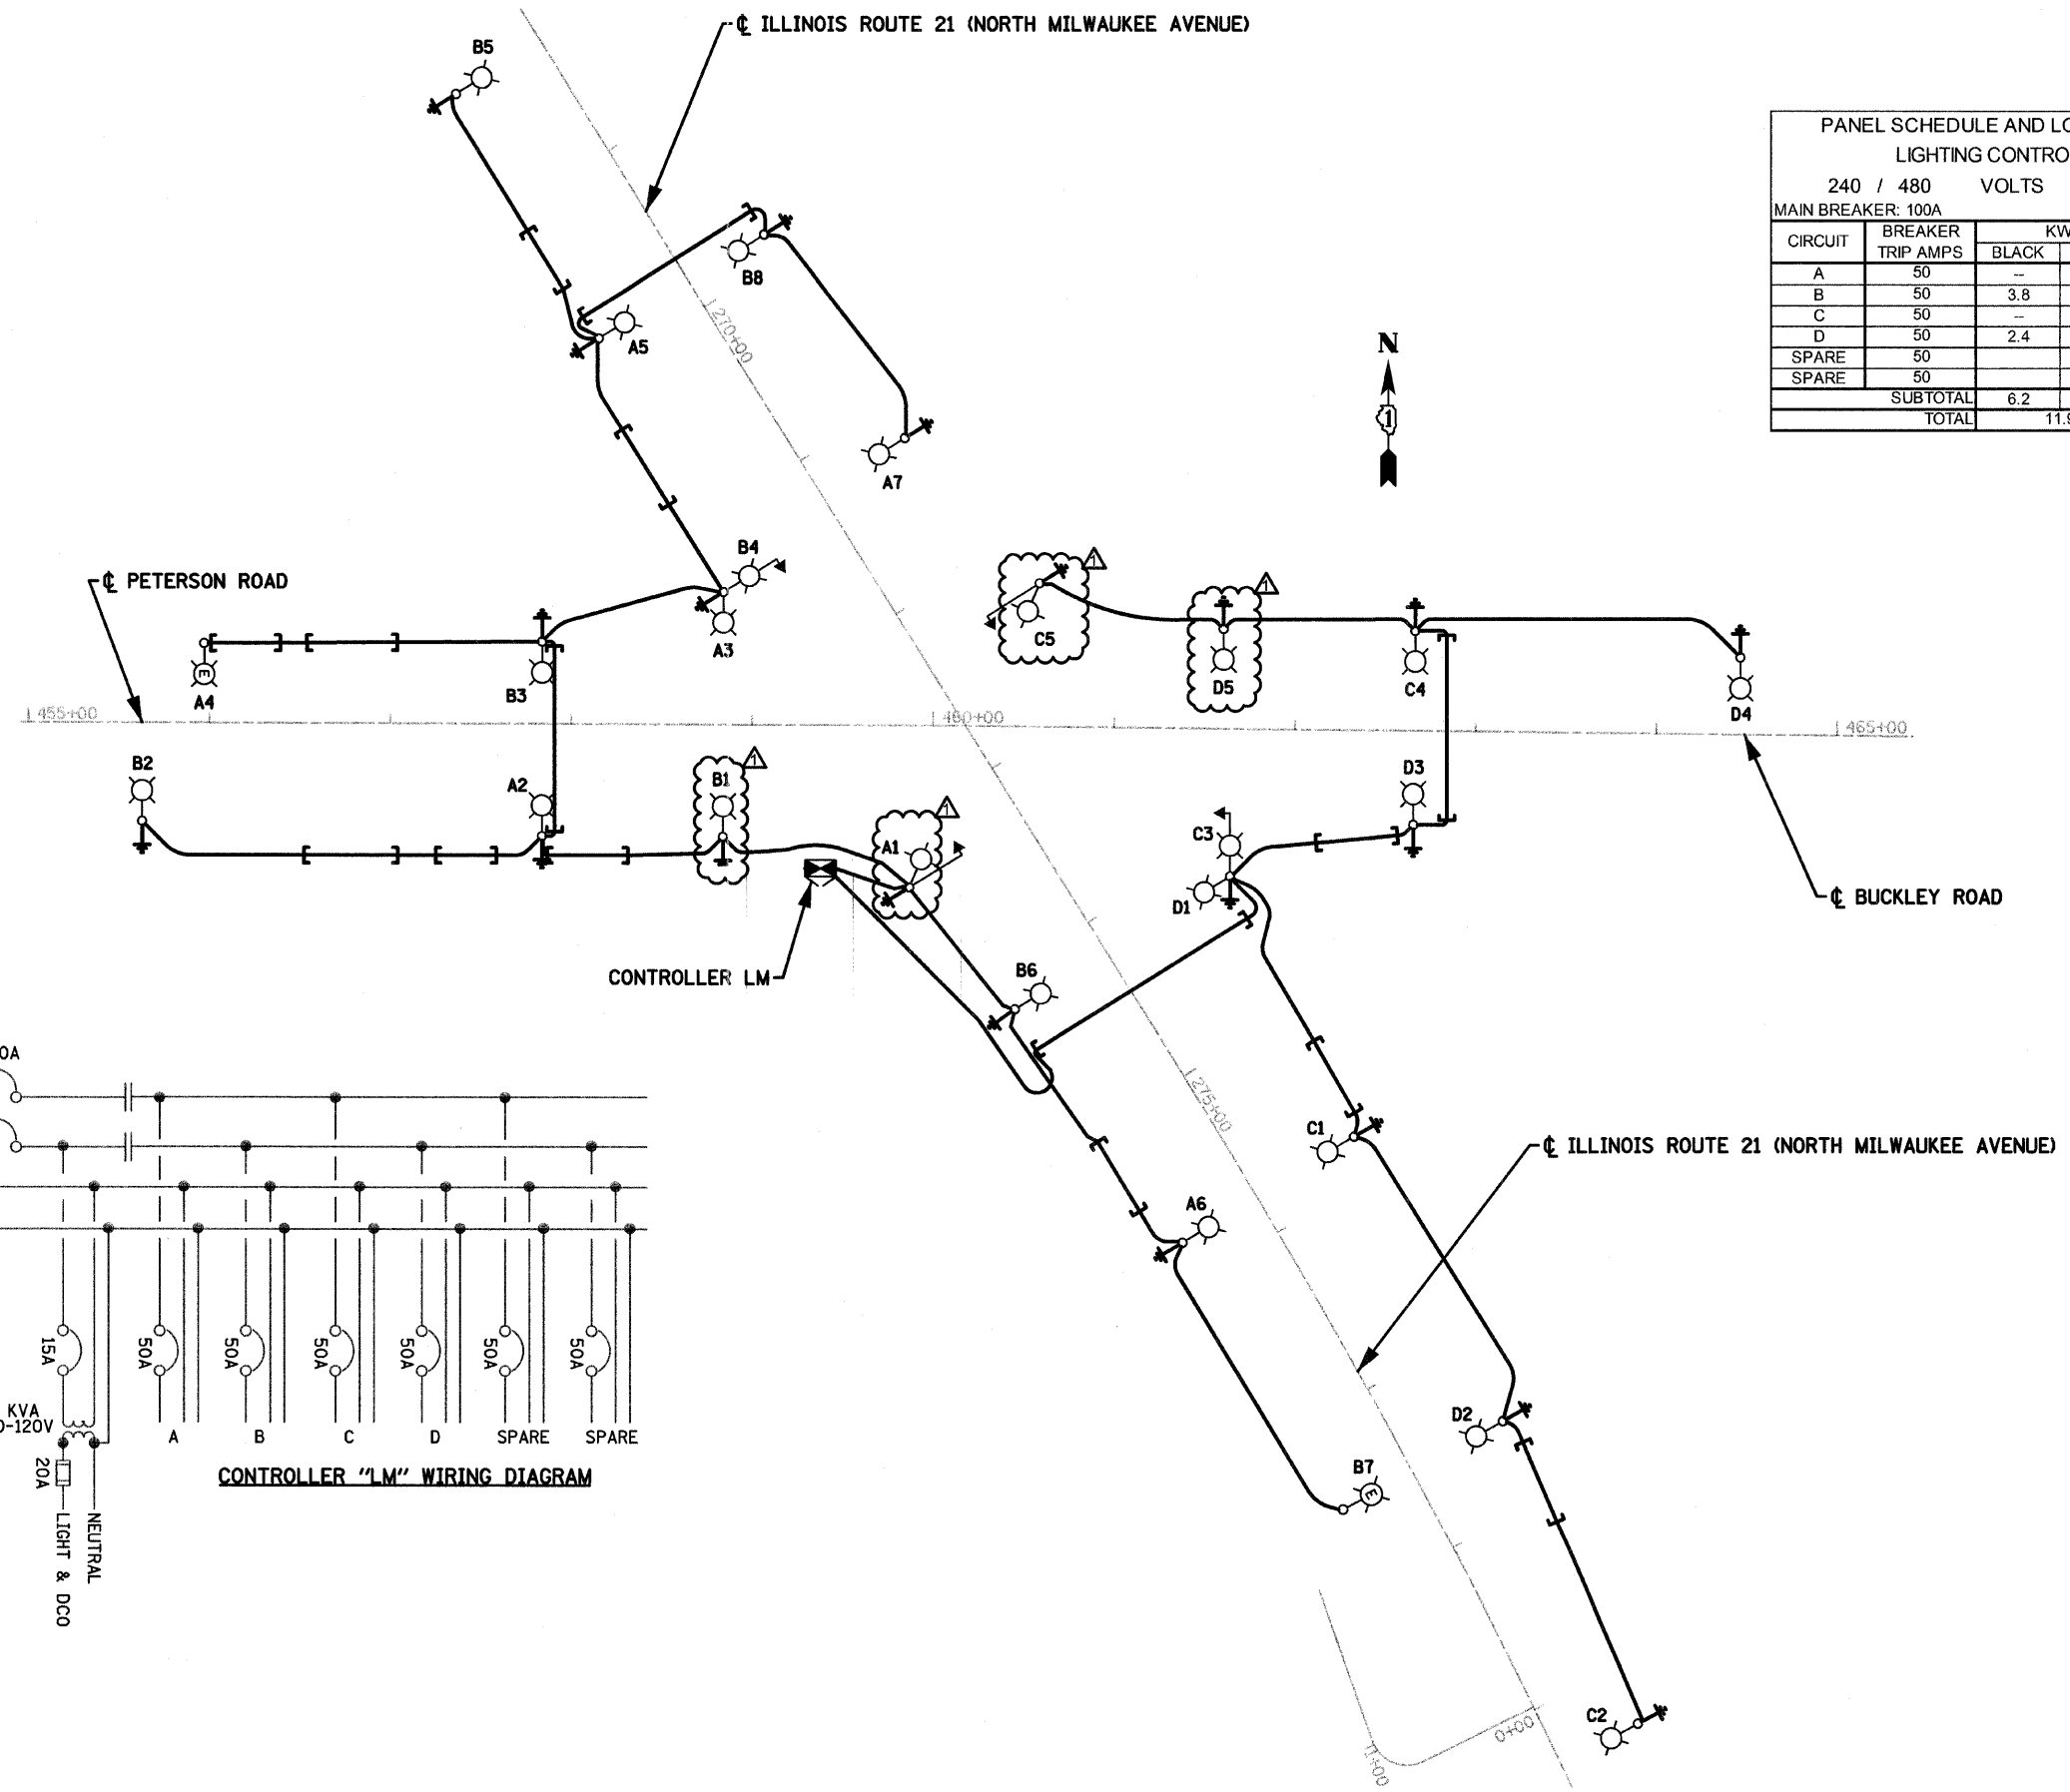

SPAAN Tech, Inc.
311 South Wacker Drive, Suite 2400
Chicago, IL 60605
phone: 312.277.8800
fax: 312.277.8808
web: www.SpaanTech.com

LT-05.dgn
BT1 - PDF.plt
9/1/2011 10:43:26 AM

USER NAME = Mansah Jhe	DESIGNED - IB	REVISED - 09/02/11 IB
PLOT SCALE = 1/8" = 1'-0"	DRAWN - MJ	REVISED -
SpaanTech - By LineWeight - grayscale.tbl	CHECKED - YK	REVISED -
	DATE - 04/13/11	REVISED -

STATE OF ILLINOIS
DEPARTMENT OF TRANSPORTATION

ILLINOIS ROUTE 21 AND ILLINOIS ROUTE 137
WIRING DIAGRAM

SCALE: NONE SHEET NO. OF SHEETS STA. TO STA.

F.A.P. RTE.	SECTION	COUNTY	TOTAL SHEETS	SHEET NO.
330	128R-3	LAKE	517	233
ILLINOIS FED. AID PROJECT			CONTRACT NO. 60953	

LT-05