
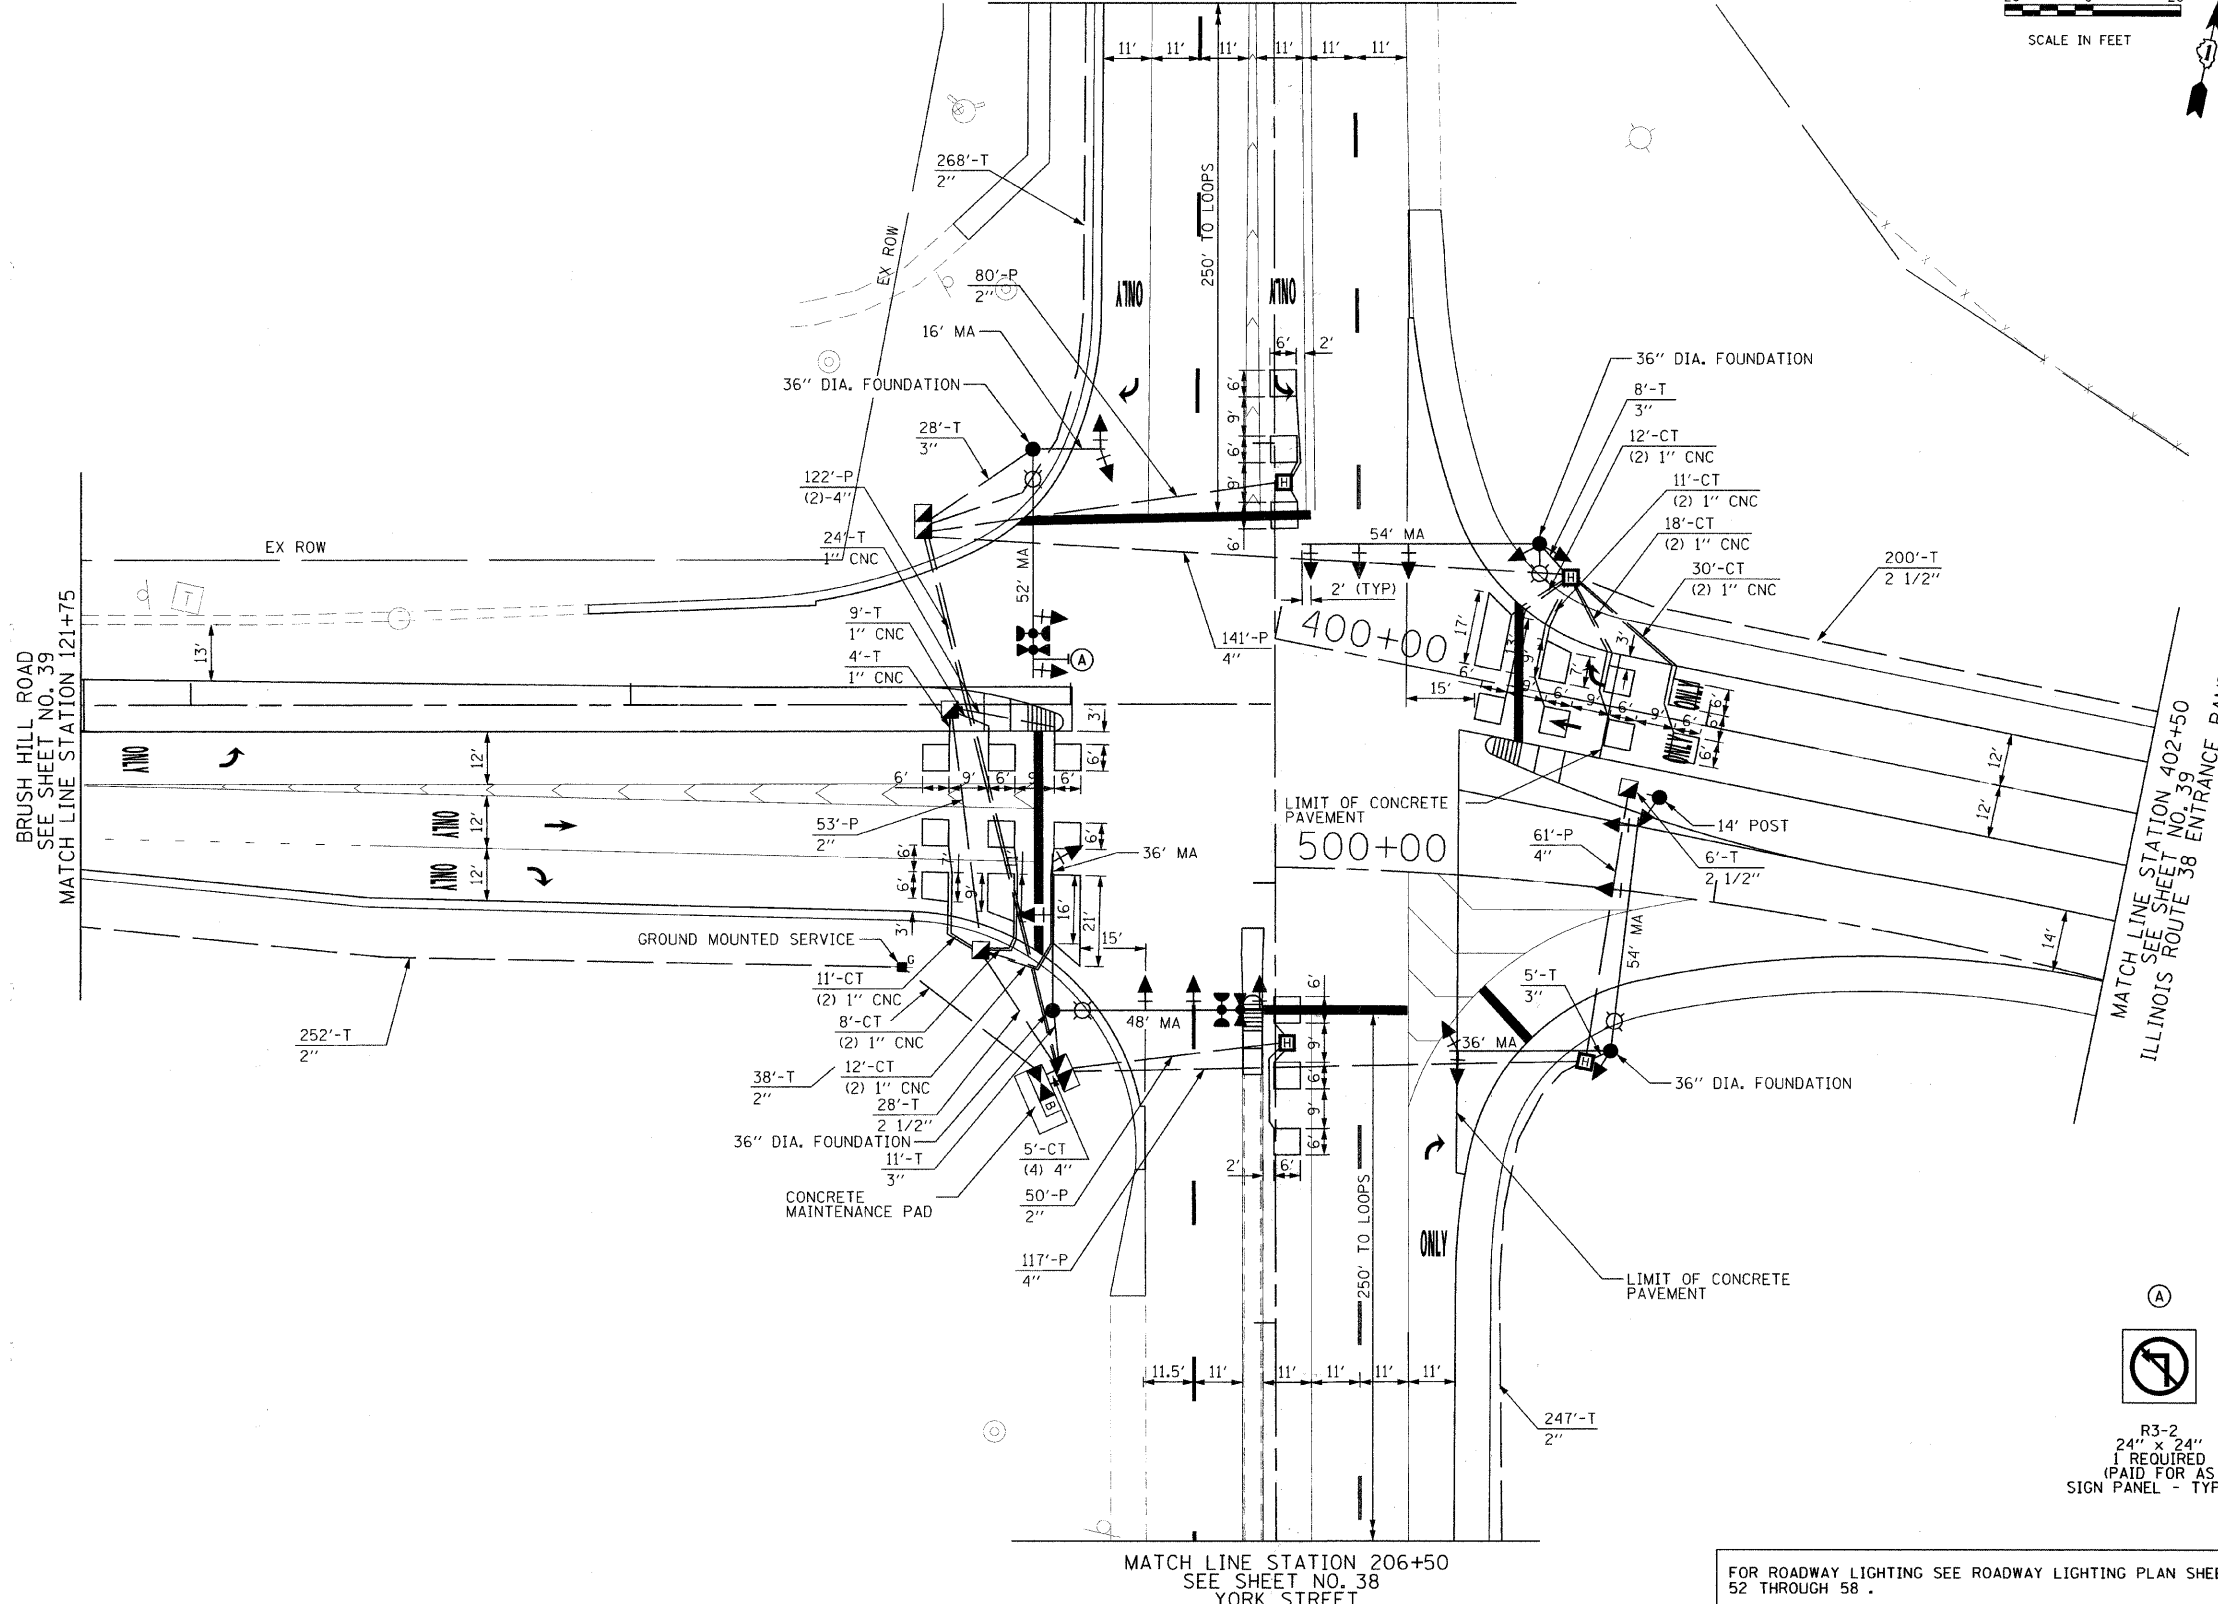


NOTE: THE ENVIRONMENTAL FIRM IS REQUIRED TO CONTINUOUSLY MONITOR FOR WORKER PROTECTION AND SOIL CONTAMINATION AT SEVERAL AREAS. SEE SPECIAL PROVISIONS AND SUPPLEMENTAL SPECIFICATIONS FOR DETAILS.

YORK STREET
SEE SHEET NO. 38
MATCH LINE STATION 210+00

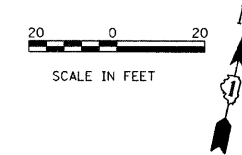

PLAN	DATE
NO.	
BY	
DATE	
NO.	
BY	
DATE	
NO.	
BY	
DATE	
NO.	

PROFILE	DATE
NO.	
BY	
DATE	
NO.	
BY	
DATE	
NO.	

R3-2
24" x 24"
REQUIRED
(PAID FOR AS
SIGN PANEL - TYPE 1)

FOR ROADWAY LIGHTING SEE ROADWAY LIGHTING PLAN SHEETS 52 THROUGH 58.

FILE NAME =	USER NAME = jngolemba	DESIGNED - KB	REVISED -	STATE OF ILLINOIS DEPARTMENT OF TRANSPORTATION	YORK STREET AT IL RTE 38 RAMPS/BRUSH HILL ROAD PROPOSED TRAFFIC SIGNAL INSTALLATION PLAN (1 OF 3)	F.A.U. RTE.	SECTION	COUNTY	TOTAL SHEETS	SHEET NO.	
g:\CH00\0007\Road\Phase 2\Sheets\DX\2007-TS-Sheet1.dgn		DRAWN - AJP	REVISED -			2678	09-00171-00-CH	DUPAGE	85	37	
PLOT SCALE = 20.0000 "/ IN.		CHECKED - KMM	REVISED -			SCALE: 1"=20'		SHEET NO. 37 OF 85 SHEETS		STA. TO STA.	
PLOT DATE = 6/22/2011		DATE - 7/4/2011	REVISED -			FED. ROAD DIST. NO. 7 ILLINOIS FED. AID PROJECT		CONTRACT NO. 63610			