



LEGEND

- ⊗ TEMPORARY WOOD POLE, 50 FT. CLASS 4, 15 FT MAST ARM WITH TEMPORARY LUMINAIRE, HIGH PRESSURE SODIUM VAPOR, HORIZONTAL MOUNT, 250 WATT
- ⊗ TEMPORARY SIGNAL POLE WITH TEMPORARY MAST ARM 15' AND TEMPORARY LUMINAIRE, HIGH PRESSURE SODIUM VAPOR, HORIZONTAL MOUNT, 250 WATT
- A— TEMPORARY AERIAL CABLE, 2-1/C NO. 4, WITH MESSENGER WIRE
- ⊙(E) EXISTING LIGHTING UNIT TO REMAIN
- ⊙(REL) EXISTING LIGHTING UNIT TO BE RELOCATED
- ⊙(REM) EXISTING LIGHTING UNIT TO BE REMOVED

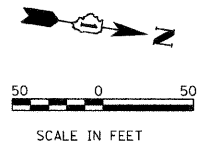

NOTE:
EXISTING AND TEMPORARY LIGHTING SHALL BE OPERATIONAL AT ALL TIMES.

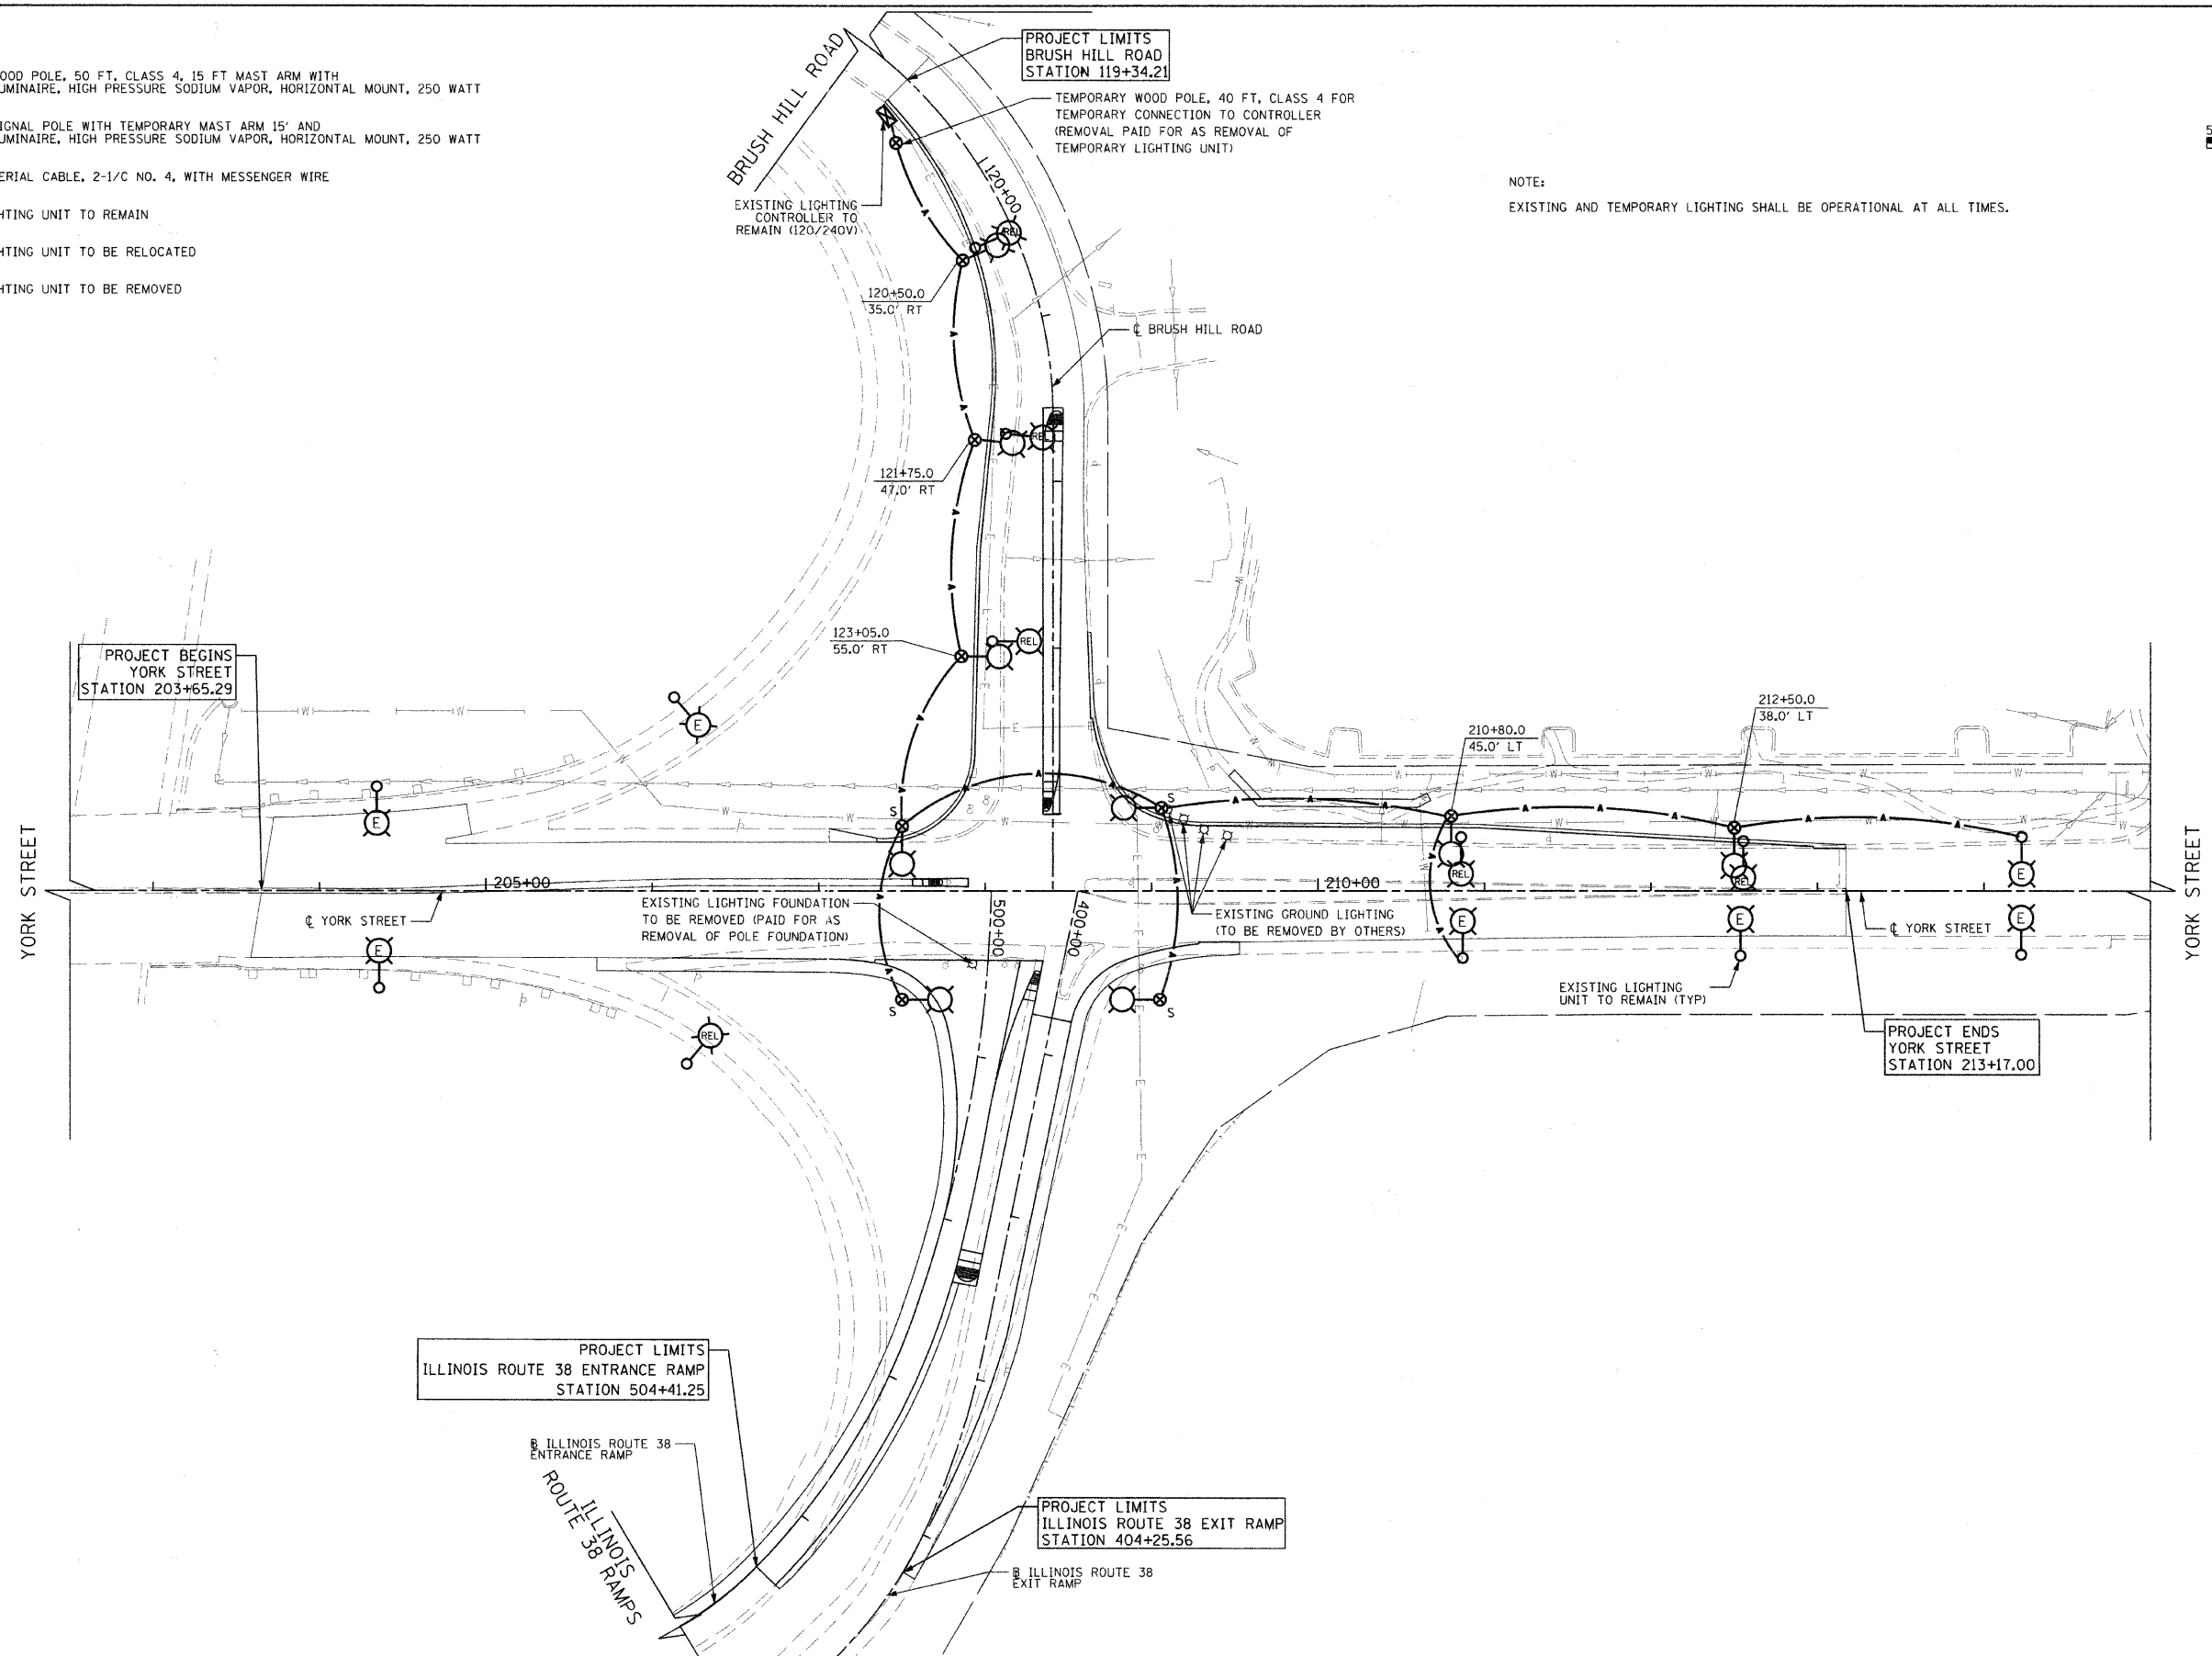

PLAN	REVISIONS	DATE
NO.	BY	
NO.	BY	
NO.	BY	
NO.	BY	

PROFILE	REVISIONS	DATE
NO.	BY	
NO.	BY	
NO.	BY	
NO.	BY	

FILE NAME = g:\ch09\0007\road\phase 2\sheet\01X0007	USER NAME = jmg1emba	DESIGNED - KB	REVISED -	STATE OF ILLINOIS DEPARTMENT OF TRANSPORTATION	YORK STREET AT IL RTE 38 RAMPS/BRUSH HILL ROAD TEMPORARY LIGHTING PLAN	F.A.U. RTE. 2678	SECTION 09-00171-00-CH	COUNTY DUPAGE	TOTAL SHEETS 85	SHEET NO. 52
PLOT SCALE = 50.0000' / IN.	DRAWN - AJP	CHECKED - LGB	REVISED -			SCALE: 1"=50'	SHEET NO. 52 OF 85 SHEETS	STA. 202+50	TO STA. 214+50	FED. ROAD DIST. NO. 7 (ILLINOIS) FED. AID PROJECT
PLOT DATE = 8/4/2011	DATE - 7/4/2011	REVISED -	REVISED -			CONTRACT NO. 63610				