


EXISTING CONDITIONS

NOTES:
 1. THE PROPOSED LIGHTING UNIT LOCATION SHALL BE COORDINATED WITH EXISTING UTILITIES AND THE ENGINEER. LIGHT POLE SHALL BE MINIMUM 4 FEET SETBACK FROM FACE OF EXISTING CURB. LIGHTING UNITS TO BE MAINTAINED BY THE VILLAGE OF GLENVIEW.

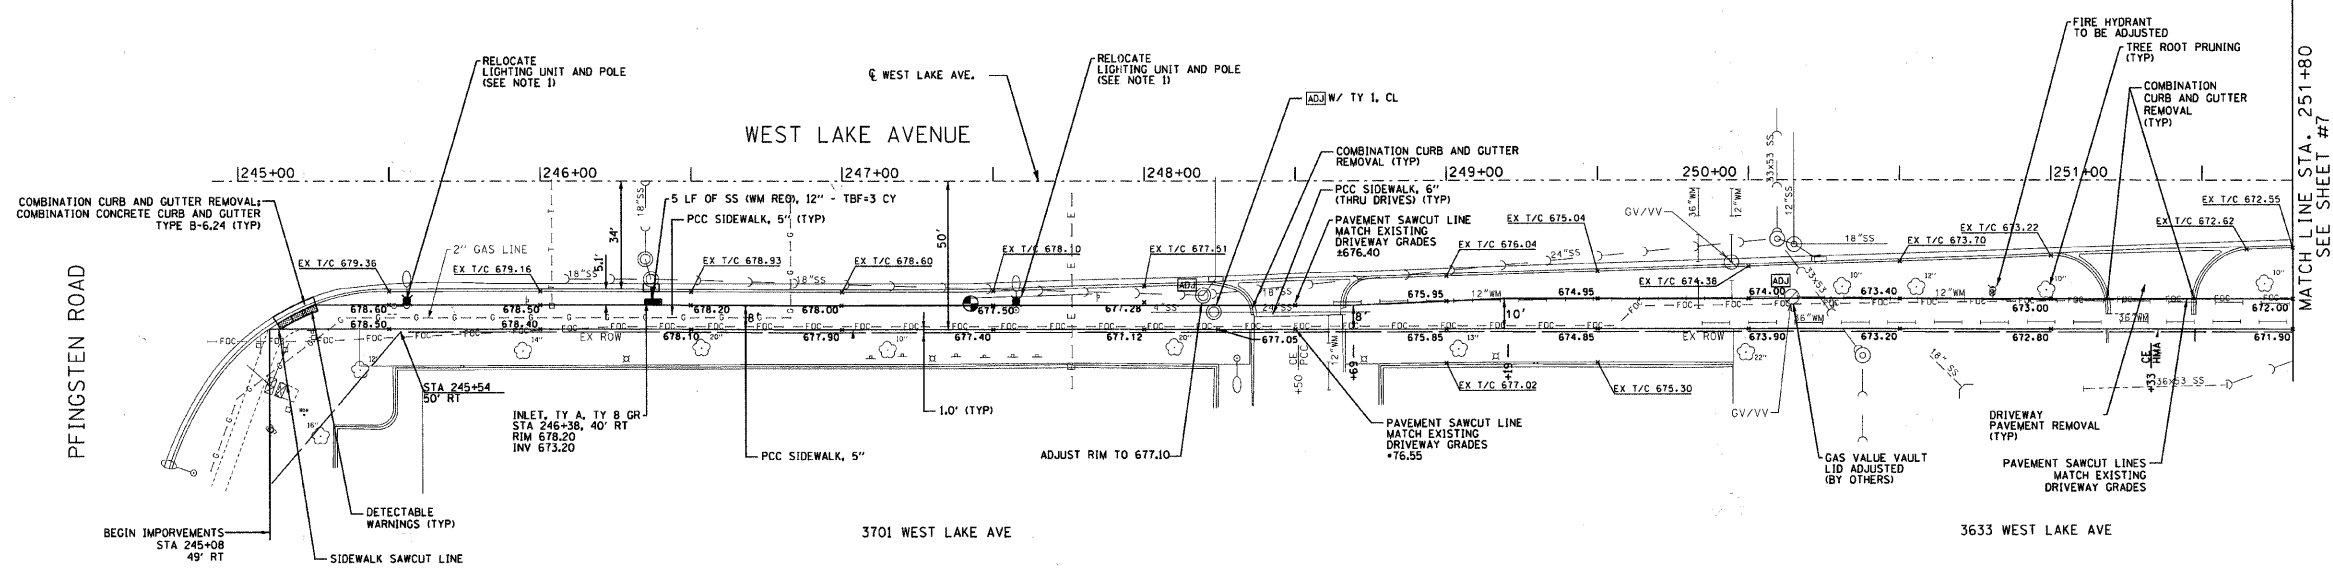

PROPOSED CONDITIONS

CAPRI CONSULTING & DESIGN, INC. 1000 N. WILSON AVENUE, SUITE 100, GLENVIEW, IL 60025-3407
 PROJECT NO. 07-00164-01-RS
 SHEET NO. 1 OF 34
 DATE: 11-10-2010
 DRAWN BY: Z.S.
 CHECKED BY: E.L.
 DATE: 2-24-2011

CAPITAL PROJECTS DEPARTMENT

DISCLAIMER
 The attached files contain information for the exclusive use of the individual or entity to whom they are addressed and may contain information that is proprietary, privileged, confidential and/or exempt from disclosure. The addressee must protect any and all proprietary, privileged, confidential and/or exempt information from disclosure. Any unauthorized use, misuse or sharing of data is a violation of applicable copyright laws. The Village makes no warranty or other representation regarding the use of the attached files for any purpose other than that for which they are originally transmitted.



WEST LAKE AVENUE
 CENTENNIAL BIKE TRAIL - SEGMENT #1
 SITE PLAN - EXISTING & PROPOSED CONDITIONS
 PFINGSTEN ROAD TO STA. 251+80

REVISIONS		
NO.	DATE	DESCRIPTION
1	4-18-11	PER IDOT COMMENTS
2	6-28-11	PER IDOT COMMENTS

DESIGNED BY: E.L.	F.A.U. RTE.	SECTION	COUNTY	TOTAL SHEETS	SHEET NO.
DATE: 11-10-2010	1284	07-00164-01-RS	COOK	34	6
DRAWN BY: Z.S.					
DATE: 11-10-2010					
CHECKED BY: E.L.	JOB. NO: C-91-275-11	FED. AID PROJECT: TE-00DI (841)			
DATE: 2-24-2011	FED. ROAD DIST. NO. 1	ILLINOIS CONTRACT NO. 63612			

