 



 



 
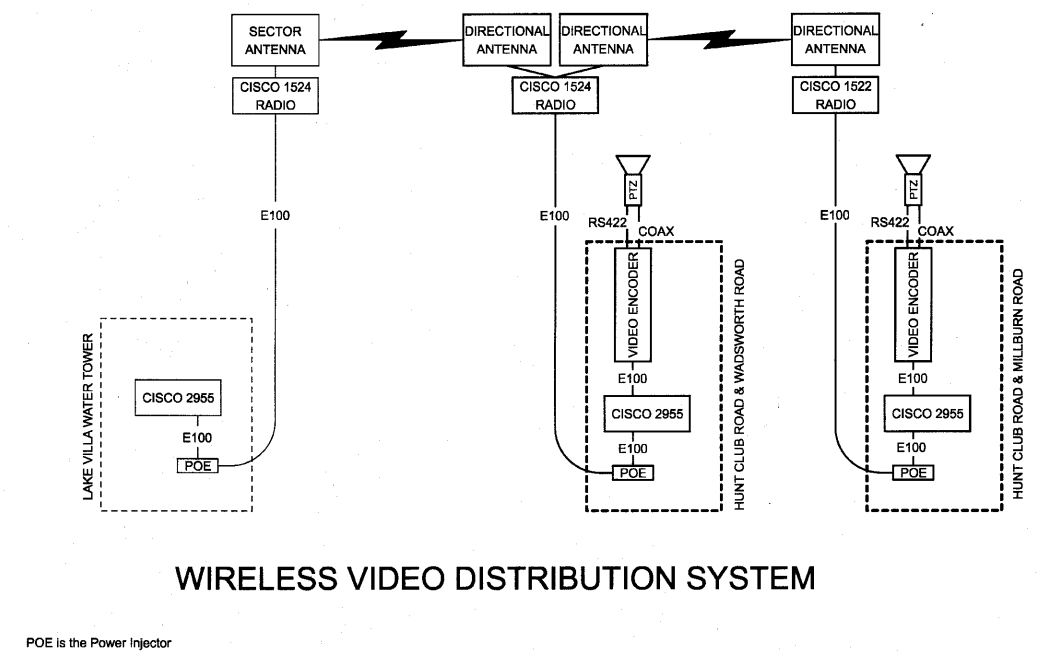
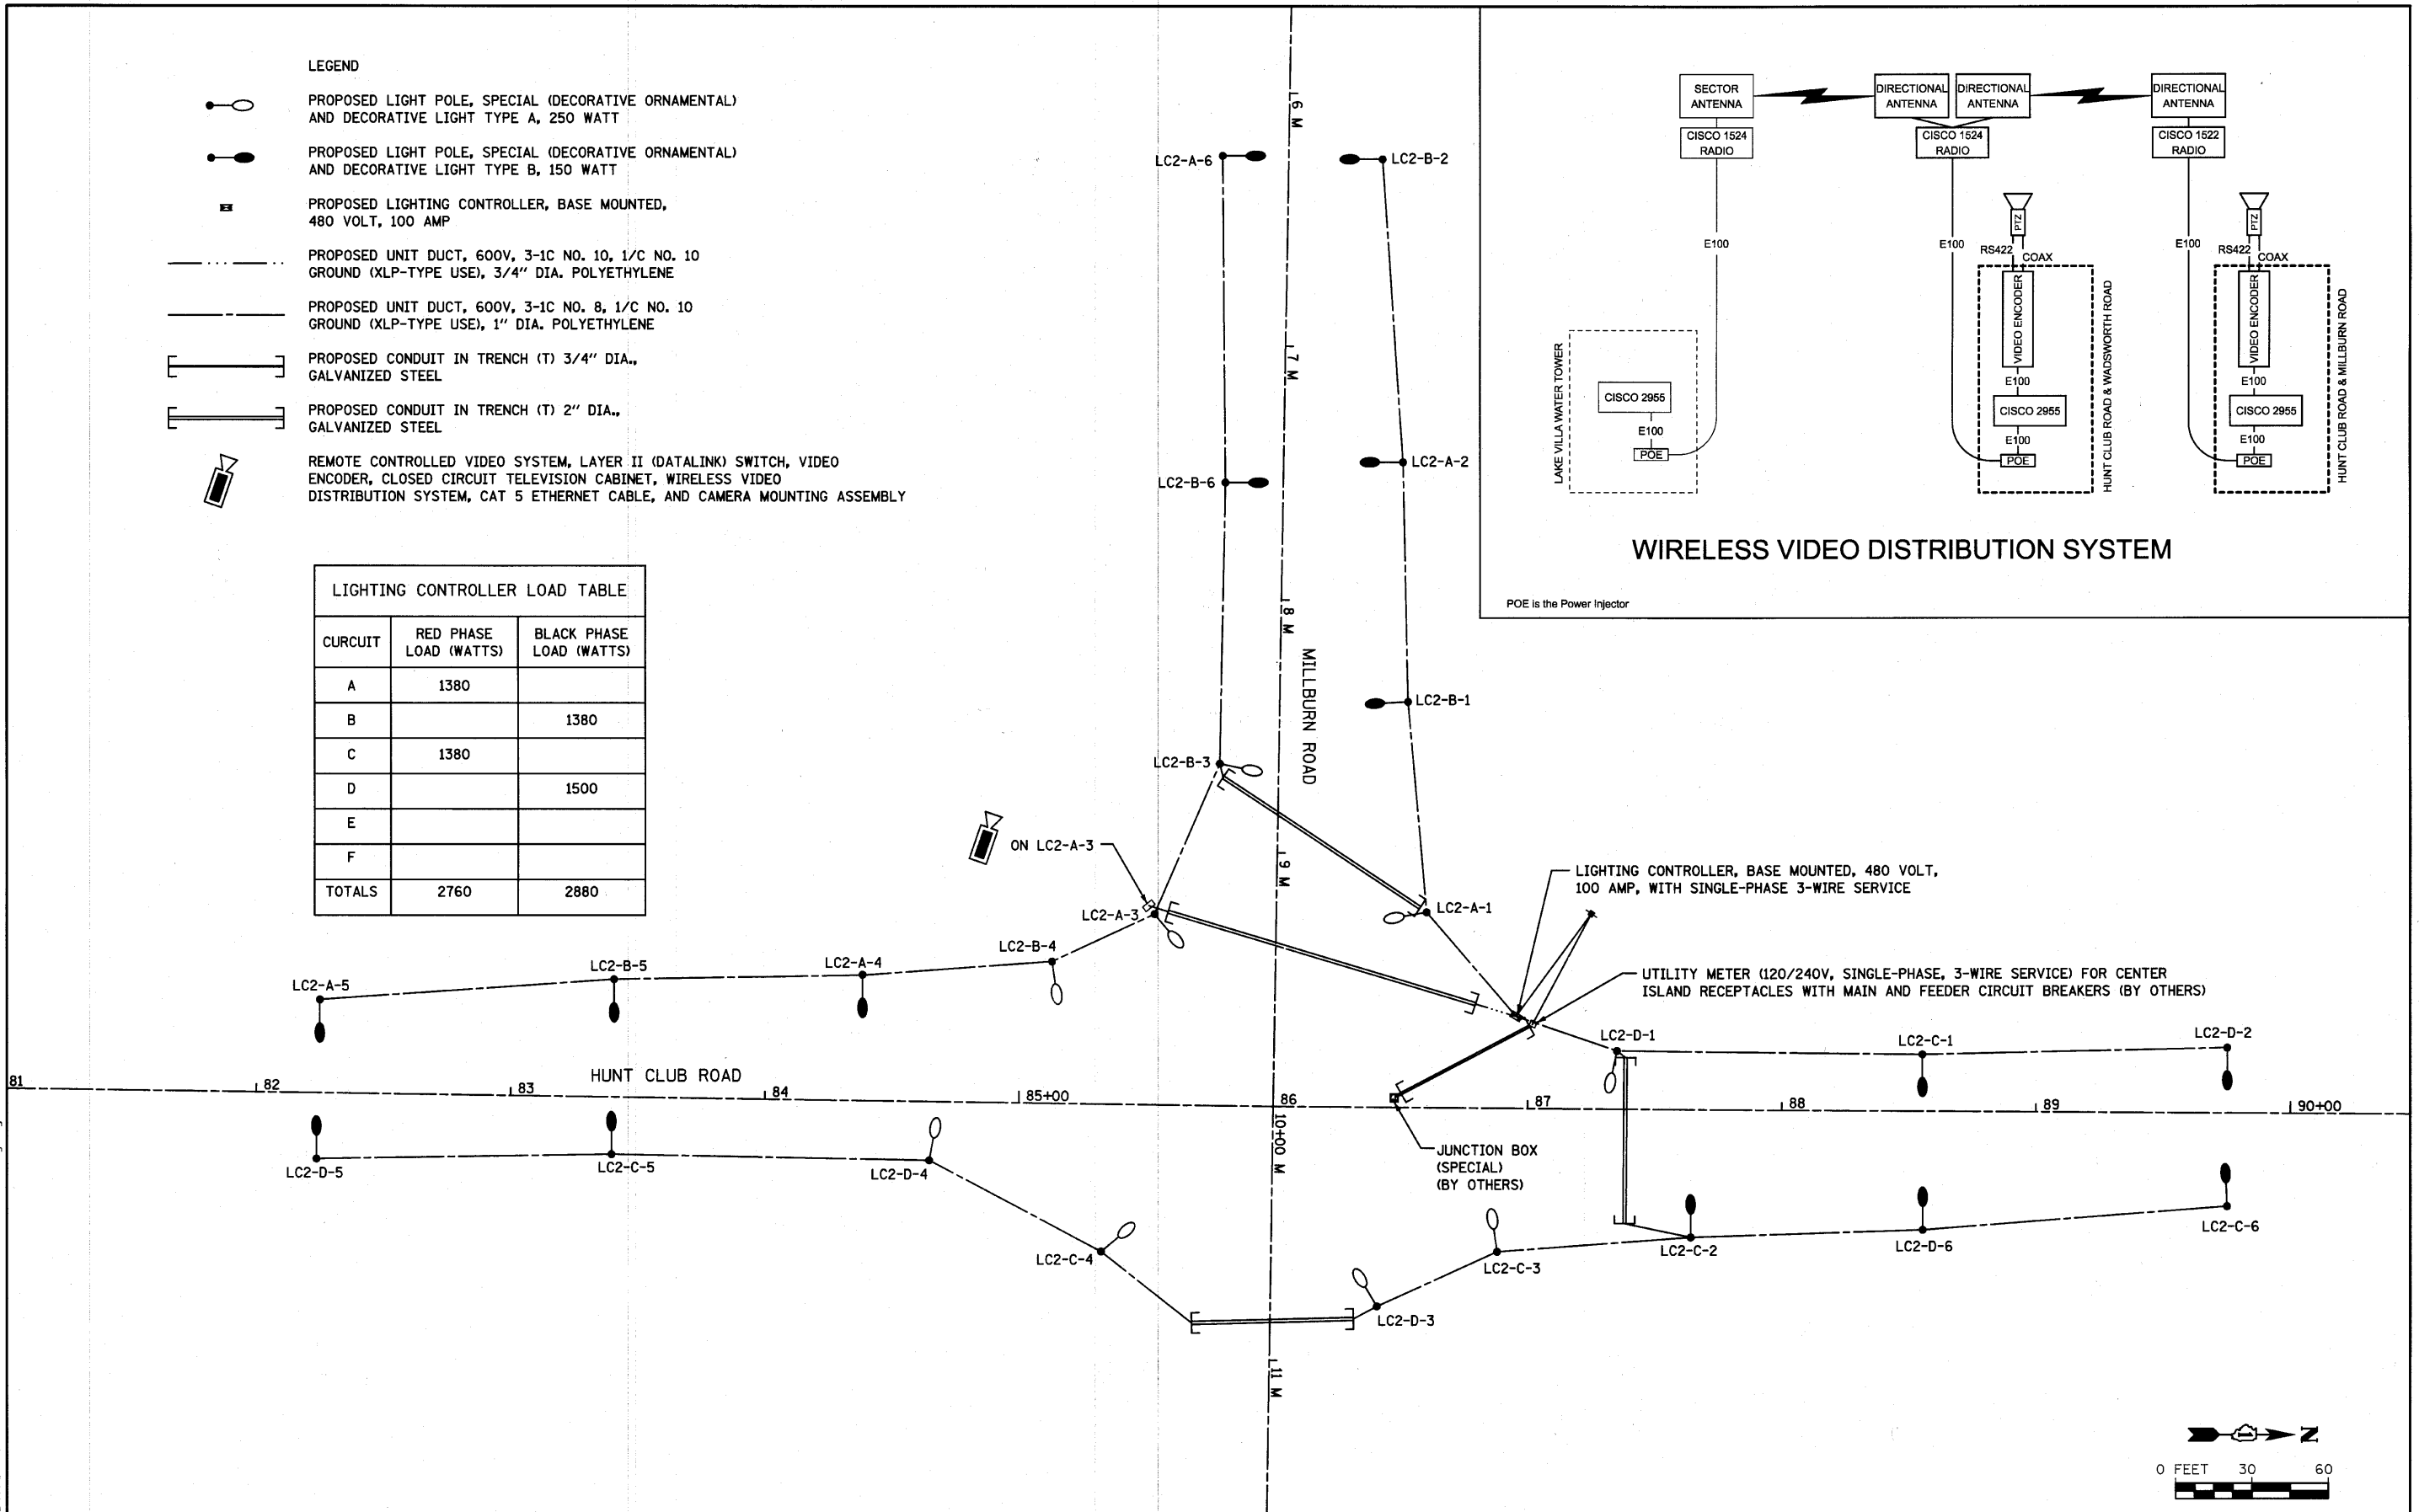



LEGEND

-  PROPOSED LIGHT POLE, SPECIAL (DECORATIVE ORNAMENTAL) AND DECORATIVE LIGHT TYPE A, 250 WATT
-  PROPOSED LIGHT POLE, SPECIAL (DECORATIVE ORNAMENTAL) AND DECORATIVE LIGHT TYPE B, 150 WATT
-  PROPOSED LIGHTING CONTROLLER, BASE MOUNTED, 480 VOLT, 100 AMP
-  PROPOSED UNIT DUCT, 600V, 3-1C NO. 10, 1/C NO. 10 GROUND (XLP-TYPE USE), 3/4" DIA. POLYETHYLENE
-  PROPOSED UNIT DUCT, 600V, 3-1C NO. 8, 1/C NO. 10 GROUND (XLP-TYPE USE), 1" DIA. POLYETHYLENE
-  PROPOSED CONDUIT IN TRENCH (T) 3/4" DIA., GALVANIZED STEEL
-  PROPOSED CONDUIT IN TRENCH (T) 2" DIA., GALVANIZED STEEL
-  REMOTE CONTROLLED VIDEO SYSTEM, LAYER II (DATALINK) SWITCH, VIDEO ENCODER, CLOSED CIRCUIT TELEVISION CABINET, WIRELESS VIDEO DISTRIBUTION SYSTEM, CAT 5 ETHERNET CABLE, AND CAMERA MOUNTING ASSEMBLY

LIGHTING CONTROLLER LOAD TABLE		
CURCUIT	RED PHASE LOAD (WATTS)	BLACK PHASE LOAD (WATTS)
A	1380	
B		1380
C	1380	
D		1500
E		
F		
TOTALS	2760	2880



FILE NAME = S:\JUL\1980-1999\1982\082\Micros\Plan Sheets\01-shr-light.dgn

	1170 SOUTH HOUBOLT ROAD JOLIET, ILLINOIS 60431 (815) 744-4200	USER NAME = amenda.j	DESIGNED - DRAWN - CHECKED - DATE -	REVISED - LCDOT - 05/17/10 REVISED - SAI - 08/03/10 REVISED - REVISED -	<b>STATE OF ILLINOIS DEPARTMENT OF TRANSPORTATION</b>	<b>MILLBURN SINGLE-LINE DIAGRAM AND WIRELESS DETAIL</b>	F.A. RTE. 2661	SECTION 02-00076-13-CH	COUNTY LAKE	TOTAL SHEETS 177	SHEET NO. 80
	SCALE: AS SHOWN    SHEET NO. OF SHEETS    STA. TO STA.						CONTRACT NO. 63457 FED. ROAD DIST. NO. : ILLINOIS FED. AID PROJECT				