




PROPOSED LIGHTING CONTROLLER AND UTILITY PEDESTAL
(N.T.S.)

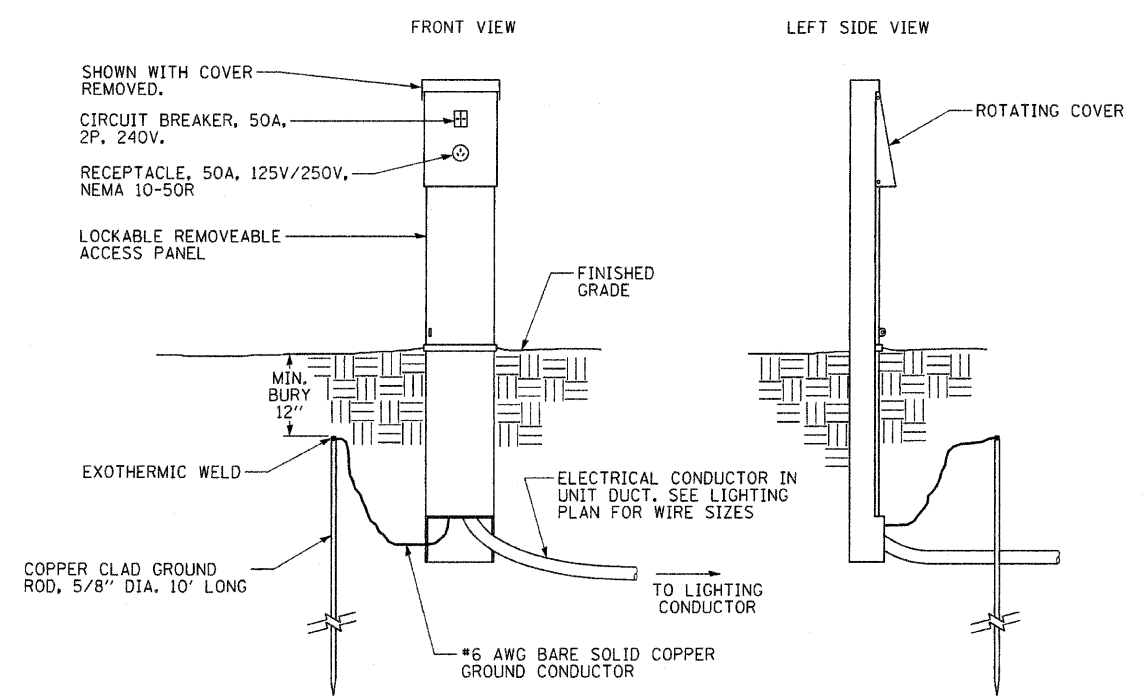


POWER PEDESTAL DETAIL
(TYP. OF 4, SEE LIGHTING LAYOUT PLAN)

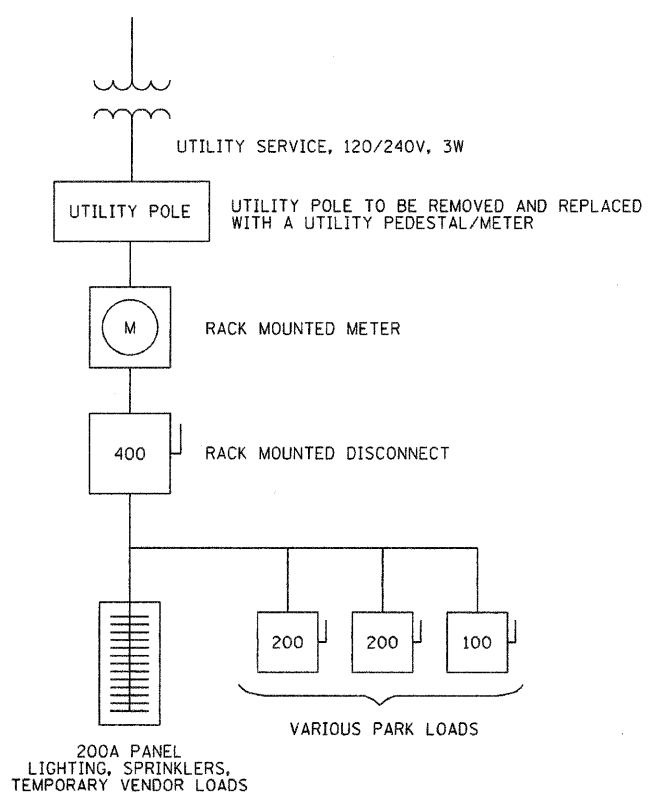

EXISTING ONE LINE

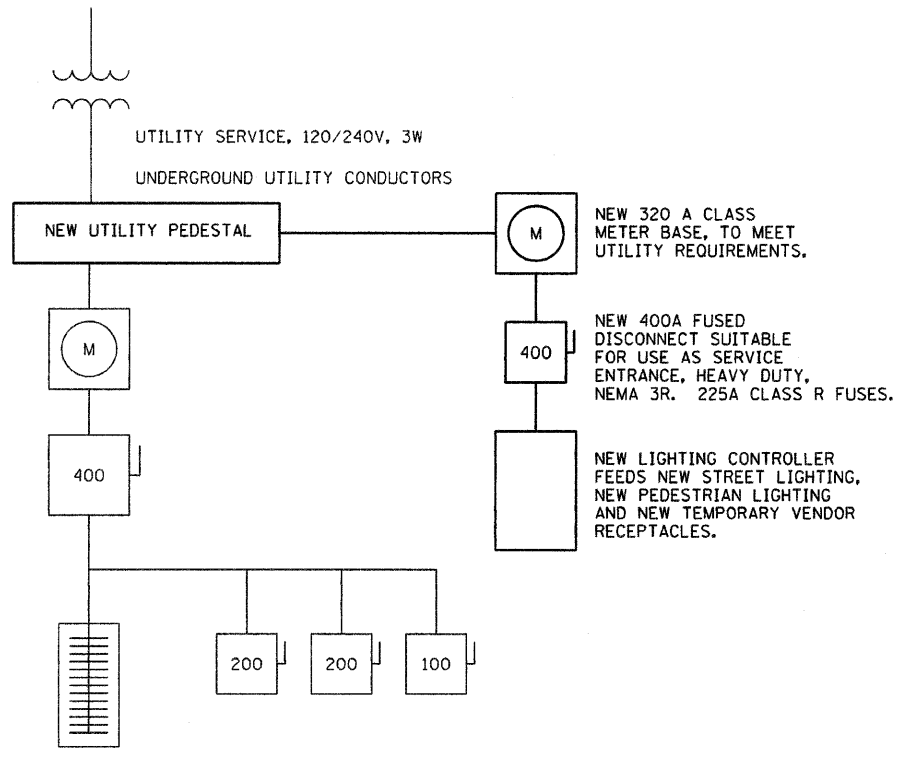

NEW ONE LINE
(NEW EQUIPMENT IN BOLD)

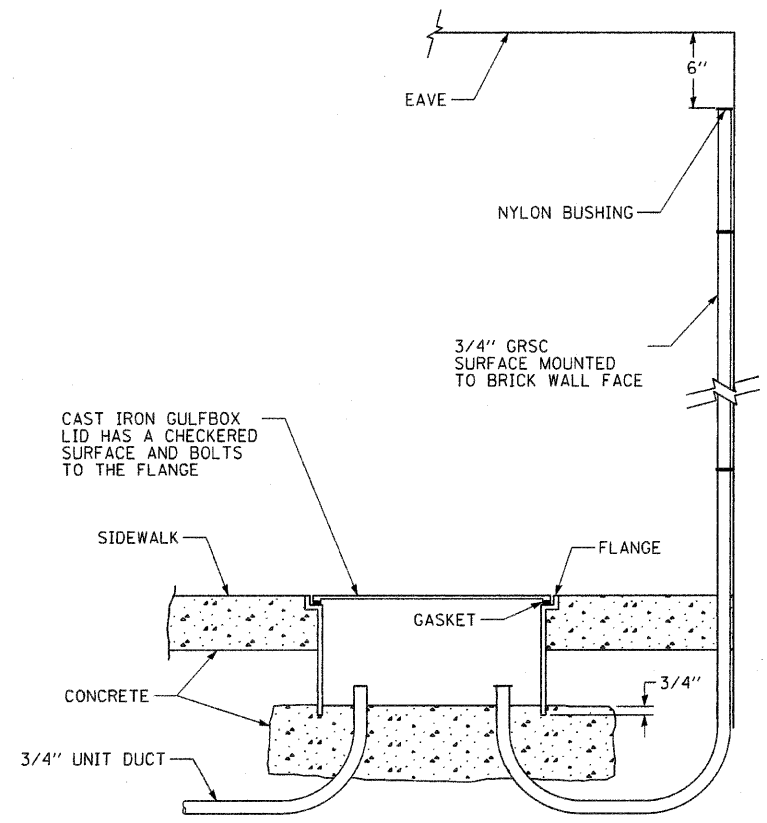

SIDEWALK GULFBBOX DETAIL



EXPIRES: 11/30/2011

Thomas Memminger
THOMAS MEMMINGER
ELECTRICAL ENGINEER
8/11/2010
DATE

FILE NAME = #FILEA#	USER NAME = #USER#	DESIGNED - TM	REVISED -	STATE OF ILLINOIS DEPARTMENT OF TRANSPORTATION	MISCELLANEOUS ELECTRICAL DETAILS B			F.A. RTE.	SECTION	COUNTY	TOTAL SHEETS	SHEET NO.
	PLOT SCALE = #SCALE#	DRAWN - RAH	REVISED -		N/A	05-00017-00-FP	SCHUYLER	49	30 A			
	PLOT DATE = 8/11/2010	CHECKED - TM	REVISED -		SCALE: N.T.S.	SHEET NO. 30B OF 49 SHEETS	STA.	TO STA.	FED. ROAD DIST. NO.	ILLINOIS FED. AID PROJECT	CONTRACT NO. 93541	
		DATE -	REVISED -									