


F.A.P. RTE.	SECTION	COUNTY	TOTAL SHEETS	SHEET NO.
330	465 VB-R-1	COOK	103	23
STA.		TO STA.		
FED. ROAD DIST. NO. 1		ILLINOIS FED. AID PROJECT		
CONTRACT NO. 60407				

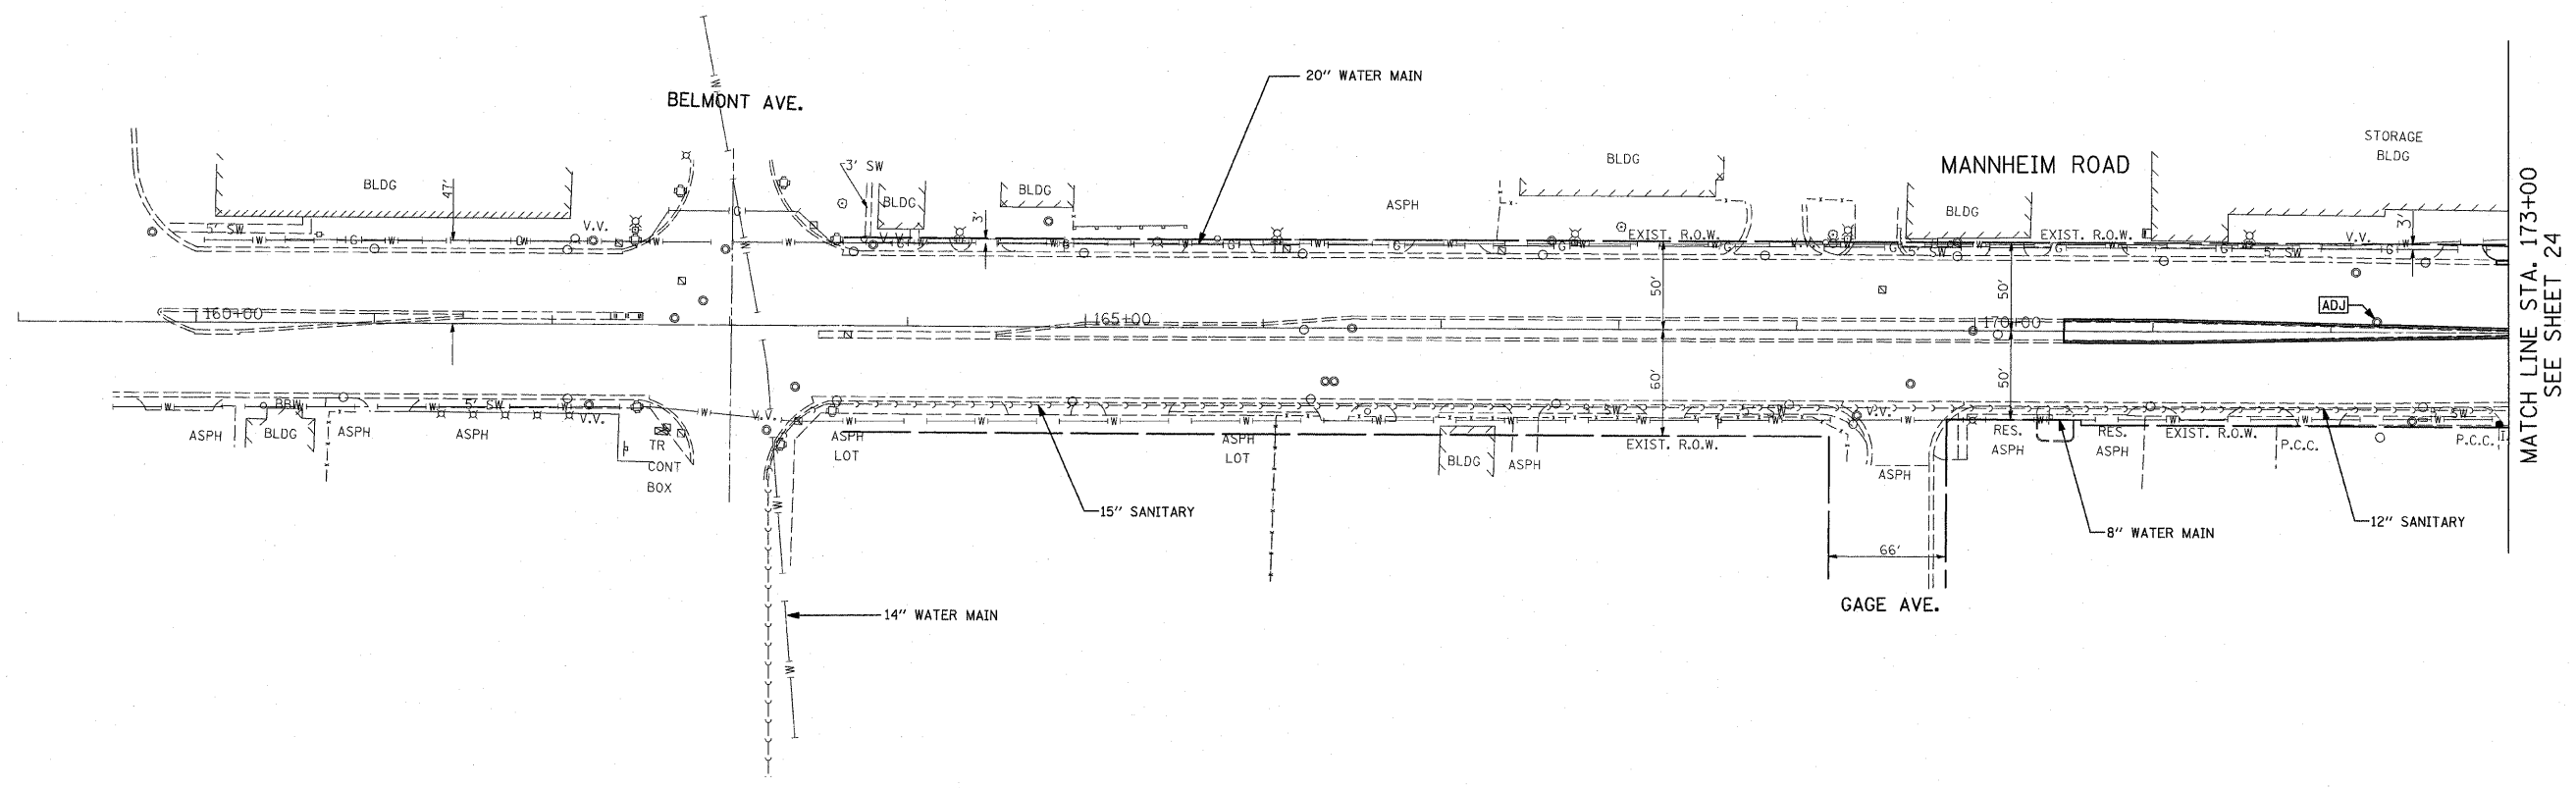

MATCH LINE STA. 173+00
SEE SHEET 24

L:\WORK\63346\cadd\drawings\Roadway\23drain.dgn
7/8/2009

UT-01


REVISIONS	
NAME	DATE

ILLINOIS DEPARTMENT OF TRANSPORTATION
FAP 330 US 12/45 (MANNHEIM RD.) OVER
S00 LINE RR & FRANKLIN AVE.

DRAINAGE AND UTILITY PLAN
STA. 159+00 TO STA. 173+00

SCALE: 1"=50'
DATE: JULY 8, 2009

 DRAWN BY: CJO
CHECKED BY: PWK



EARTH TECH | AECOM