



F.A.P. RTE.	SECTION	COUNTY	TOTAL SHEETS	SHEET NO.
330	465 VB-R-1	COOK	103	24
STA.		TO STA.		
FED. ROAD DIST. NO. 1		ILLINOIS	FED. AID PROJECT	
CONTRACT NO. 60407				

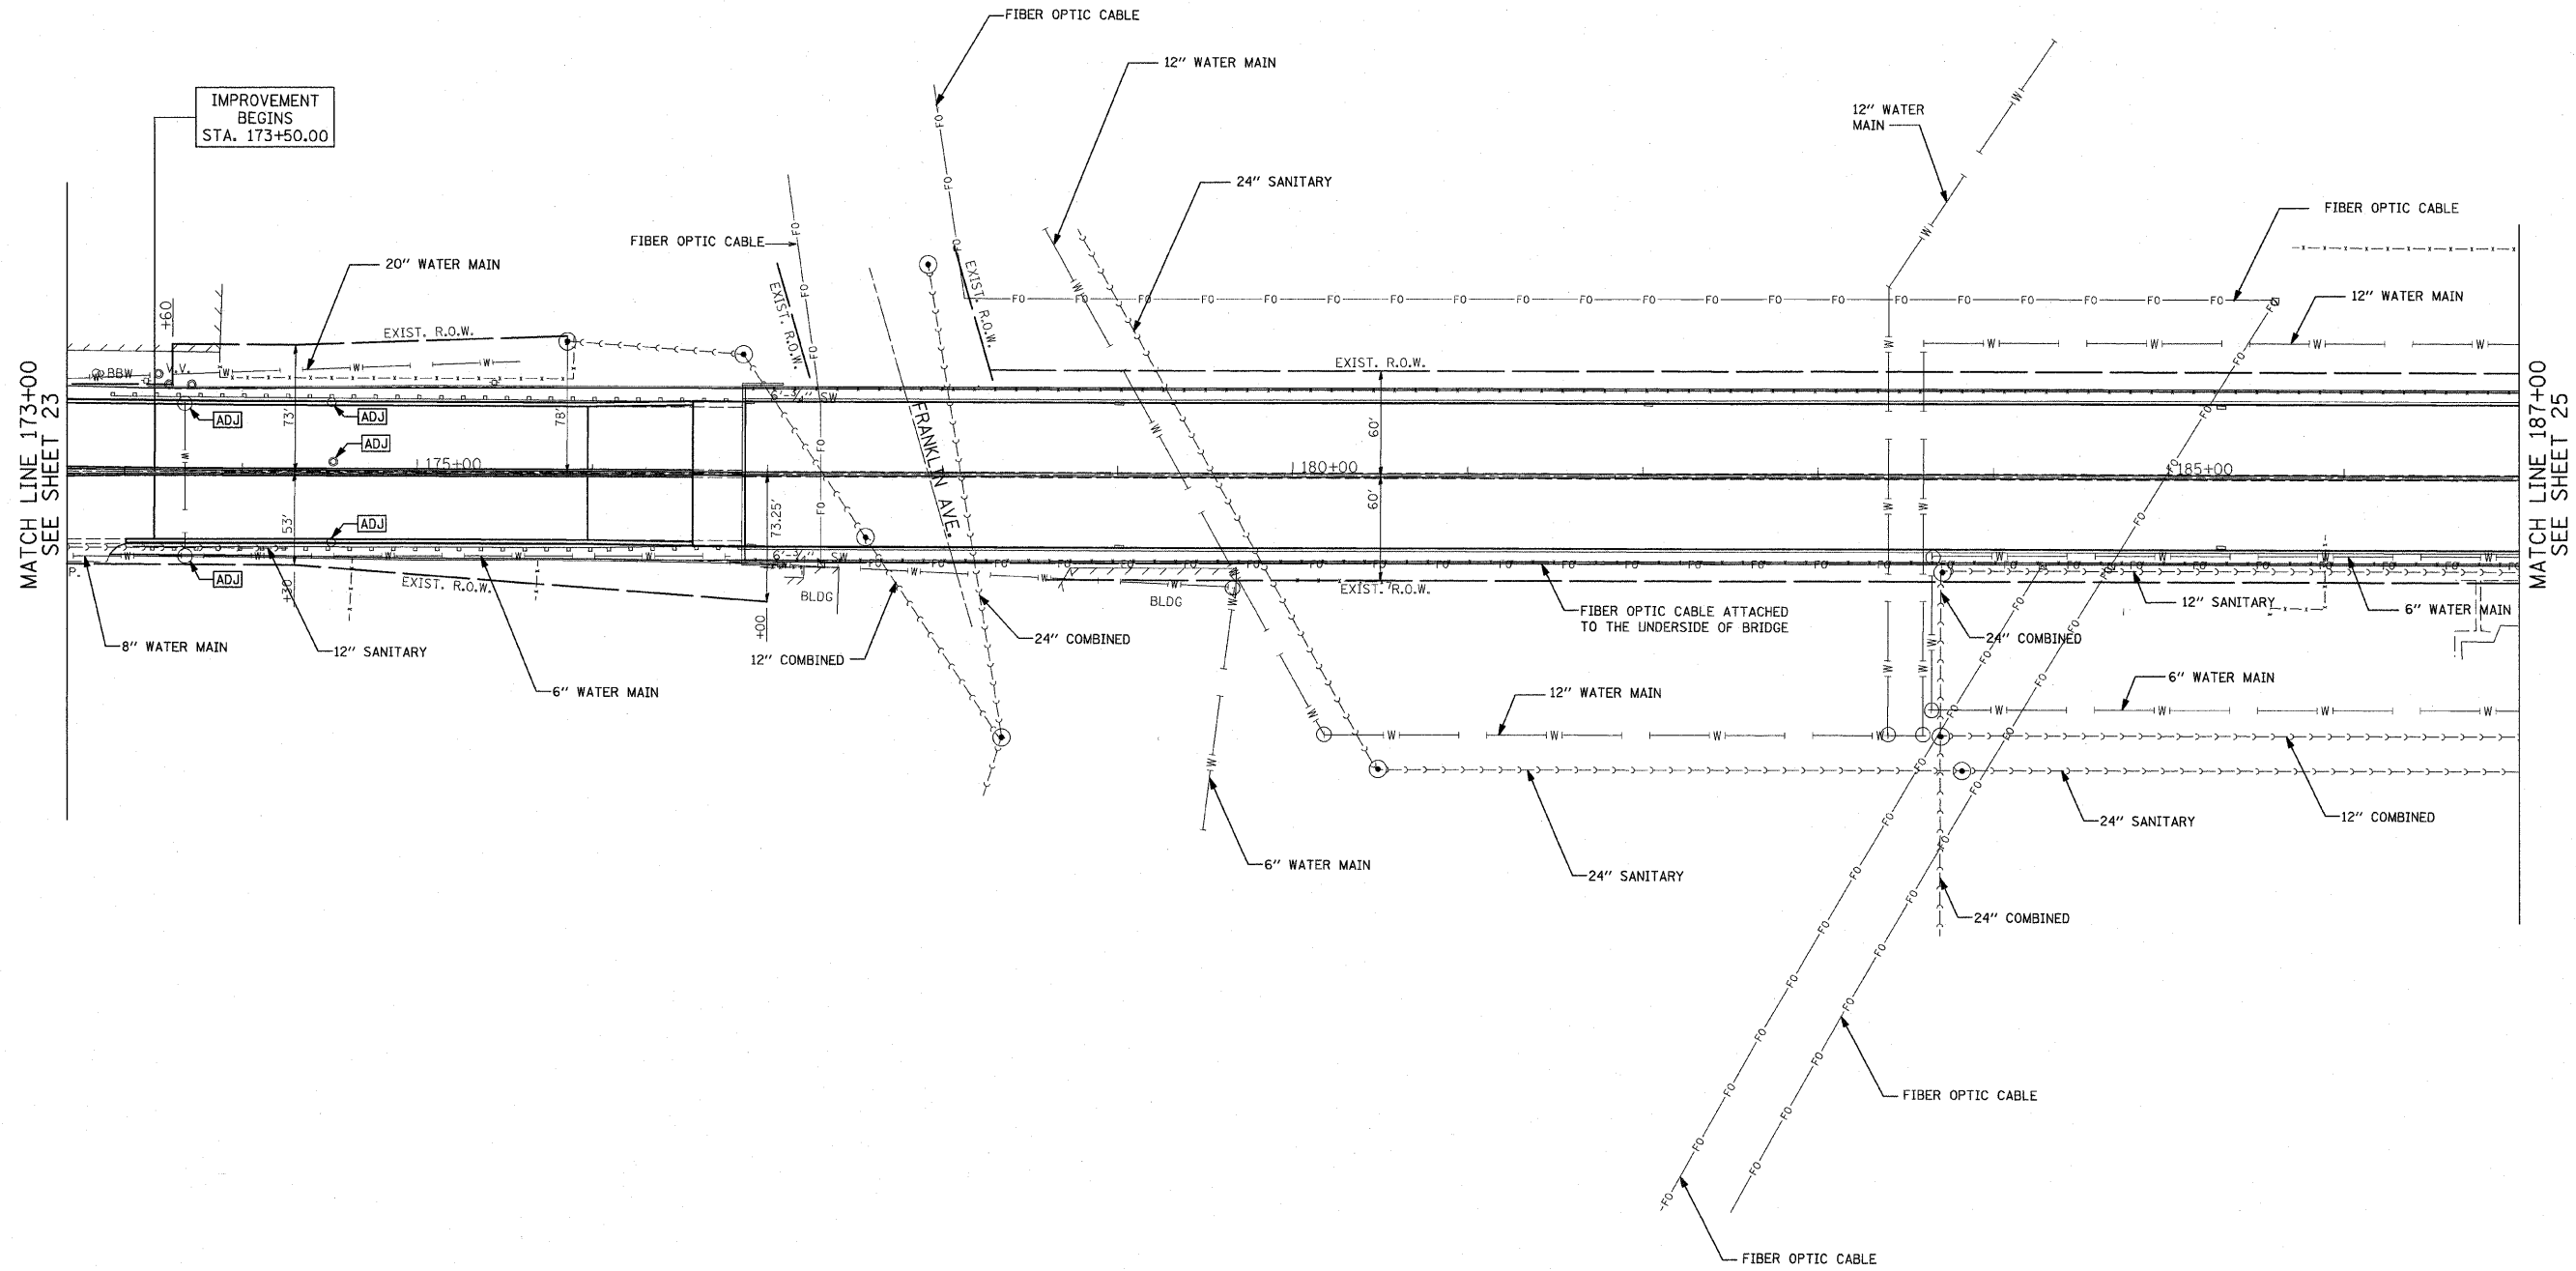

MATCH LINE 173+00
SEE SHEET 23

MATCH LINE 187+00
SEE SHEET 25

 L:\WORK\53346\cadd\drawings\Roadway\24dra-ru.dgn
7/8/2009



EARTH TECH | AECOM

REVISIONS	
NAME	DATE

ILLINOIS DEPARTMENT OF TRANSPORTATION
FAP 330 US 12/45 (MANNHEIM RD.) OVER
S00 LINE RR & FRANKLIN AVE.

DRAINAGE AND UTILITY PLAN
STA. 173+00 TO STA. 187+00

SCALE: 1"=50'
DATE: JULY 8, 2009

DRAWN BY: CJO
CHECKED BY: PWK

UT-02