


REF-TOPOID  
REF-PPID

F.A.P. RTE.	SECTION	COUNTY	TOTAL SHEETS	SHEET NO.
332/876	2002-113R	WILL	242	1190
STA. 59+950		TO STA. 60+295		
FED. ROAD DIST. NO. 1		ILLINOIS FED. AID PROJECT		

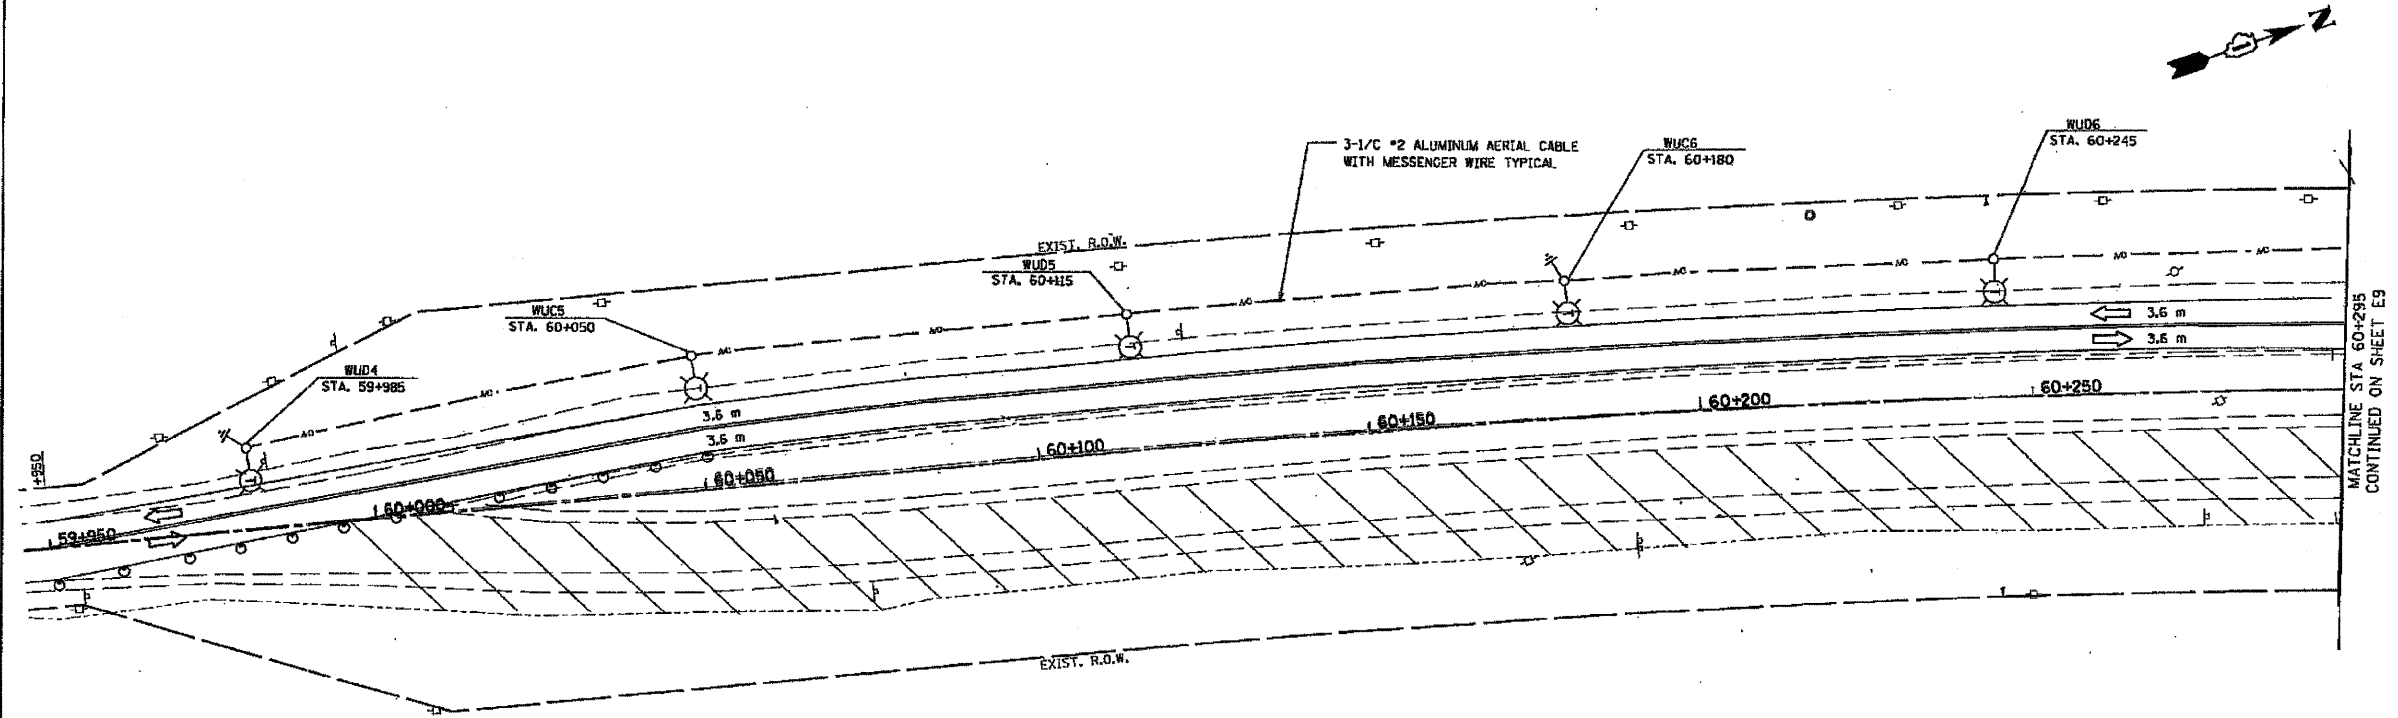

MATCHLINE STA 60+295  
CONTINUED ON SHEET E9



*Peter B. Leonard 7/9/09*  
*Exp. 11/30/09*

- NOTES:**
1. ALL TEMPORARY LIGHT POLES SHALL HAVE A MINIMUM SETBACK OF 9M FROM EDGE OF TRAVELED PAVEMENT UNLESS NOTED OTHERWISE.
  2. INSTALL AND ENERGIZE TEMPORARY LIGHTING SYSTEM PRIOR TO CLOSURE OF NORTH BOUND LANES.

E8

REVISIONS	
NAME	DATE

ILLINOIS DEPARTMENT OF TRANSPORTATION  
IL. RTE. 394 AT GOODENOW  
STAGE 3  
LIGHTING PLAN

**HOH ASSOCIATES, INC.**  
2660.05  
HCH CAD FILE No. EB.DGN  
PLOT SCALE 1 = 1

SCALE 1:500  
DATE 12-6-2005  
DRAWN BY MEK  
CHECKED BY RER