




F.A. RTE.	SECTION	COUNTY	TOTAL SHEETS	SHEET NO.
350	00-00242-00-CH	COOK	129	109
STA.		TO STA.		
FED. ROAD DIST. NO.		ILLINOIS	FED. AID PROJECT	

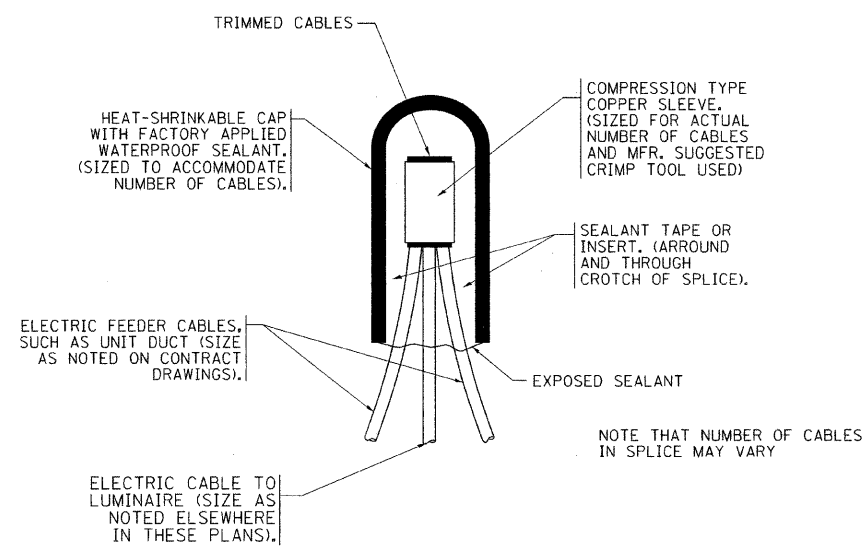

TYPICAL SPLICE DETAIL  
N.T.S.

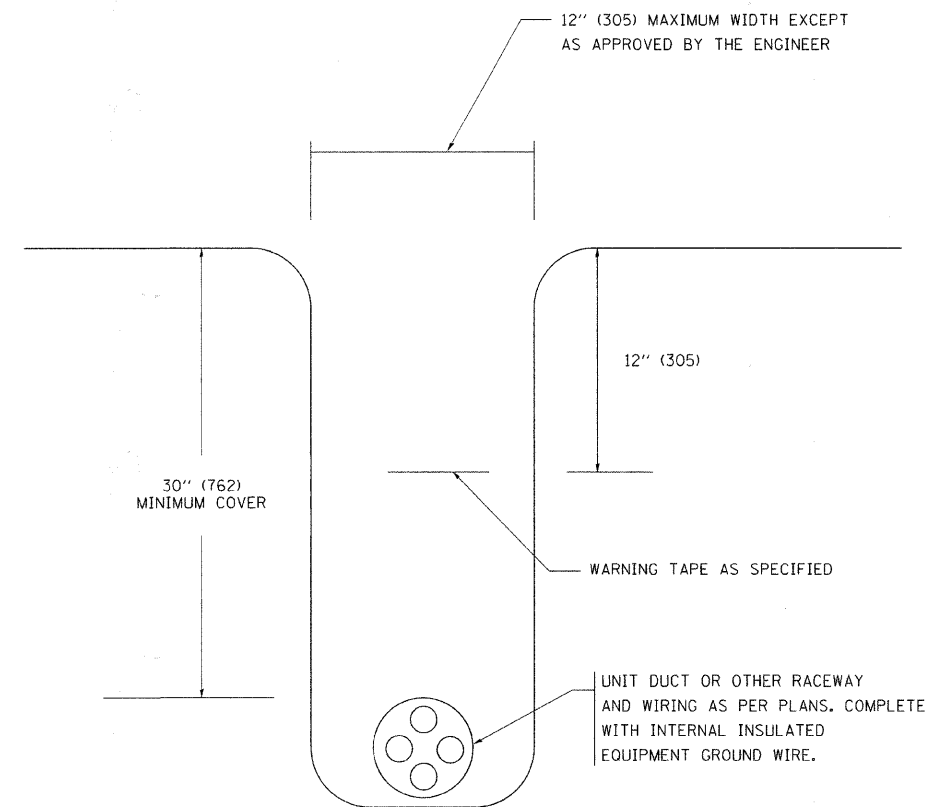

TYPICAL WIRING IN TRENCH DETAIL  
N.T.S.

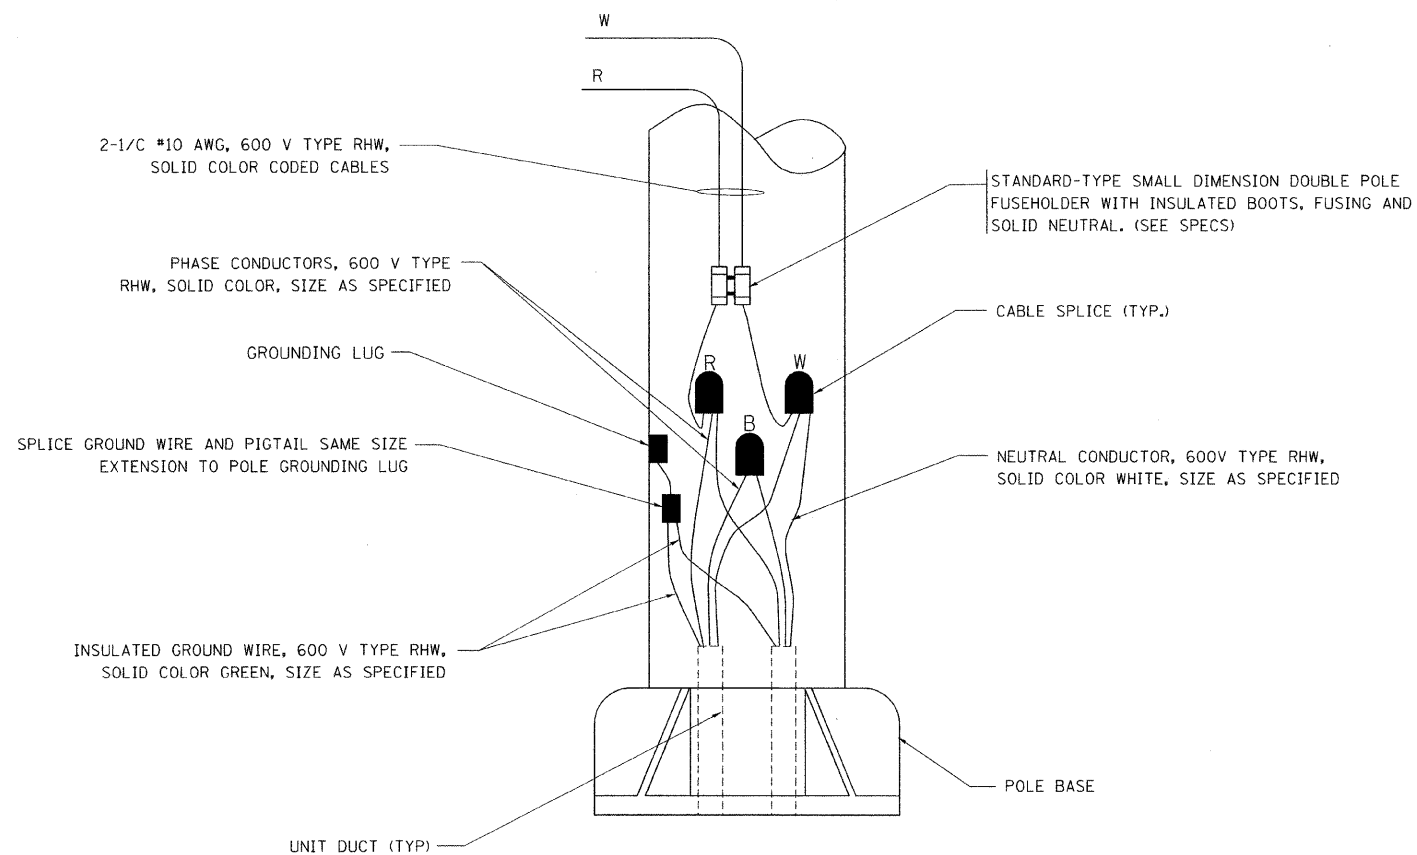

POLE WIRING DETAIL  
N.T.S.

PLOT DATE = 1/18/2007  
FILE NAME = c:\projects\11stas\11stas782.dgn  
PLOT SCALE = 50.000 / 1.  
USER NAME = geglennob

REVISIONS	
NAME	DATE

ILLINOIS DEPARTMENT OF TRANSPORTATION  
  
MISC. ELECTRICAL DETAILS  
SHEET A  
  
SCALE: VERT.  
HORIZ.  
DATE: 1/18/2007  
  
DRAWN BY  
CHECKED BY  
BE-702  
REVISION DATE: 01/01/07