
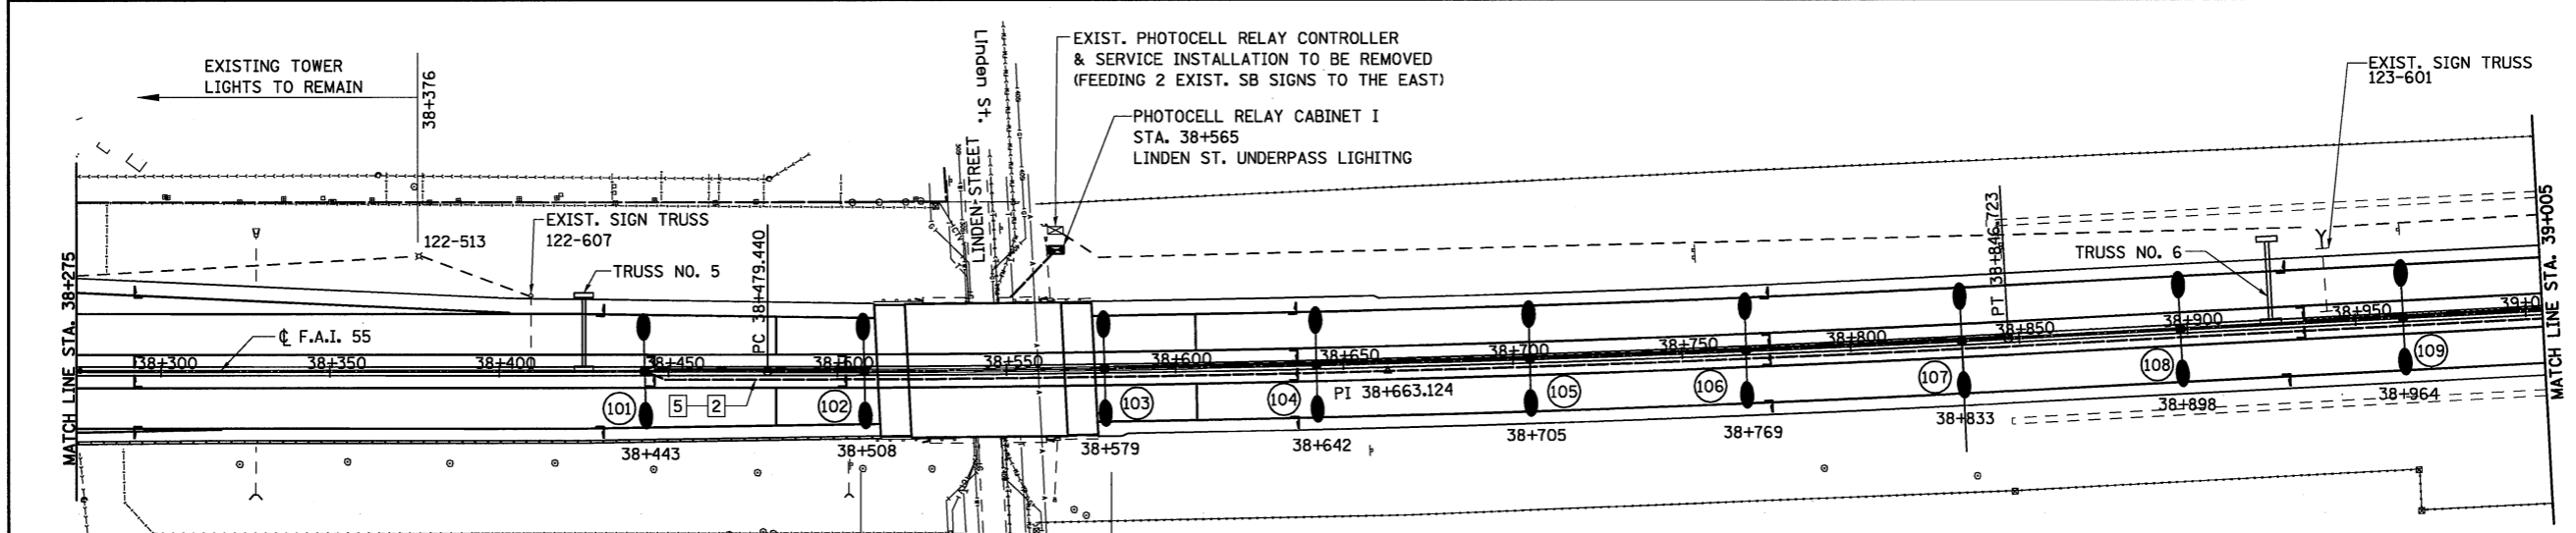



F.A.I. RTE.	SECTION	COUNTY	TOTAL SHEETS	SHEET NO.
55	*	MCLEAN	310	107
FED. ROAD DIST. NO. ILLINOIS		FED. AID PROJECT		
(57-4)R, HBY, HBR, (57-4VB)DM		CONTRACT #70757		

LEGEND

1	CONDUIT PUSHED, 50 mm GALVANIZED STEEL	UHH	UNDERPASS LUMINAIRE, 150W HPS
2	2 *6XLP, 1 *6XLP-G	⊗	JUNCTION BOX, EXISTING
3	UNIT DUCT, 2 *6XLP, 1 *6XLP-G, 25 P	⊠	JUNCTION BOX, PROPOSED, SIZE AS NOTED
4	CONDUIT ATTACHED TO STRUCTURE, 50 mm DIA, GALVANIZED STEEL	⊞	LIGHTING CONTROLLER, PROPOSED
5	CONDUIT EMBEDDED IN STRUCTURE, 50 mm PVC	●—●	PROP. LIGHT POLE, TWIN DAVIT/LUMINAIRES
6	CONDUIT ATTACHED TO STRUCTURE 20 mm DIA., GALVANIZED STEEL	●—○	PROP. LIGHT POLE, TWIN DAVIT/LUMINAIRES INSTALLED ON EXISTING FOUNDATION
7	2 *10XLP, 1 *10XLP-G	—○—	PROPOSED CONDUIT OR UNIT DUCT
		⊗	EXISTING LIGHTPOLE AND FOUNDATION TO BE REMOVED
		⊗	EXISTING LIGHTING UNIT

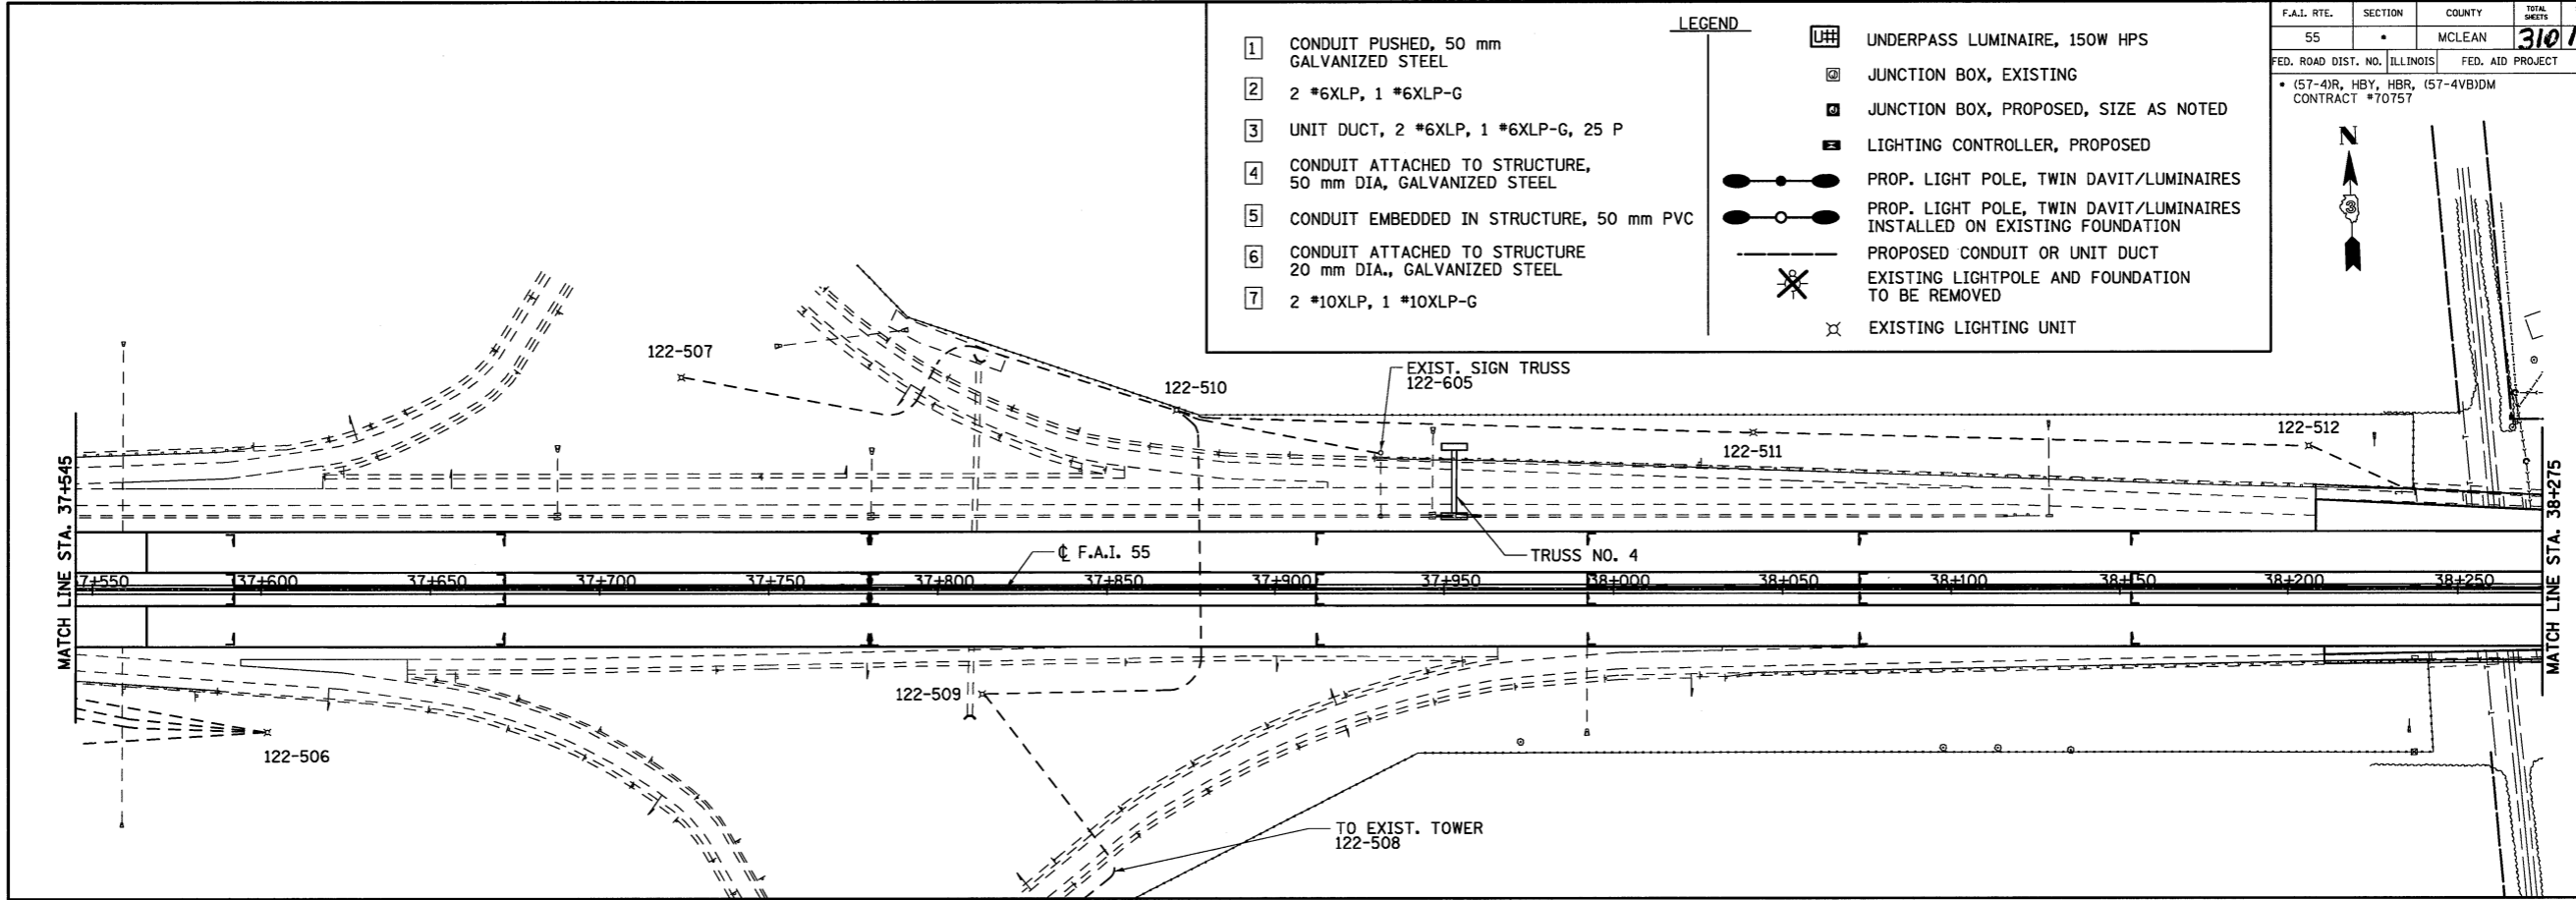

NOTE: SEE DETAIL FOR "PROPOSED UNDERPASS LIGHTING, LINDEN ST." FOR UNDERPASS LIGHTING DETAILS

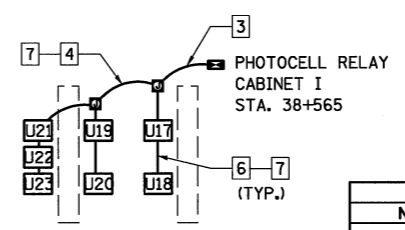

REVISIONS	
NAME	DATE

ILLINOIS DEPARTMENT OF TRANSPORTATION
 F.A.I. 55
 SECTION (57-4)R, HBY, HBR, (57-4VB)DM
 MCLEAN COUNTY
LIGHTING PLAN
 I-55



JOB NO.	94S2063
DATE	10/6/2009

DATE	04/10/02
DRAWN	JRH
REVIEWED	DLH
DATE	03/05/04
DATE	03/28/04