
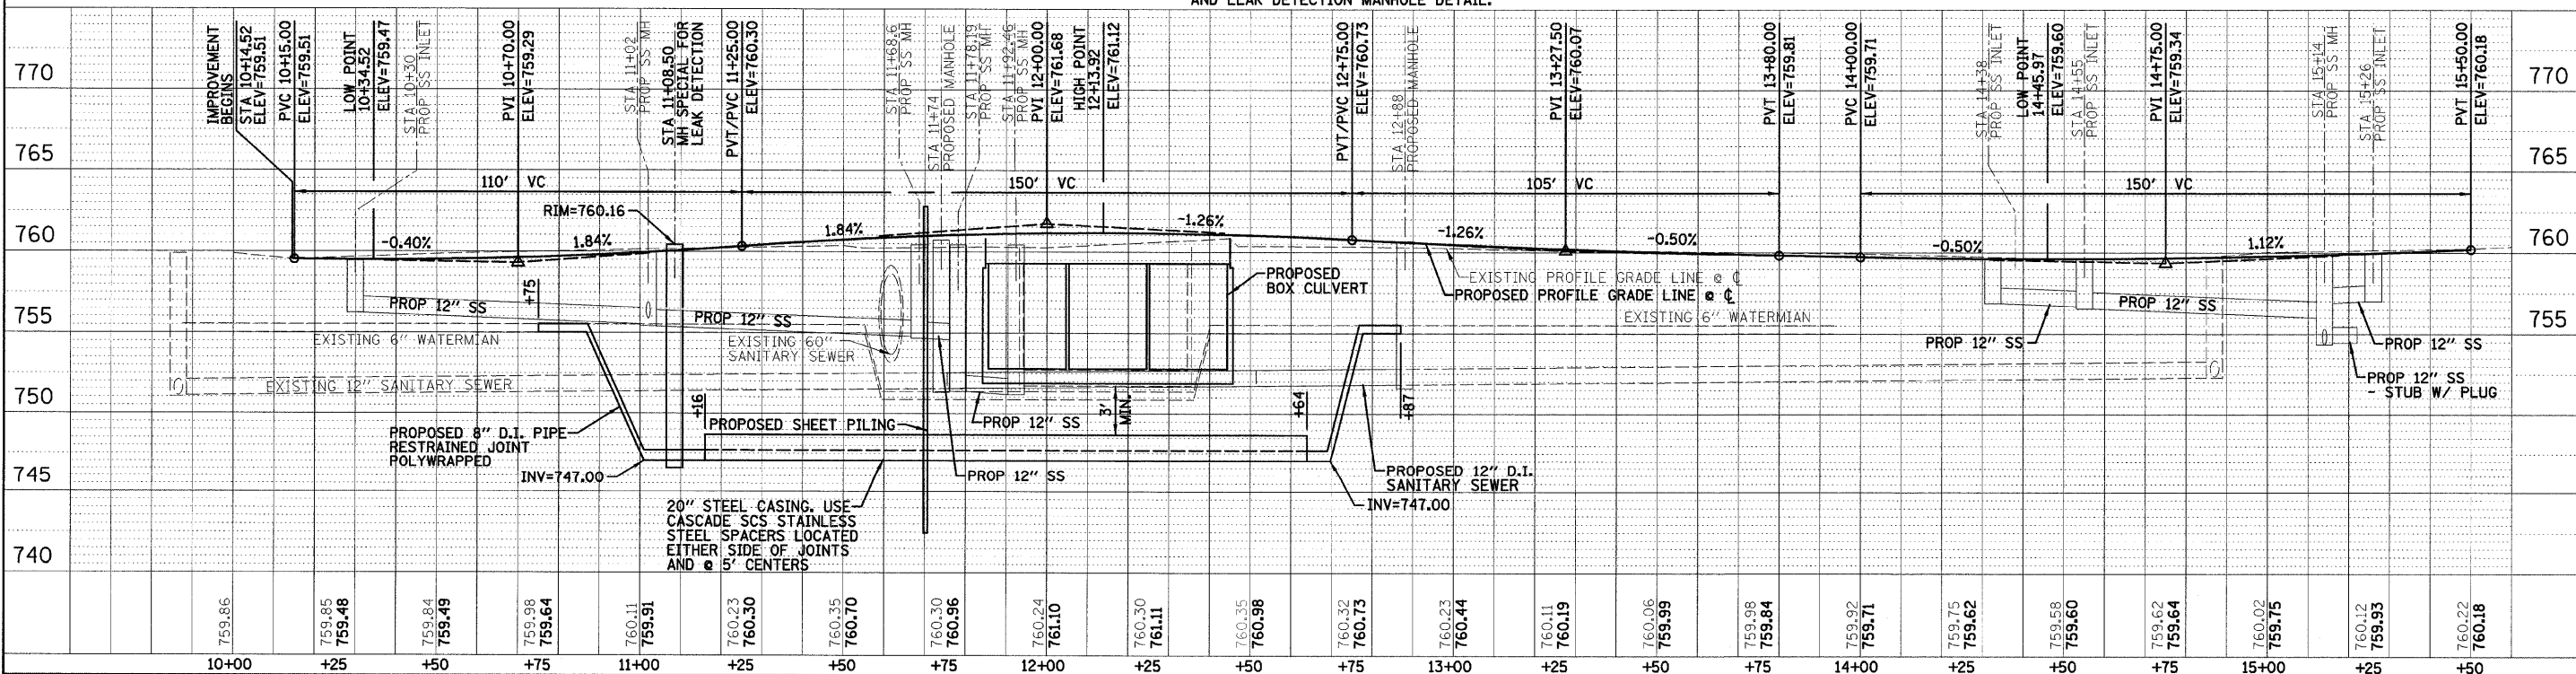
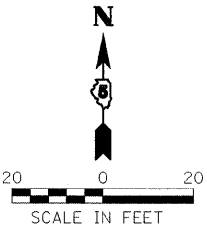


PLAN	DATE
SURVEYED	BY
PLOTTED	DATE
CHECKED	DATE
DATE	DATE

PROF. I.F.	DATE
SURVEYED	BY
PLOTTED	DATE
CHECKED	DATE
DATE	DATE

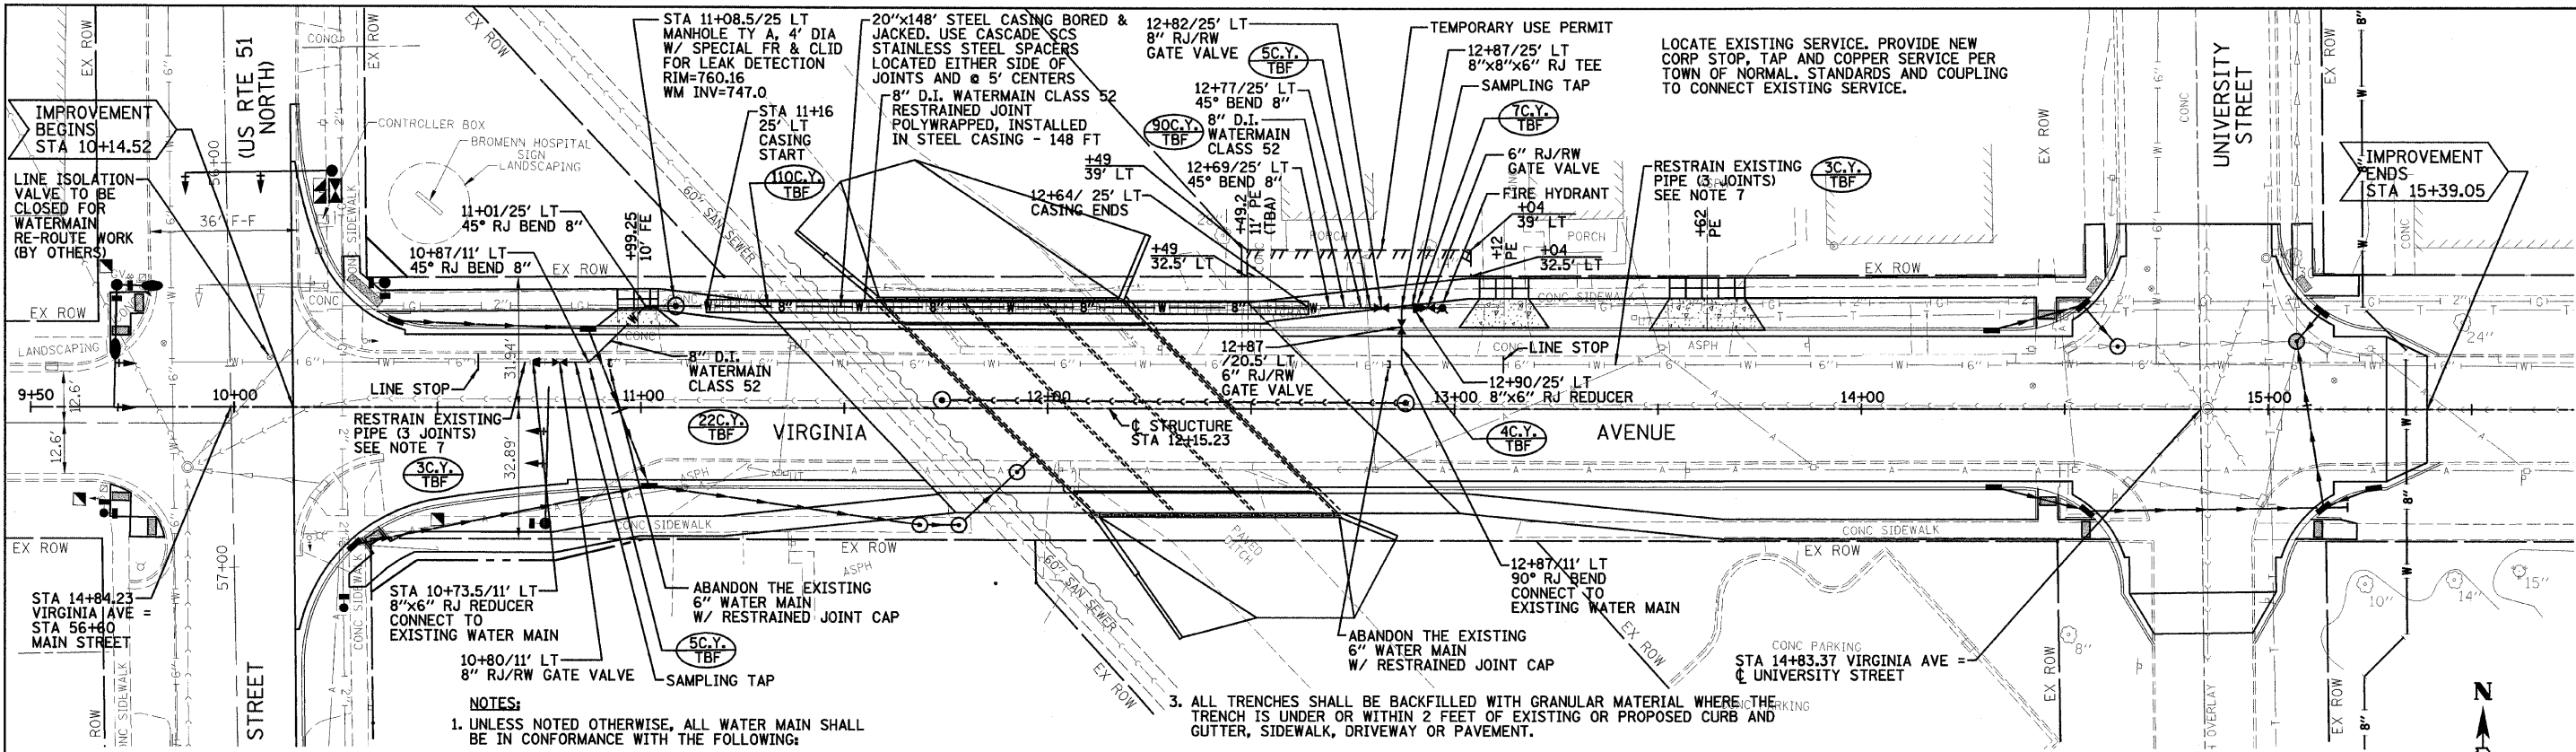

DESIGNED - JDA	REVISED -	TOWN OF NORMAL		VIRGINIA AVENUE WATER MAIN PLAN AND PROFILE					VIRGINIA AVENUE OVER SUGAR CREEK SECTION 04-00226-00-BR MCLEAN, COUNTY					F.A.U.	SECTION	COUNTY	TOTAL SHEETS	SHEET NO.		
DRAWN - DRR	REVISED -			SCALE: 1"=20'					SHEET NO. 13 OF 52 SHEETS					6356	04-00226-00-BR	MCLEAN	52	13		
CHECKED - PJM	REVISED -			DATE - 07/22/09					STA. 10+14.52 TO STA. 15+39.05					S.N. 057-7834					CONTRACT NO. 91416	
DATE - 07/22/09	REVISED -													FED. ROAD DIST. NO.					ILLINOIS FED. AID PROJECT	

FARNSWORTH GROUP, INC.

CONSULTING ENGINEERS - 2709 MCGRAW DRIVE BLOOMINGTON, ILLINOIS 61704 (309) 663-8435 / (309) 663-1571 FAX

24-6082