

LIGHT REMOVAL NOTES

ALL EXISTING TAXIWAY LIGHTS AND TAXI GUIDANCE SIGNS THAT ARE DESIGNATED FOR REMOVAL WILL BE REMOVED. THE LIGHTS AND THEIR ISOLATING TRANSFORMER WILL BE TURNED OVER TO THE AIRPORT MANAGER. THE LIGHT STAKES/BASES WILL BE REMOVED AND DISPOSED OF OFF THE AIRPORT SITE.


THE HOLE LEFT FROM THE LIGHT REMOVAL WILL BE FILLED IN WITH EARTH MATERIAL AND COMPACTED TO PREVENT FUTURE SETTLEMENT. THE EARTH MATERIAL USED TO FILL THE HOLES WILL BE FURNISHED BY THE CONTRACTOR FROM AN OFF AIRPORT SITE. THE DISTURBED AREAS WILL BE FERTILIZED AND SEEDED IN ACCORDANCE WITH THE SPECIAL PROVISIONS.

THE EXISTING RUNWAY CABLES WILL BE ABANDONED IN PLACE UNLESS IT CONFLICTS WITH THE INSTALLATION OF A PROPOSED LIGHT OR CABLE, THEN IT WILL BE REMOVED AT NO ADDITIONAL COST TO THE CONTRACT.



THE RUNWAY WILL BE CLOSED DURING THE CONSTRUCTION DAY AND OPENED AT THE END OF DAILY CONSTRUCTION. ALL OPEN HOLES AND TRENCHES WILL BE FILLED AT THE END OF THE CONSTRUCTION DAY BEFORE THE RUNWAY IS RE-OPENED. THE EXISTING LIGHTS WILL BE REMOVED AS NEW CABLE AND LIGHTS ARE INSTALLED. AT THE END OF THE CONSTRUCTION DAY THE NEW LIGHTS AND CABLE WILL BE CONNECTED TO THE REMAINING EXISTING LIGHTING CIRCUIT IN ORDER THAT THE LIGHTING CIRCUIT REMAIN OPERATIONAL EACH NIGHT OR DURING NON-CONSTRUCTION PERIODS. THE CONTRACTOR WILL FURNISH JUMPER CABLES OR ADDITIONAL CONNECTOR KITS AS REQUIRED TO PLACE THE LIGHTING CIRCUIT BACK INTO OPERATION. NO ADDITIONAL COMPENSATION WILL BE ALLOWED FOR THIS WORK.

REMOVAL OF THE EXISTING LIGHTS AND ISOLATING TRANSFORMERS WILL BE PAID FOR UNDER ITEMS:

- AR125901 "REMOVE STAKE MOUNTED LIGHT" PER EACH AND
- AR125902 "REMOVE BASE MOUNTED LIGHT" PER EACH.

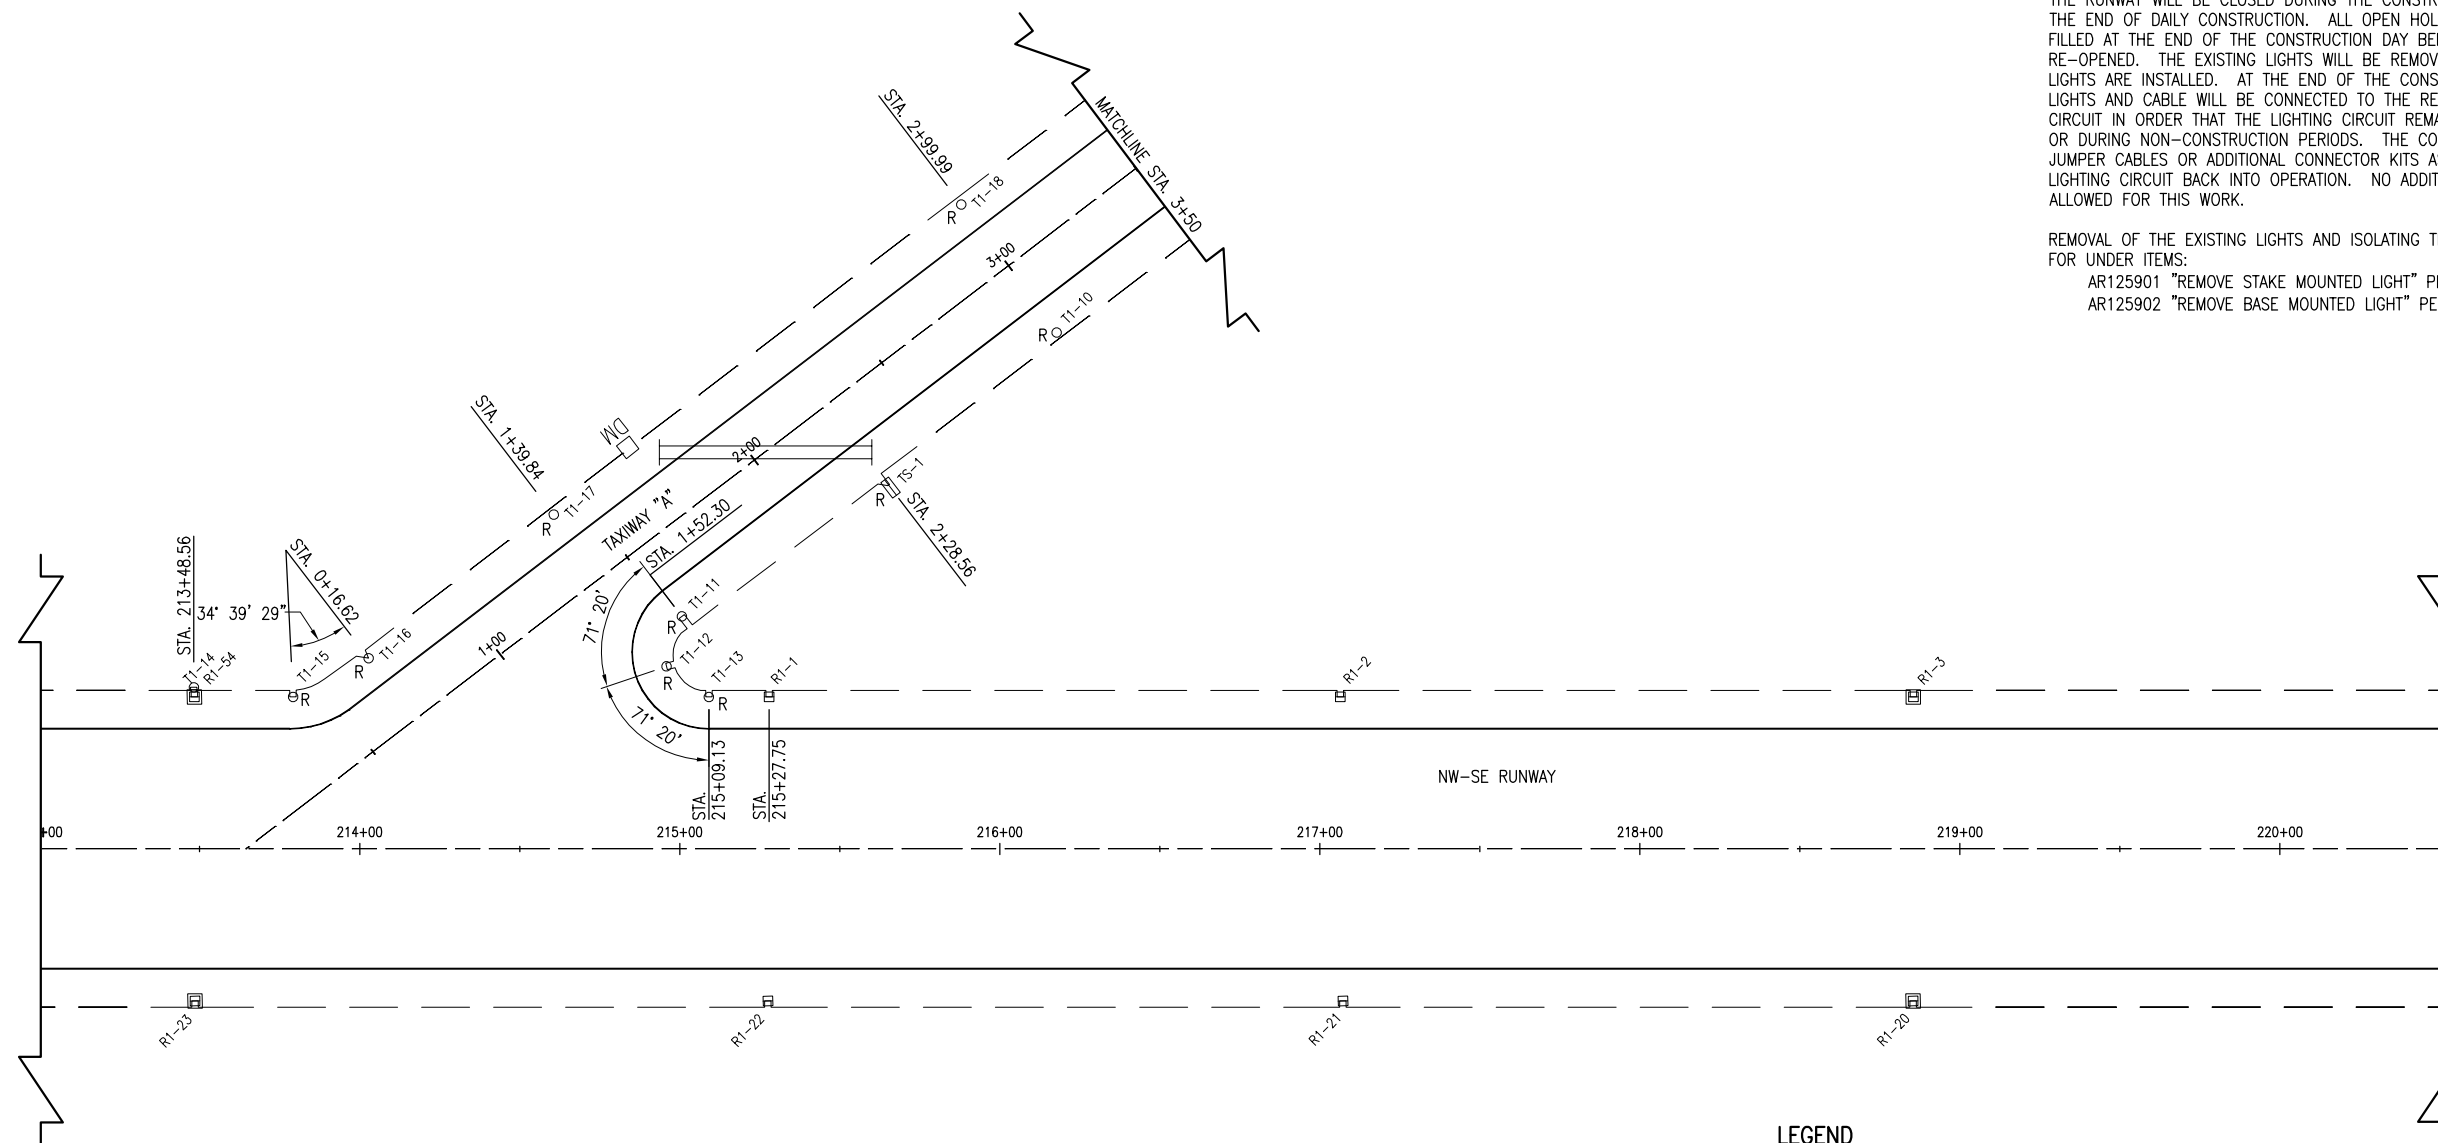

 - LEGEND**
- EXISTING PAVEMENT
 - EXISTING ELECTRICAL DUCT
 - EXISTING ELECTRICAL CABLES (TO REMAIN IN PLACE)
 - EXISTING STAKE MOUNTED RUNWAY LIGHT
 - EXISTING BASE MOUNTED RUNWAY LIGHT
 - EXISTING STAKE MOUNTED TAXIWAY LIGHT (TO BE REMOVED)
 - EXISTING TAXI GUIDANCE SIGN (TO BE REMOVED)
 - EXISTING DUCT MARKER

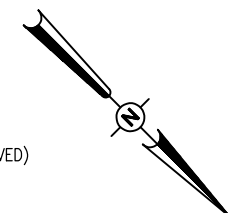


DATE	REVISION	BY

TRI-TOWNSHIP AIRPORT
 SAVANNA, CARROLL COUNTY
 ILLINOIS

IL. PROJ.: SFY-3932 A.I.P. PROJ.: 3-17-091-B15

Hanson Project No. 09A0033D_0800	FILENAME R-141ELE.DWG	DATE 08/24/09	LAYOUT CAH 03/24/09
Scale 1" = 30'	Scale 1" = 30'	Scale 1" = 30'	SCALE 1" = 30'
DATE 08/24/09	DATE 08/24/09	DATE 08/24/09	DATE 08/24/09
REVIEWED CAH	REVIEWED CAH	REVIEWED CAH	REVIEWED CAH
DRAWN BAK	DRAWN BAK	DRAWN BAK	DRAWN BAK
DATE 03/24/09	DATE 03/24/09	DATE 03/24/09	DATE 03/24/09

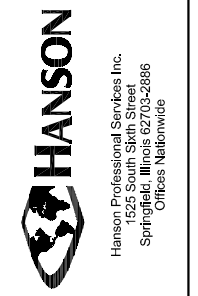

REPLACE MITL SYS.,
 INSTALL APRON LTS
 EXISTING
 ELECTRICAL PLAN
 FOR TAXIWAY "A"