




F.A.J. FILE	SECTION	COUNTY	TOTAL SHEETS	SHEET NO.
1463	1010.1B	COOK	171	71
STA.		TO STA.		
FED. ROAD DIST. NO.	ILLINOIS FED. AID PROJECT			

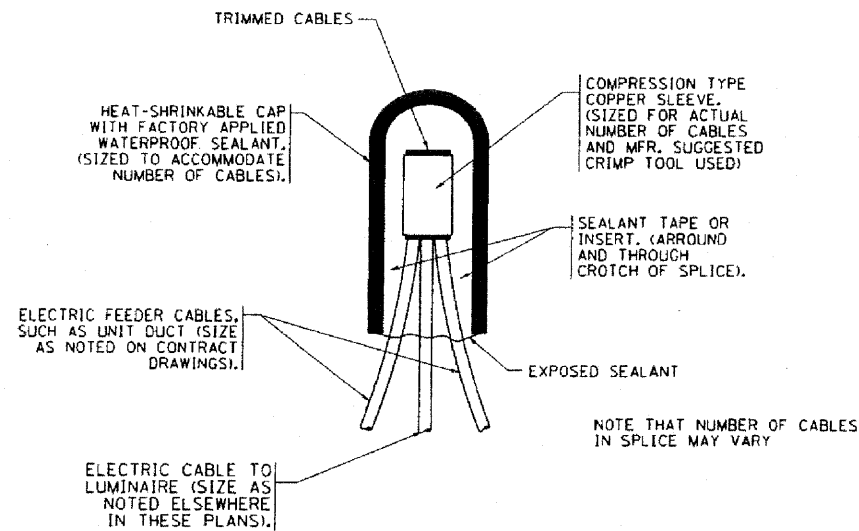

TYPICAL SPLICE DETAIL
N.T.S.

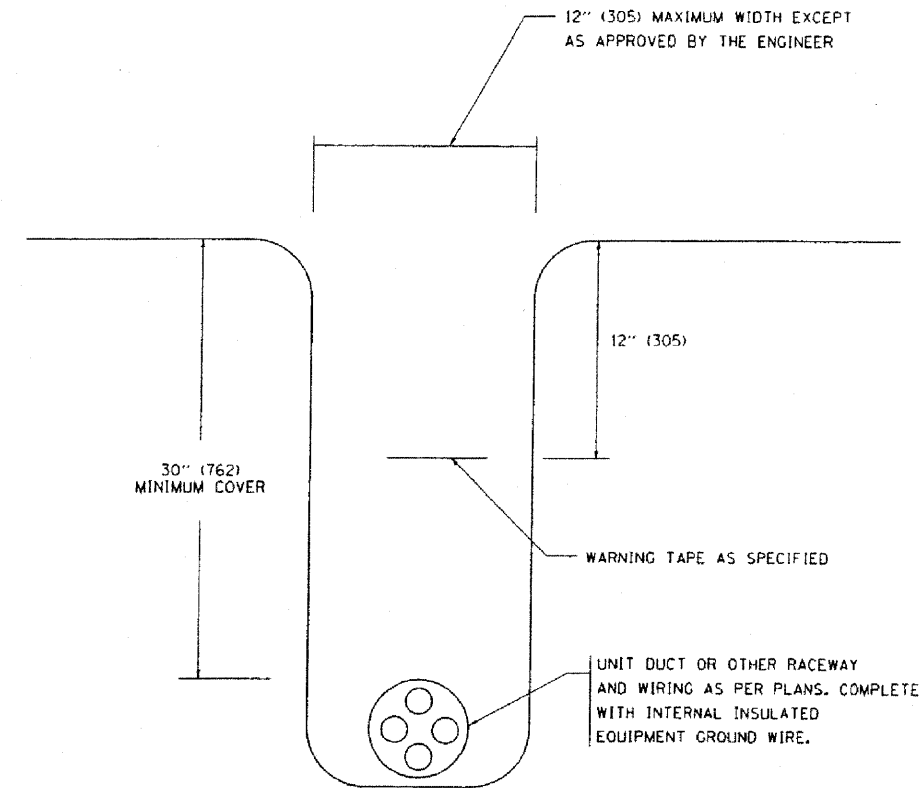

TYPICAL WIRING IN TRENCH DETAIL
N.T.S.

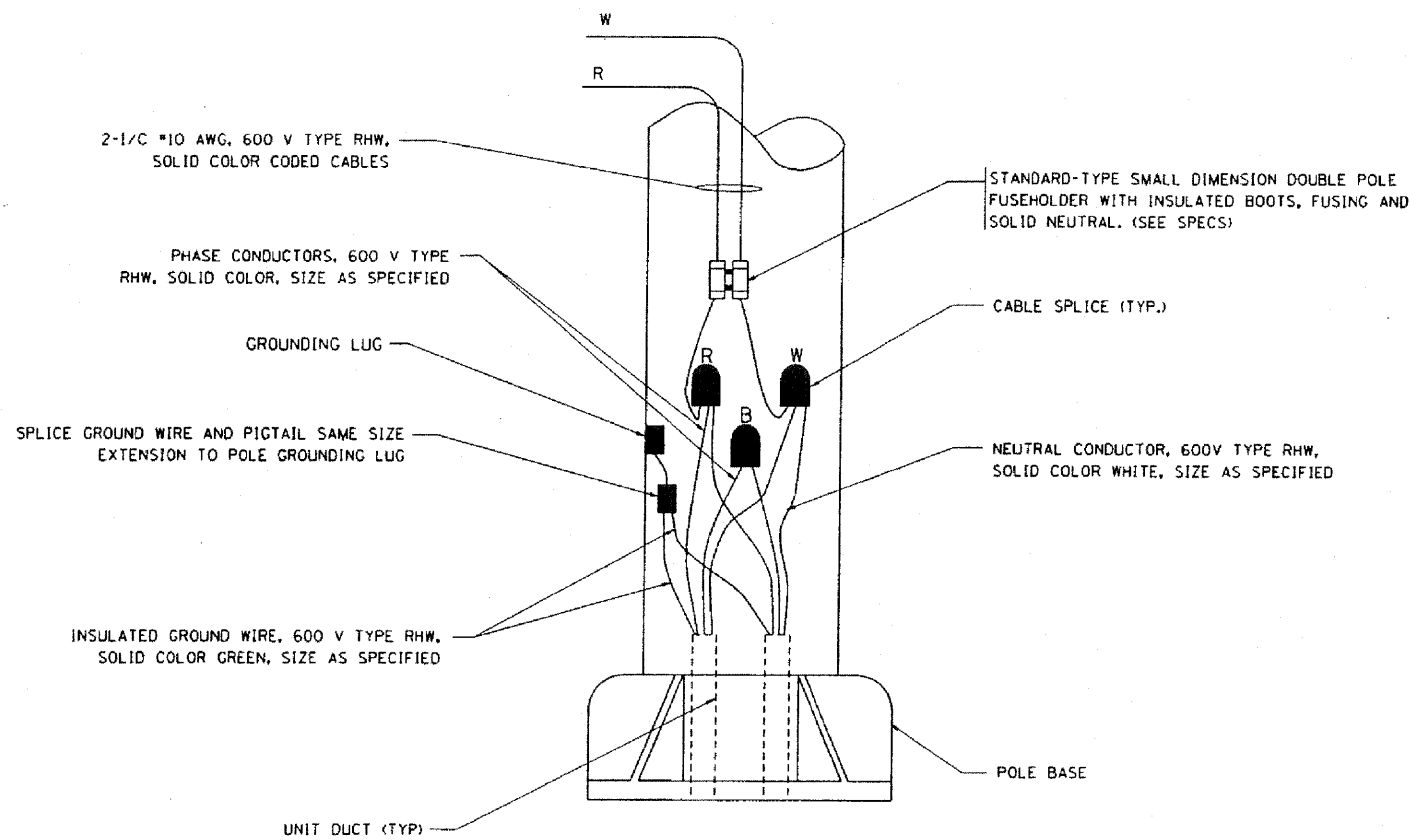

POLE WIRING DETAIL
N.T.S.

PLOT DATE: 2/27/2007
 FILE NAME: 022707.dwg
 PLOT SCALE: 50.000 X IN.
 USER NAME: bboard

REVISIONS	
NAME	DATE

ILLINOIS DEPARTMENT OF TRANSPORTATION

MISC. ELECTRICAL DETAILS
SHEET A

SCALE: VERT.
HORIZ.
DATE: 2/27/2007

DRAWN BY

CHECKED BY

BE-702

REVISION DATE: 01/01/07