

- 1 TITLE PAGE
- 2 PLAN AND PROFILE
- 3 GENERAL PLAN
- 4 SUPERSTRUCTURE CONCRETE DETAILS
- 5 STRUCTURAL STEEL FRAMING PLAN
- 6 STRUCTURAL STEEL DETAILS
- 7 ROCKERS, ROLLERS AND BEARING PLATES
- 8 HANDRAIL DETAILS - BRIDGE
- 9 ABUTMENT DETAILS - FOOTING
- 10 ABUTMENT DETAILS - MAIN WALL
- 11 ABUTMENT DETAILS - WING WALL UNIT I
- 12 ABUTMENT DETAILS - WING WALL UNIT II
- 13 ABUTMENT DETAILS - WING WALL SIDEWALK AND HANDRAIL
- 14 DETAILS - PIERS 1 & 2
- 15 ABUTMENT AND WING WALL DRAINAGE DETAILS
- 16 APPROACH SLAB
- 17 FIELD OFFICE & LABORATORY
- 18 UTILITY CONDUIT DETAILS
- 19 BAR LIST & BILL OF MATERIAL
- 20 PLAN & PROFILE - KEELER AVENUE
- 21 STANDARD SYMBOLS
- 22 LIMITS OF EXCAVATION
- 23 BILL OF MATERIAL - PAVING
- 24 TIES TO CROSS STREETS
- 25 TRAVERSE LINES & ALIGNMENT
- 26 CURB, GUTTER & JOINT LAYOUT
- 27 TYPICAL CROSS SECTIONS
- 28 PLAN & PROFILE OF CURB TRANSITION
- 29 CROSS SECTIONS
- 30 CROSS SECTIONS
- 31 CROSS SECTIONS
- 32 STANDARD SECTION MARKER
- 33 ALTERNATE DESIGNS FOR LONGITUDINAL METAL JOINT
- 34 DETAILS OF STANDARD BARRICADE
- 35 DETAILS OF PORTLAND CEMENT CONCRETE SIDEWALK CONSTRUCTION
- 36 DETAILS OF CURB & GUTTER
- 37 STANDARD DESIGN PAVEMENT FABRIC - TYPE A & TYPE B
- 38 ELECTRICAL PLANS
- 39 DRAINAGE & UTILITIES ADJUSTMENTS
- 40 DETAIL OF LATERAL SEWER CONNECTION
- 41 TYPE A MANHOLE
- 42 DETAIL OF STANDARD FRAME & GRATES
- 43 TRENCH BACKFILL & PAVEMENT REPLACEMENT
- 44 TRENCH BACKFILL & PAVEMENT REPLACEMENT ENTIRE
- 45 CAST IRON GRATE TYPE 37
- 46 TYPE II FRAME & GRATE
- 47 DETAILS OF TYPE A INLET
- 48 TYPE A2 CATCH BASIN
- 49 NAME PLATES

STATE OF ILLINOIS
COUNTY OF COOK
DEPARTMENT OF HIGHWAYS

PLANS FOR PROPOSED
FEDERAL AID HIGHWAY

SCALES

PLAN	1" = 40' FT.
PROFILE HOR.	1" = 40' FT.
PROFILE VERT.	1" = 4' FT.
CROSS SECTIONS	1" = 10' FT. VERT.
CROSS SECTIONS	1" = 10' FT. HOR.

FA. ROUTE 131-PROJECT U.I. 261(61)
KEELER AVENUE GRADE SEPARATION
OVER
CONGRESS STREET EXPRESSWAY

SEC. 062-2929.1-M.F.T.


SEC. 062-2929.1A-M.F.T.

QUANTITY		UNIT	ITEM
103.12	307.9	CUYDS	CLASS 3 CONCRETE
120.80	577.200	LBS.	REINFORCING
131.00	442.840	LBS.	STEEL
10.65		EACH	BRIDGE
31.2		LIN. FT.	BRIDGE
72.0		LIN. FT.	BRIDGE
72.0		LIN. FT.	BRIDGE
26.88		LIN. FT.	BRIDGE
31.2		LIN. FT.	BRIDGE
10.61	1.94	LIN. FT.	BRIDGE
14.6	91.3	GALS.	PAINT
12.0		LIN. FT.	PAINT
32.00		SQ. YDS.	PAINT
2		CU. YDS.	PAINT
13.12	403.7	LIN. FT.	PAINT
14.1		SQ. YDS.	PAINT
73		TONS	PAINT
38		TONS	PAINT
29		TONS	PAINT
10		TONS	PAINT
32		TONS	PAINT
20.0		TONS	PAINT
112.0		GALS.	PAINT
10.63		LIN. FT.	PAINT
15.2		SQ. FT.	PAINT
131.2		SQ. YDS.	PAINT
145.6		SQ. FT.	PAINT
21.528		CU. YDS.	PAINT
40		TONS	PAINT
0.1		ACRES	PAINT
2		EACH	PAINT
708		SQ. YDS.	PAINT
006		TONS	PAINT
720		MGALS	PAINT
2280		TONS	PAINT
41.4		LIN. FT.	PAINT
60		LIN. FT.	PAINT
4		EACH	PAINT
4		EACH	PAINT
1		EACH	PAINT
4		EACH	PAINT
343.2	804	CU. YDS.	PAINT
21.2		LIN. FT.	PAINT
174		LIN. FT.	PAINT
44		LIN. FT.	PAINT
90		LIN. FT.	PAINT
80		LIN. FT.	PAINT
46		LIN. FT.	PAINT
669		LIN. FT.	PAINT
28		LIN. FT.	PAINT
667		LIN. FT.	PAINT
5		EACH	PAINT
7		EACH	PAINT
2		EACH	PAINT
2		EACH	PAINT
3		EACH	PAINT
3		EACH	PAINT
81		EACH	PAINT
448		CU. YDS.	PAINT
110		SQ. YDS.	PAINT
28		TONS	PAINT
2		EACH	PAINT
24		IN DIA	PAINT

RETURN THIS PLAN
TO MAINTENANCE
ROOM 706

DRAWER

2A

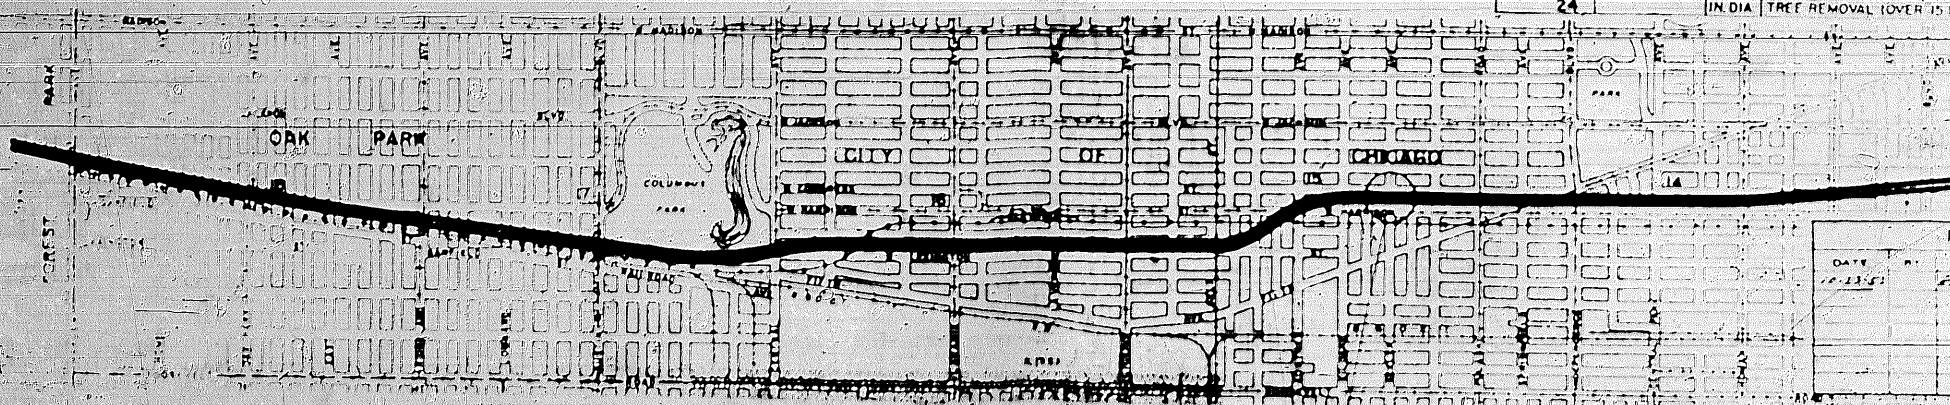

SECTION ONE - 062-2929.1-M.F.T. INCLUDES THE PROPOSED CONSTRUCTION OF THE SUPERSTRUCTURE STRUCTURAL STEEL, CONCRETE SIDEWALK AND METAL HANDRAIL FOR THE CONSTRUCTION OF THE PLANNED GRADE SEPARATION, A 40' WIDE KEELER AVENUE OVER CONGRESS STREET EXPRESSWAY IN THE CITY OF CHICAGO, WEST TOWNSHIP OF STURGEON 4-00-00 ON CONGRESS STREET EXPRESSWAY A POINT APPROXIMATELY 104' NORTH OF THE INTERSECTION OF KEELER AVENUE AND CONGRESS STREET.

SECTION TWO - 062-2929.1A-M.F.T. INCLUDES THE CONSTRUCTION OF THE PIER, ABUTMENT, SHOULDER, PAVEMENT, PAVING AND UTILITY ADJUSTMENTS FOR THE CONSTRUCTION OF A 40' WIDE PLANNED GRADE SEPARATION, A 40' WIDE KEELER AVENUE OVER CONGRESS STREET EXPRESSWAY IN THE CITY OF CHICAGO, WEST TOWNSHIP OF STURGEON 4-00-00 ON CONGRESS STREET EXPRESSWAY A POINT APPROXIMATELY 104' NORTH OF THE INTERSECTION OF KEELER AVENUE AND CONGRESS STREET.

REVISIONS	
DATE	DESCRIPTION
10-1-55	FOR REVISIONS

COUNTY OF COOK
DEPARTMENT OF HIGHWAYS

APPROVED: *James M. Curran* 10-1-55
DISTRICT ENGINEER

APPROVED: *Norman H. ...* 10-1-55
SUPERINTENDENT

STATE OF ILLINOIS
DEPARTMENT OF PUBLIC ROADS AND BUILDINGS
DIVISION OF HIGHWAYS

APPROVED: *...* 10-1-55
DISTRICT ENGINEER

DEPARTMENT OF COMMERCE
BUREAU OF PUBLIC ROADS

RECOMMENDED FOR APPROVAL


DISTRICT ENGINEER DATE
APPROVED

DIVISION ENGINEER DATE



B.M. #8 El. 23.793
on concrete walk on
S.E. corner 320 S. & 320 E. of
E. of Congress & Keeler Ave. (C.P. 181)


SEC. 15-39-18
CITY OF CHICAGO - WEST TWP.
POP. 3,620,962

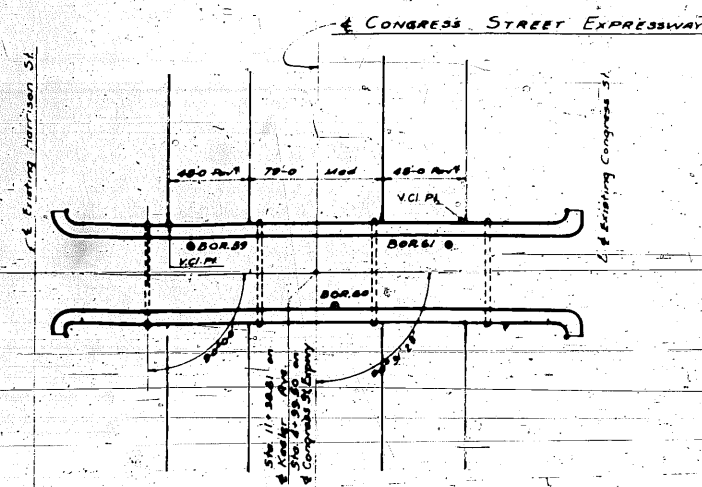

PLAN
Scale 1"=50'

Note: For Existing Improvements & Topography See Sheet No. 20
For Utilities & Drainage Details See Sheet No. 35
For Detail of Proposed Pavement & Improvement See Sheet No. 20
For Location Plan See Sheet No. 22 and No. 23
Chicago City Datum 0'00" = 579.50 USMS (Cook County)


DESIGN SPEED 25 M.P.H.

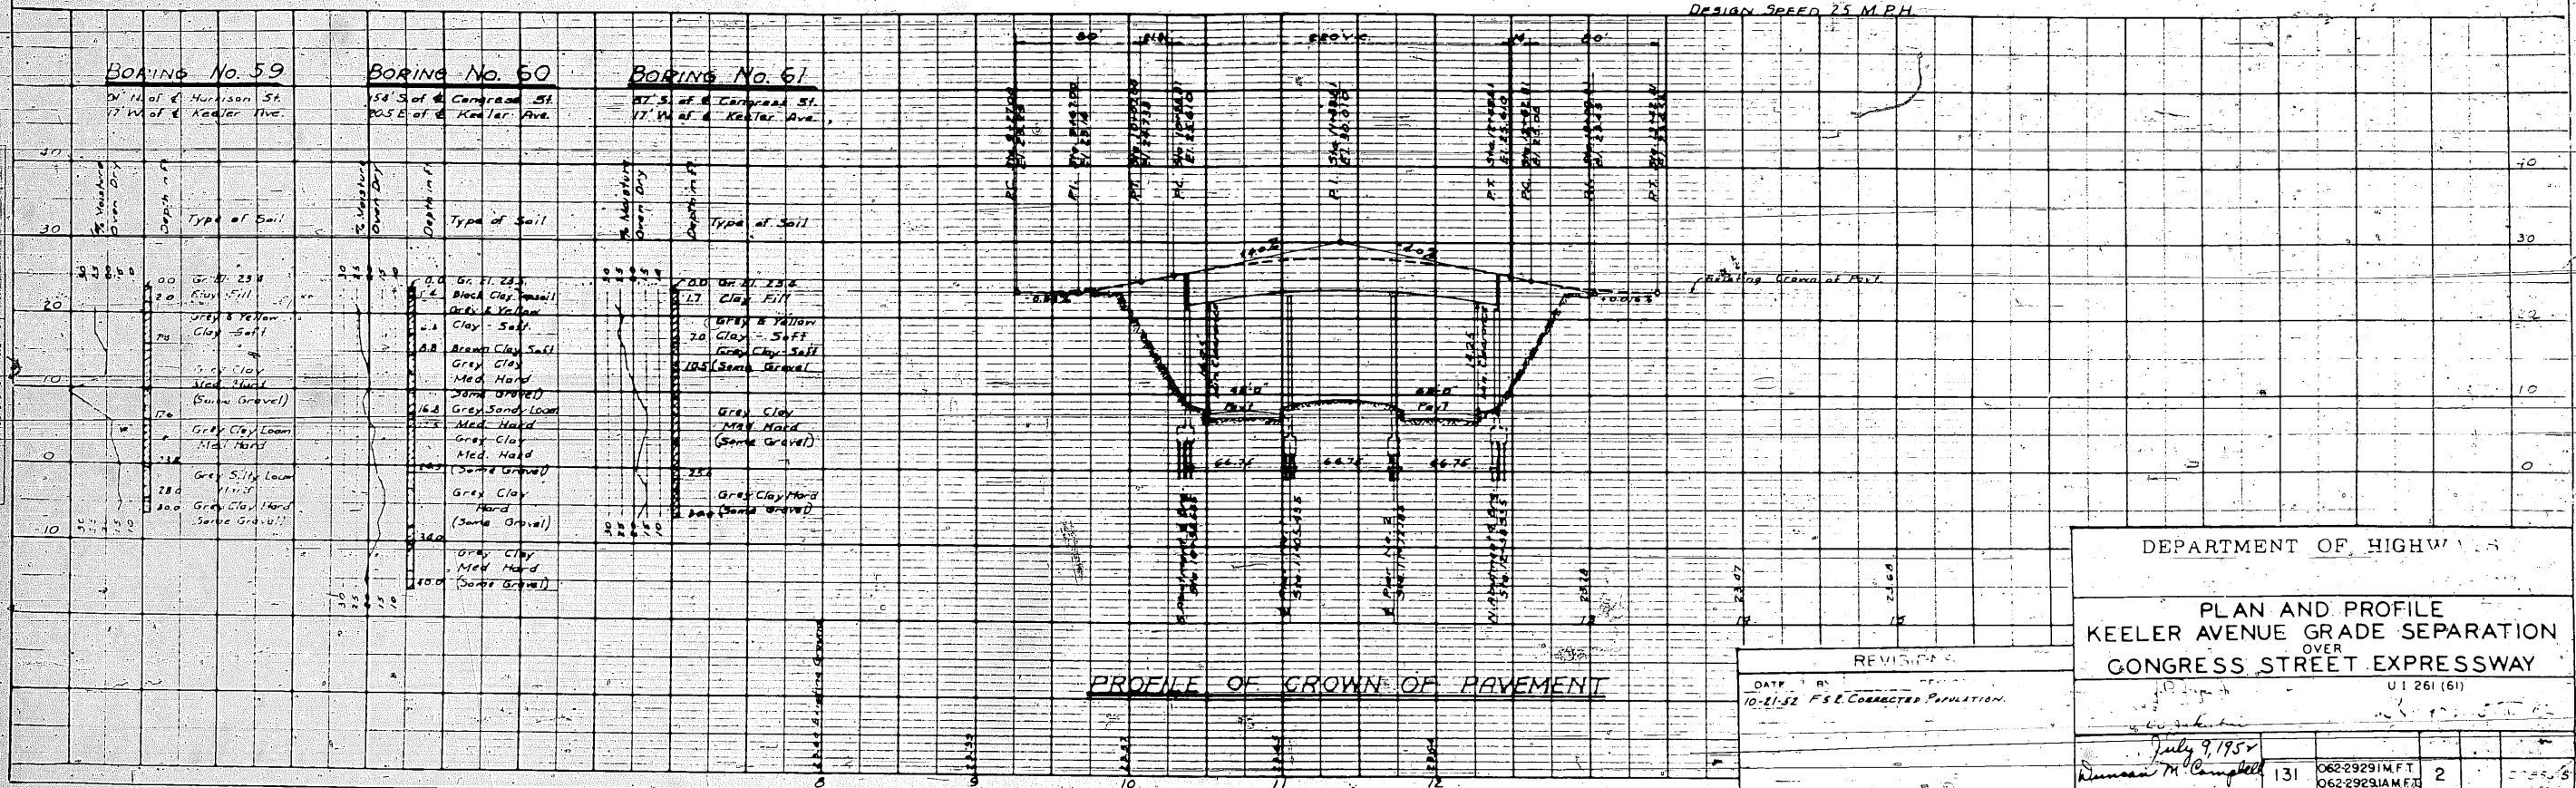

PROFILE OF CROWN OF PAVEMENT


DEPARTMENT OF HIGHWAYS			
PLAN AND PROFILE KEELER AVENUE GRADE SEPARATION OVER CONGRESS STREET EXPRESSWAY			
DATE: 10-21-52		F.S.E. CORRECTED POPULATION	
DESIGNED BY: [Signature]		UT 261 (61)	
CHECKED BY: [Signature]		[Signature]	
131	062-29291M.F.T.	2	062-29291AM.F.T.

PLATE 1-PLAN-PROFILE & P.R. & E. STANDARDS
THE ILLINOIS STATE BOARD OF ENGINEERS

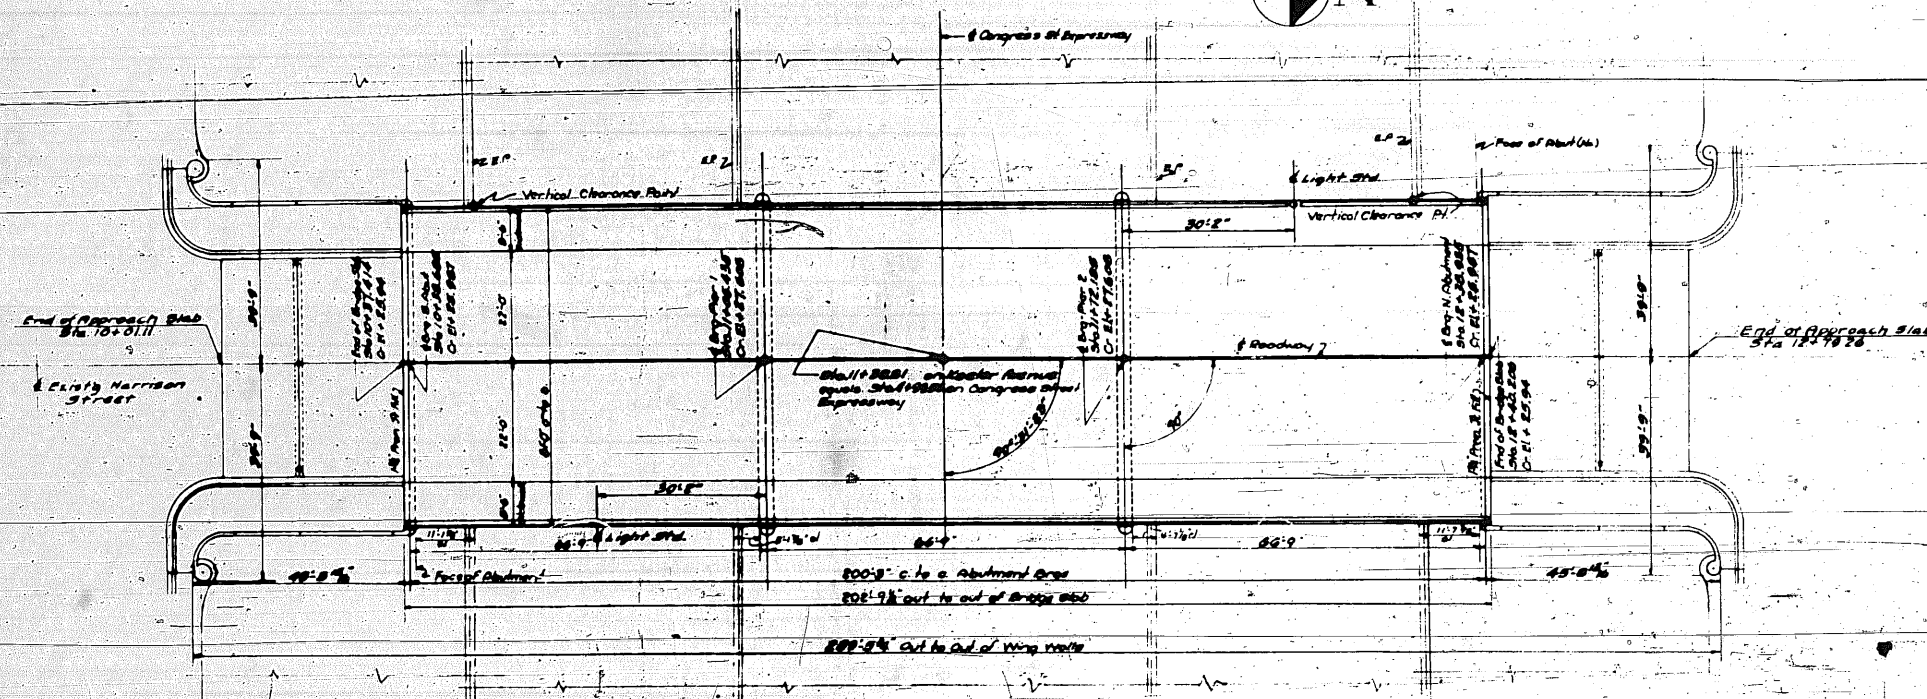

DESIGN DATA

Two Lamps	400 96-44
North Bridge in	30000 96-44
South Bridge	15000 96-44
South Bridge	20000 96-44
South Bridge	700 96-44
South Bridge	100 96-44

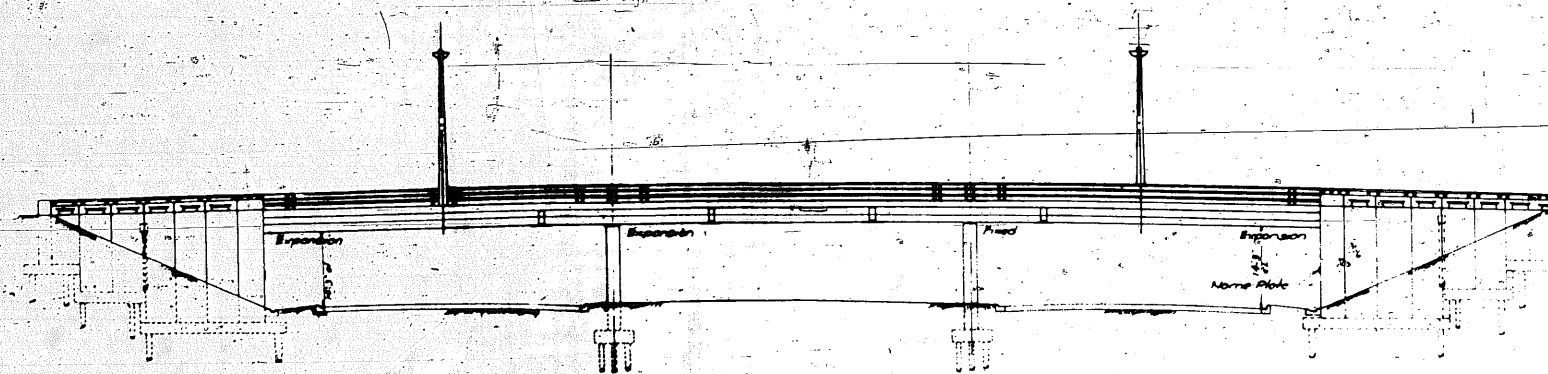

ELEVATION

GENERAL NOTES

GENERAL NOTES

1. The Contractor shall drive pile(s) as part of permanent pile groups as directed by the Engineer, before ordering balance of piles.


2. All piles shall be driven to obtain a minimum penetration of 10.0 into a stratum of solid material, regardless of bearing capacity developed.

Each section of bridge floor slab shall be poured in one continuous operation from abutment to abutment.
Finishing of floor slab shall comply with Section 51 of the Standard Specifications

The cost of copper water seal, copper nails and prepackaged joint filler are to be included in the bid price of Class x Concrete. The Copper Water Seal applies shall be banded or breasted.

Class x Concrete to be used thruout except Concr in Wing Handrails which shall be Handrail Concrete





DEPARTMENT OF HIGHWAYS COOK COUNTY, ILLINOIS WILLIAM N. F. TAYLOR, President PRESIDENT BOARD OF SUPERVISORS				
GENERAL PLAN KEELER AVENUE GRADE SEPARATION OVER CONGRESS STREET EXPRESSWAY				
COMPUTED DRAWN CHECKED		PROJECT NO. 1261 (61) DATE CONTRACT NO.		
APPROVED <i>William M. Campbell</i>		SHEET NO. 131	ROUTE NO. 062728191 062728191	SEE NO. 3
			TOTAL SHEETS 1	DRAWN BY C. S. S.

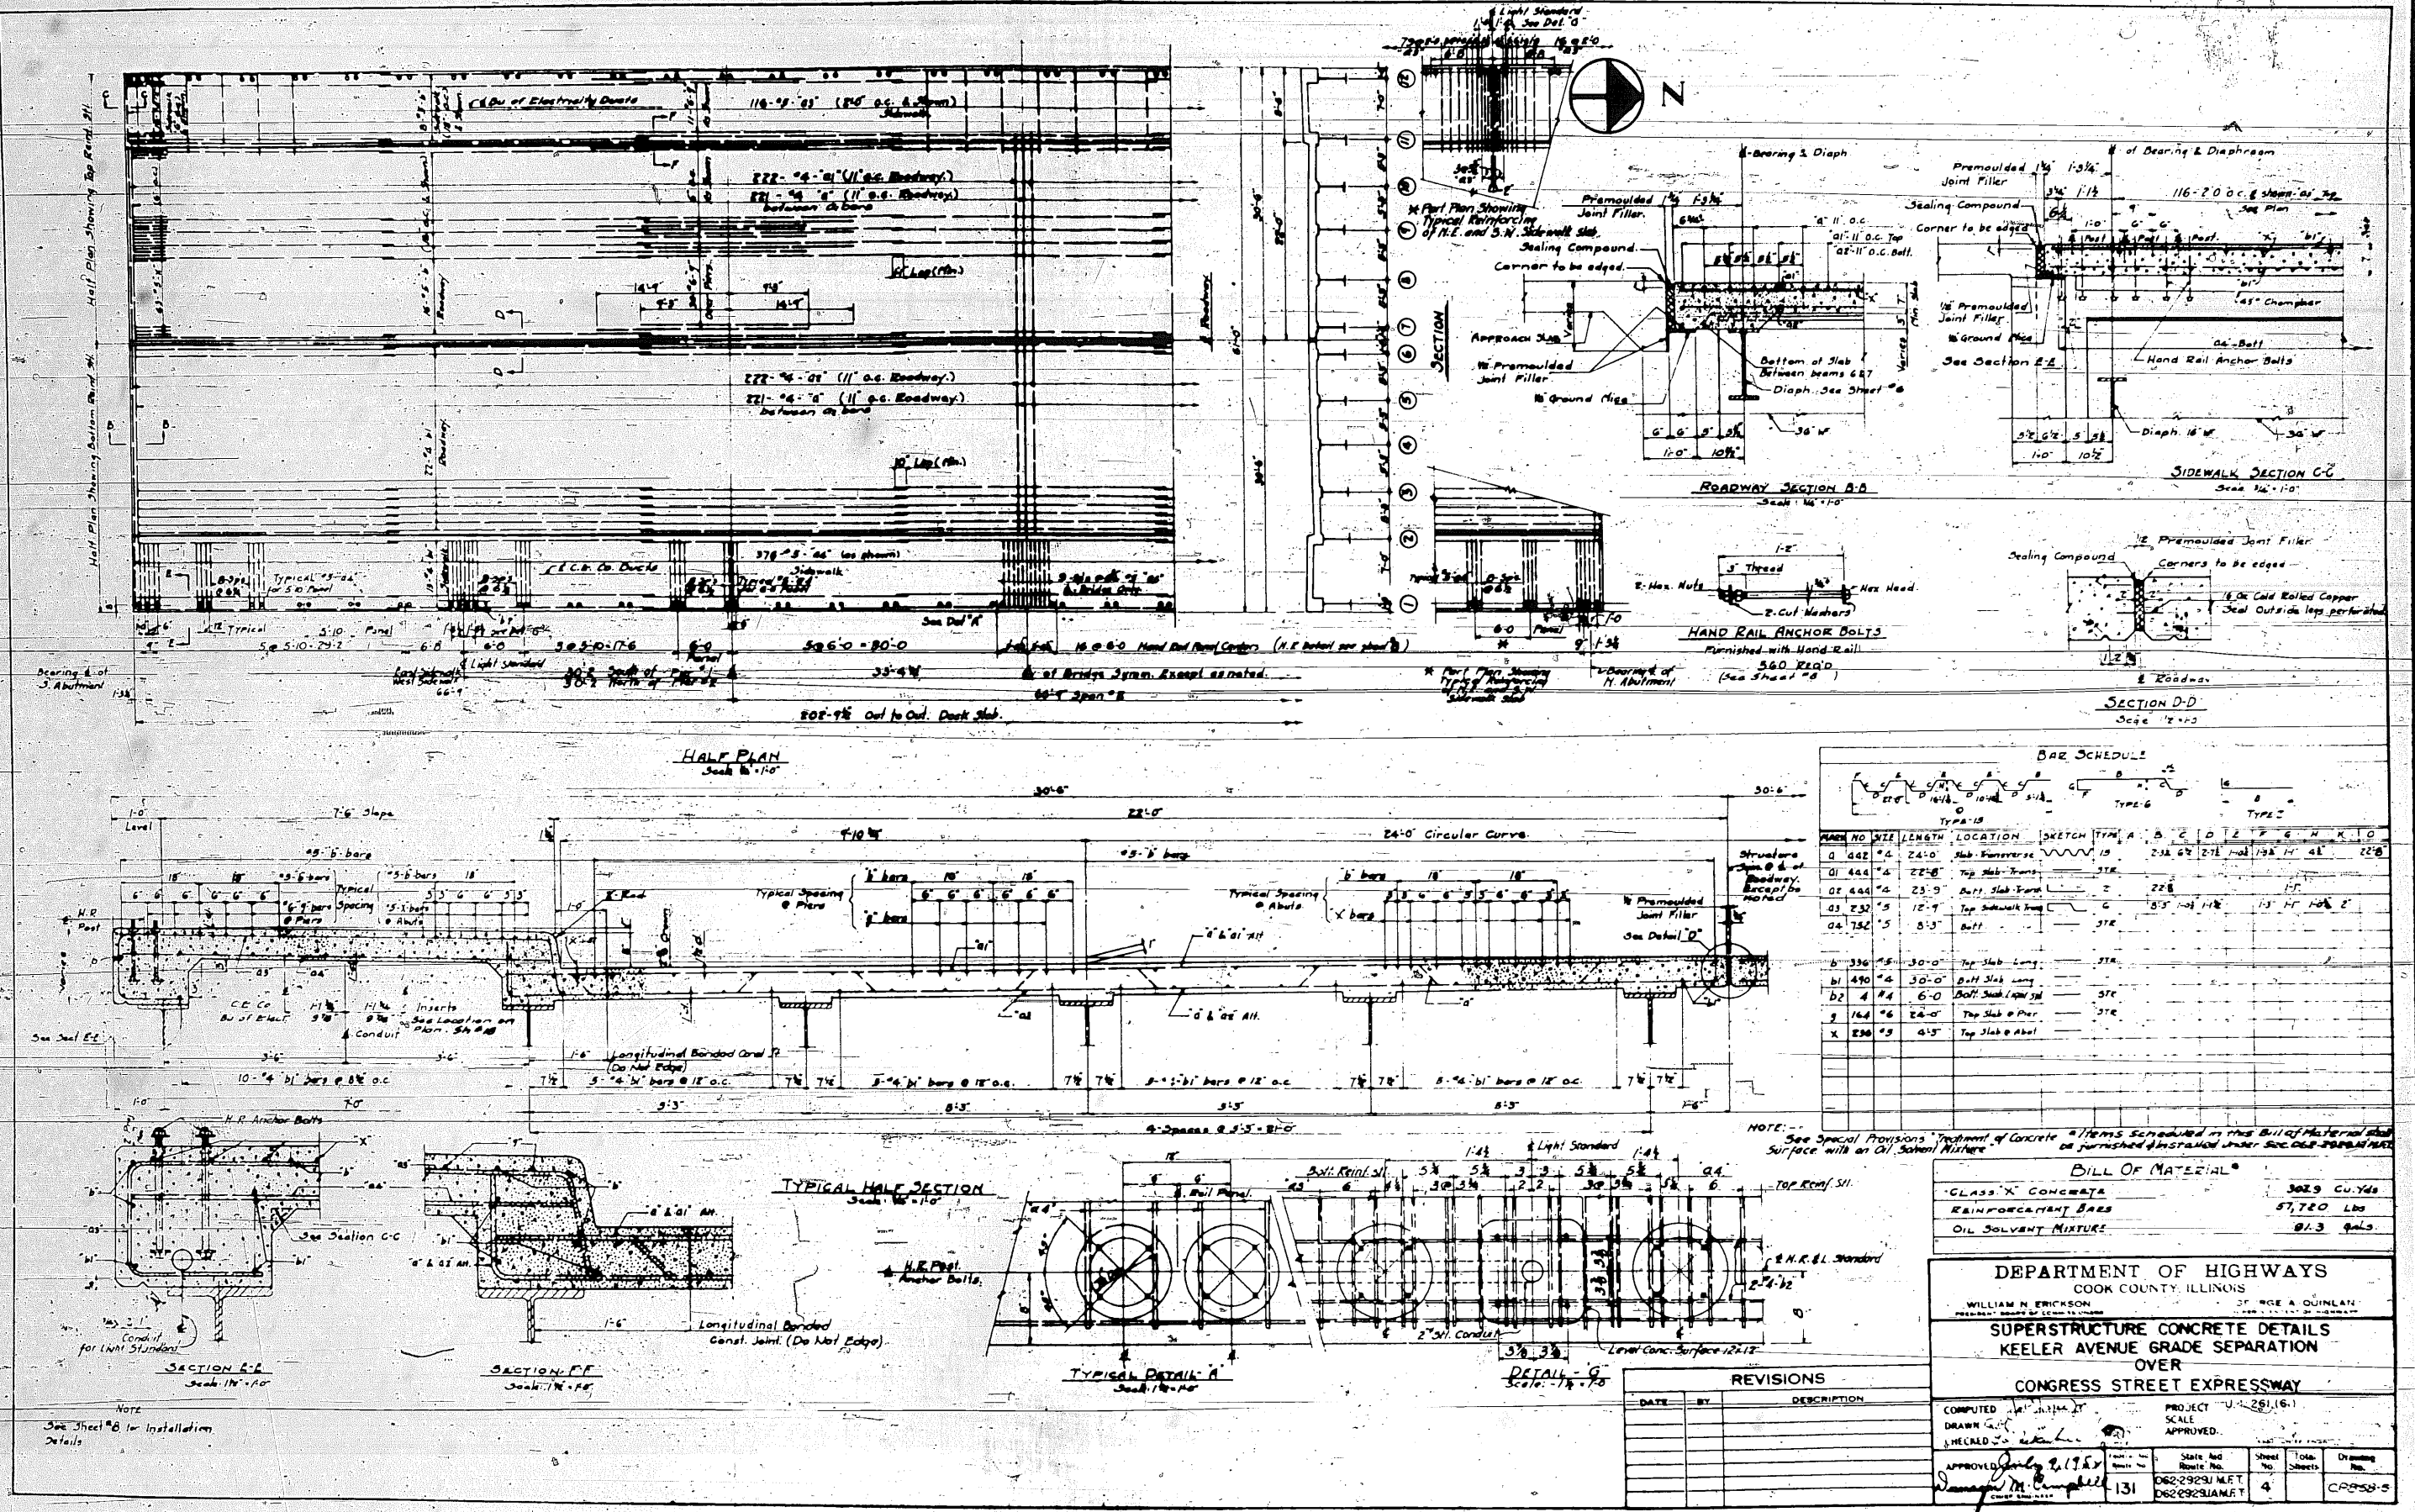

BAR SCHEDULE									
NO.	SIZE	LENGTH	LOCATION	SKETCH	TYPE	A	B	C	D
1	4	24'-0"	Slab - Transverse		15				
2	4	22'-0"	Top Slab - Transverse		15				
3	4	23'-0"	Bottom Slab - Transverse		15				
4	4	12'-0"	Top Slab - Longitudinal		15				
5	4	12'-0"	Bottom Slab - Longitudinal		15				
6	4	30'-0"	Top Slab - Longitudinal		15				
7	4	30'-0"	Bottom Slab - Longitudinal		15				
8	4	6'-0"	Bottom Slab - Longitudinal		15				
9	4	24'-0"	Top Slab - Pier		15				
10	4	4'-0"	Top Slab - Abutment		15				




BILL OF MATERIAL	
CLASS 'X' CONCRETE	302.9 Cu. Yds.
REINFORCEMENT BARS	57,720 Lbs.
OIL SOLVENT MIXTURE	81.3 gals.

DEPARTMENT OF HIGHWAYS	
COOK COUNTY, ILLINOIS	
WILLIAM N. ERICKSON	
SUPERSTRUCTURE CONCRETE DETAILS	
KEELER AVENUE GRADE SEPARATION	
OVER	
CONGRESS STREET EXPRESSWAY	
COMPUTED	PROJECT U-25(16)
DRAWN	SCALE
CHECKED	APPROVED
APPROVED	DATE
131	08/29/51
08/29/51	08/29/51
4	CROSS-5

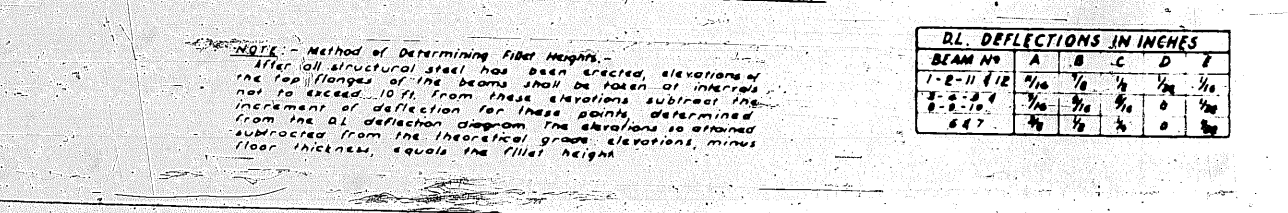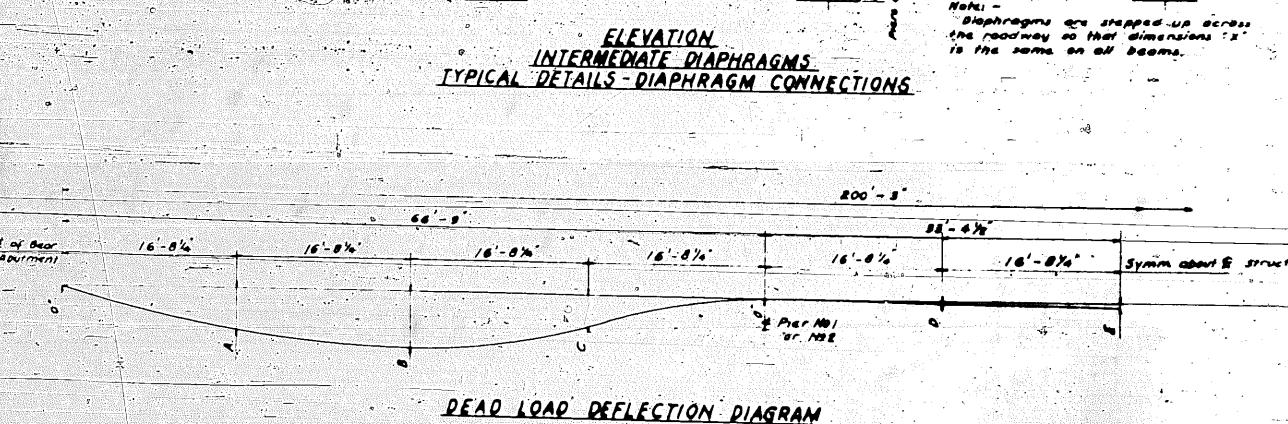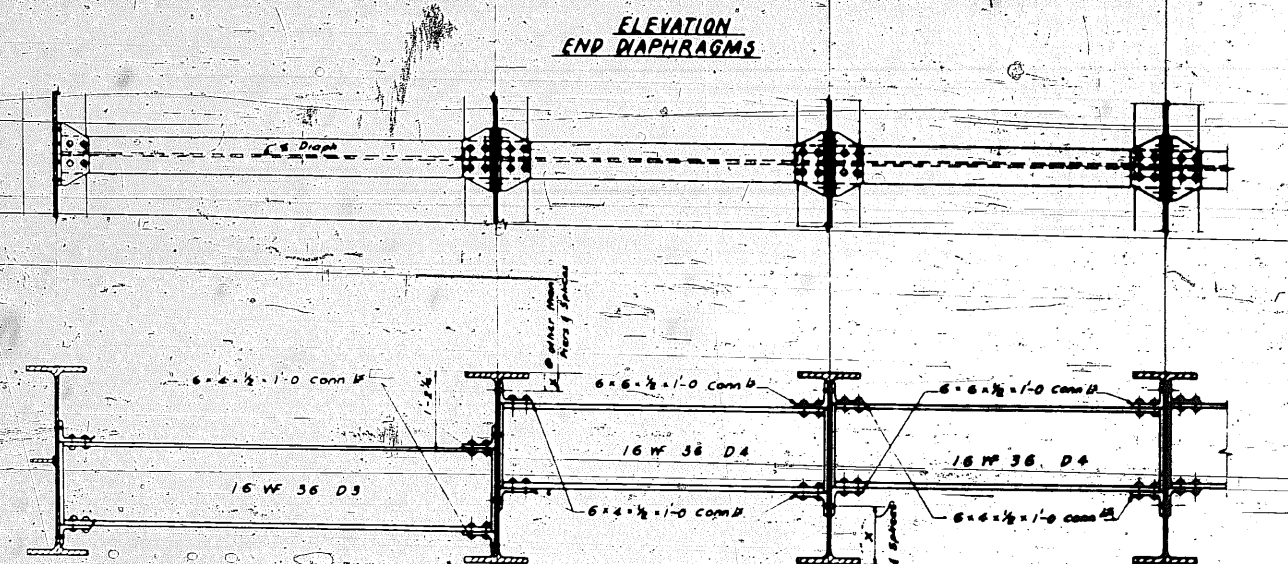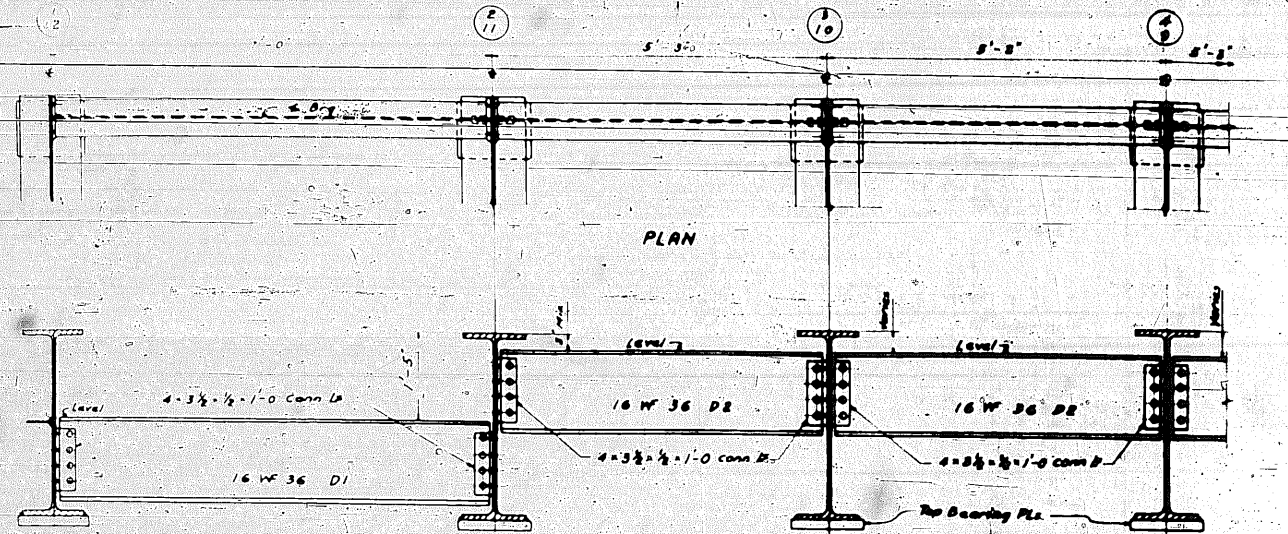

DL DEFLECTIONS IN INCHES						
BEAM NO.	A	B	C	D	E	F
1-2-11-12	1/16	1/8	1/8	1/8	1/8	1/8
3-4-5-6	1/16	1/8	1/8	1/8	1/8	1/8
7-8-9-10	1/16	1/8	1/8	1/8	1/8	1/8
11-12-13-14	1/16	1/8	1/8	1/8	1/8	1/8


NOTE - Method of Determining Fiber Heights -
After all structural steel has been erected, elevations of the top flanges of the beams shall be taken at intervals not to exceed 10 ft. from these elevations subtract the increment of deflection for these points determined from the DL deflection diagram. The elevations so obtained subtracted from the theoretical grade elevations, minus floor thickness, equals the fiber height.

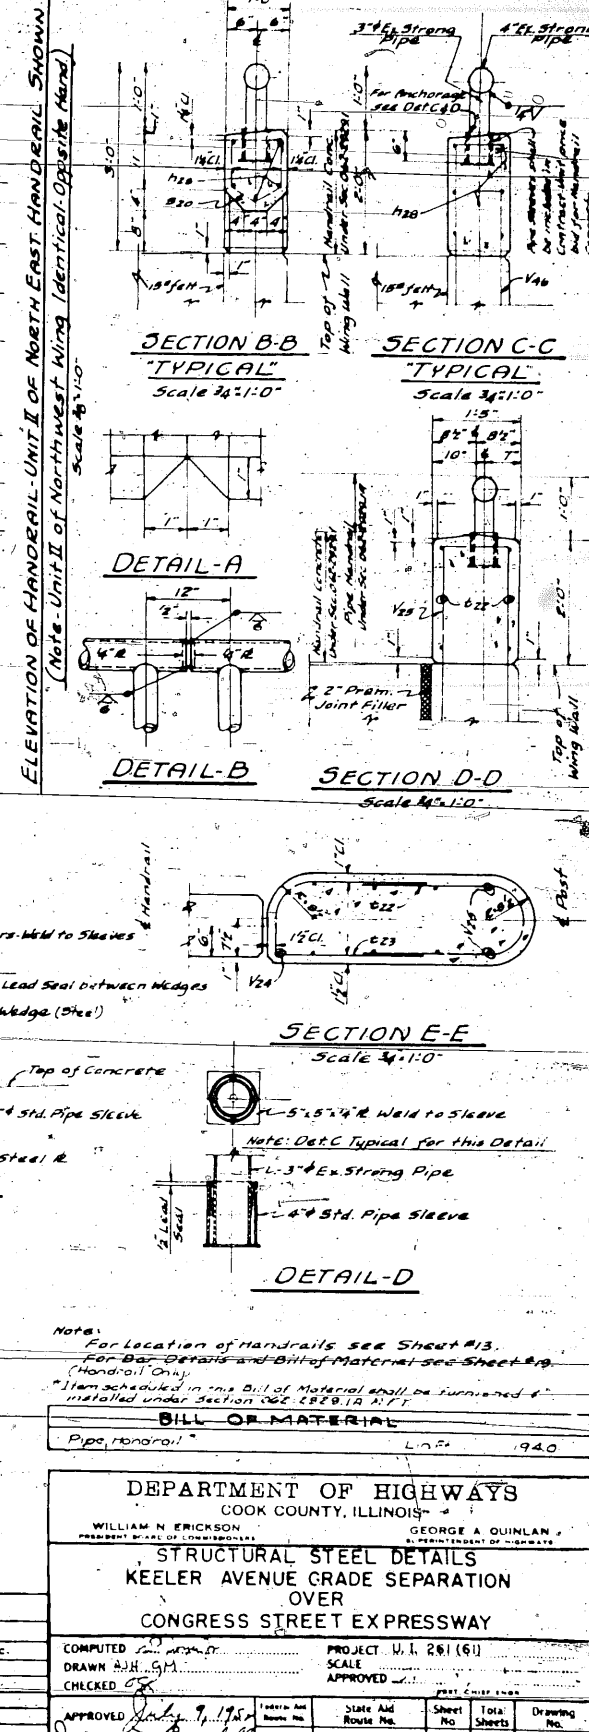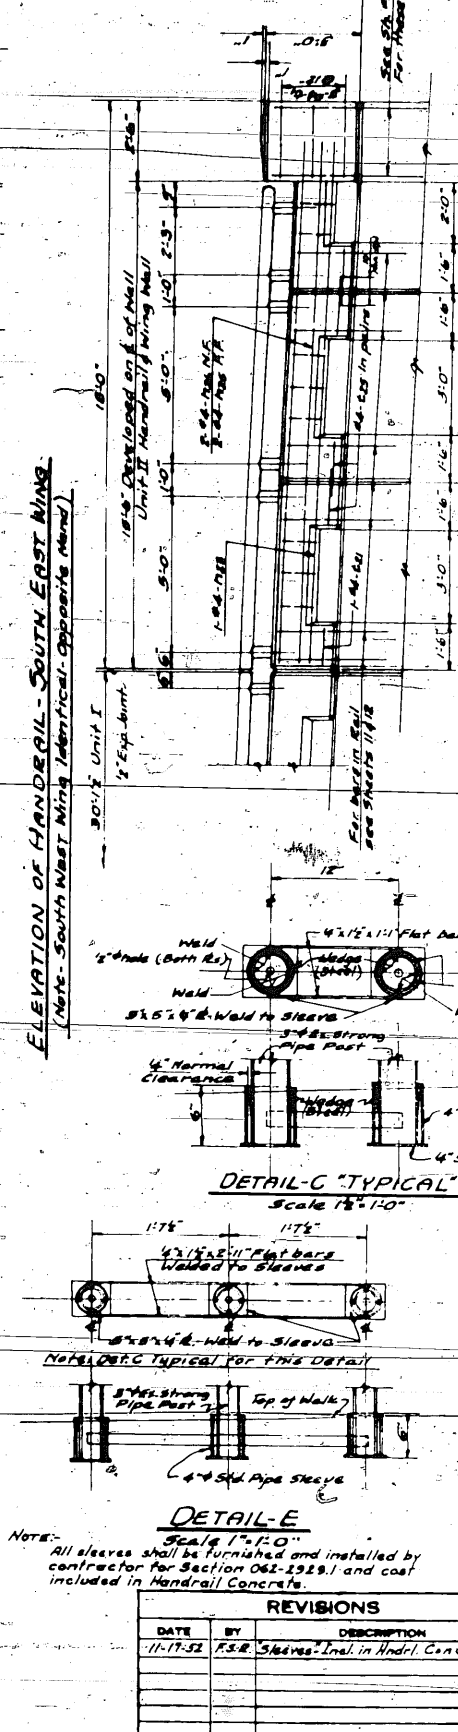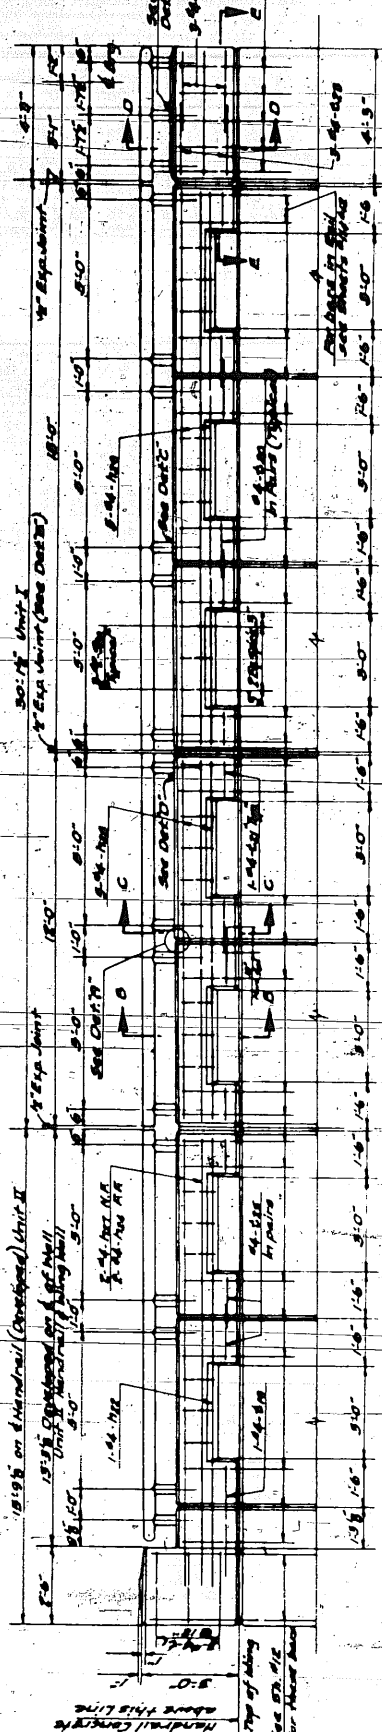

Notes:
For location of handrails see Sheet #13.
For Bar Details and Bill of Material see Sheet #9.
Handrail Only.
Items scheduled in this Bill of Material shall be furnished & installed under Section 062-292.10 M.F.T.



BILL OF MATERIAL		
Pipe, Handrail	1.25	1940

DEPARTMENT OF HIGHWAYS						
COOK COUNTY, ILLINOIS						
WILLIAM N. ERICKSON PRESIDENT BOARD OF COMMISSIONERS		GEORGE A. QUINLAN SUPERINTENDENT OF HIGHWAYS				
STRUCTURAL STEEL DETAILS						
KEELER AVENUE GRADE SEPARATION						
OVER						
CONGRESS STREET EXPRESSWAY						
COMPUTED <i>[Signature]</i>		PROJECT U.I. 281 (6)				
DRAWN A.H. GM		SCALE				
CHECKED <i>[Signature]</i>		APPROVED <i>[Signature]</i>				
APPROVED <i>[Signature]</i> Jan 7 1928		Federal Aid Route No.	State Aid Route No.	Sheet No.	Total Sheets	Drawing No.
<i>[Signature]</i> CHIEF ENGINEER		131	062-292.1 M.F.T. 062-292.1A	6	CP8	

 


Furnished and ④ weight
Installed under 002-29494

  PLAN

[illegible]

DEPARTMENT OF HIGHWAYS COOK COUNTY, ILLINOIS					
WILLIAM N. ERICKSON President Board of Commissioners		GEORGE A. QUINN, JR. County Engineer			
ROCKERS, ROLLERS & BEARING PLATES KEELER AVENUE GRADE SEPARATION OVER CONGRESS STREET EXPRESSWAY					
COMPUTED BY <i>E. J. Quinn</i> DRAWN BY <i>W. H. Quinn</i> CHECKED BY <i>E. J. Quinn</i>		PROJECT <u>U. L. 261 (E)</u> SCALE _____ APPROVED _____			
APPROVED <i>[Signature]</i> <u>1953</u> <i>[Signature]</i> CHIEF ENGINEER		Project and Route No. 131	State Aid Route No. 066-29231M.F. 066-29231M.F.	Sheet No. 7	Total Sheets Drawing No. 066-29231M.F.

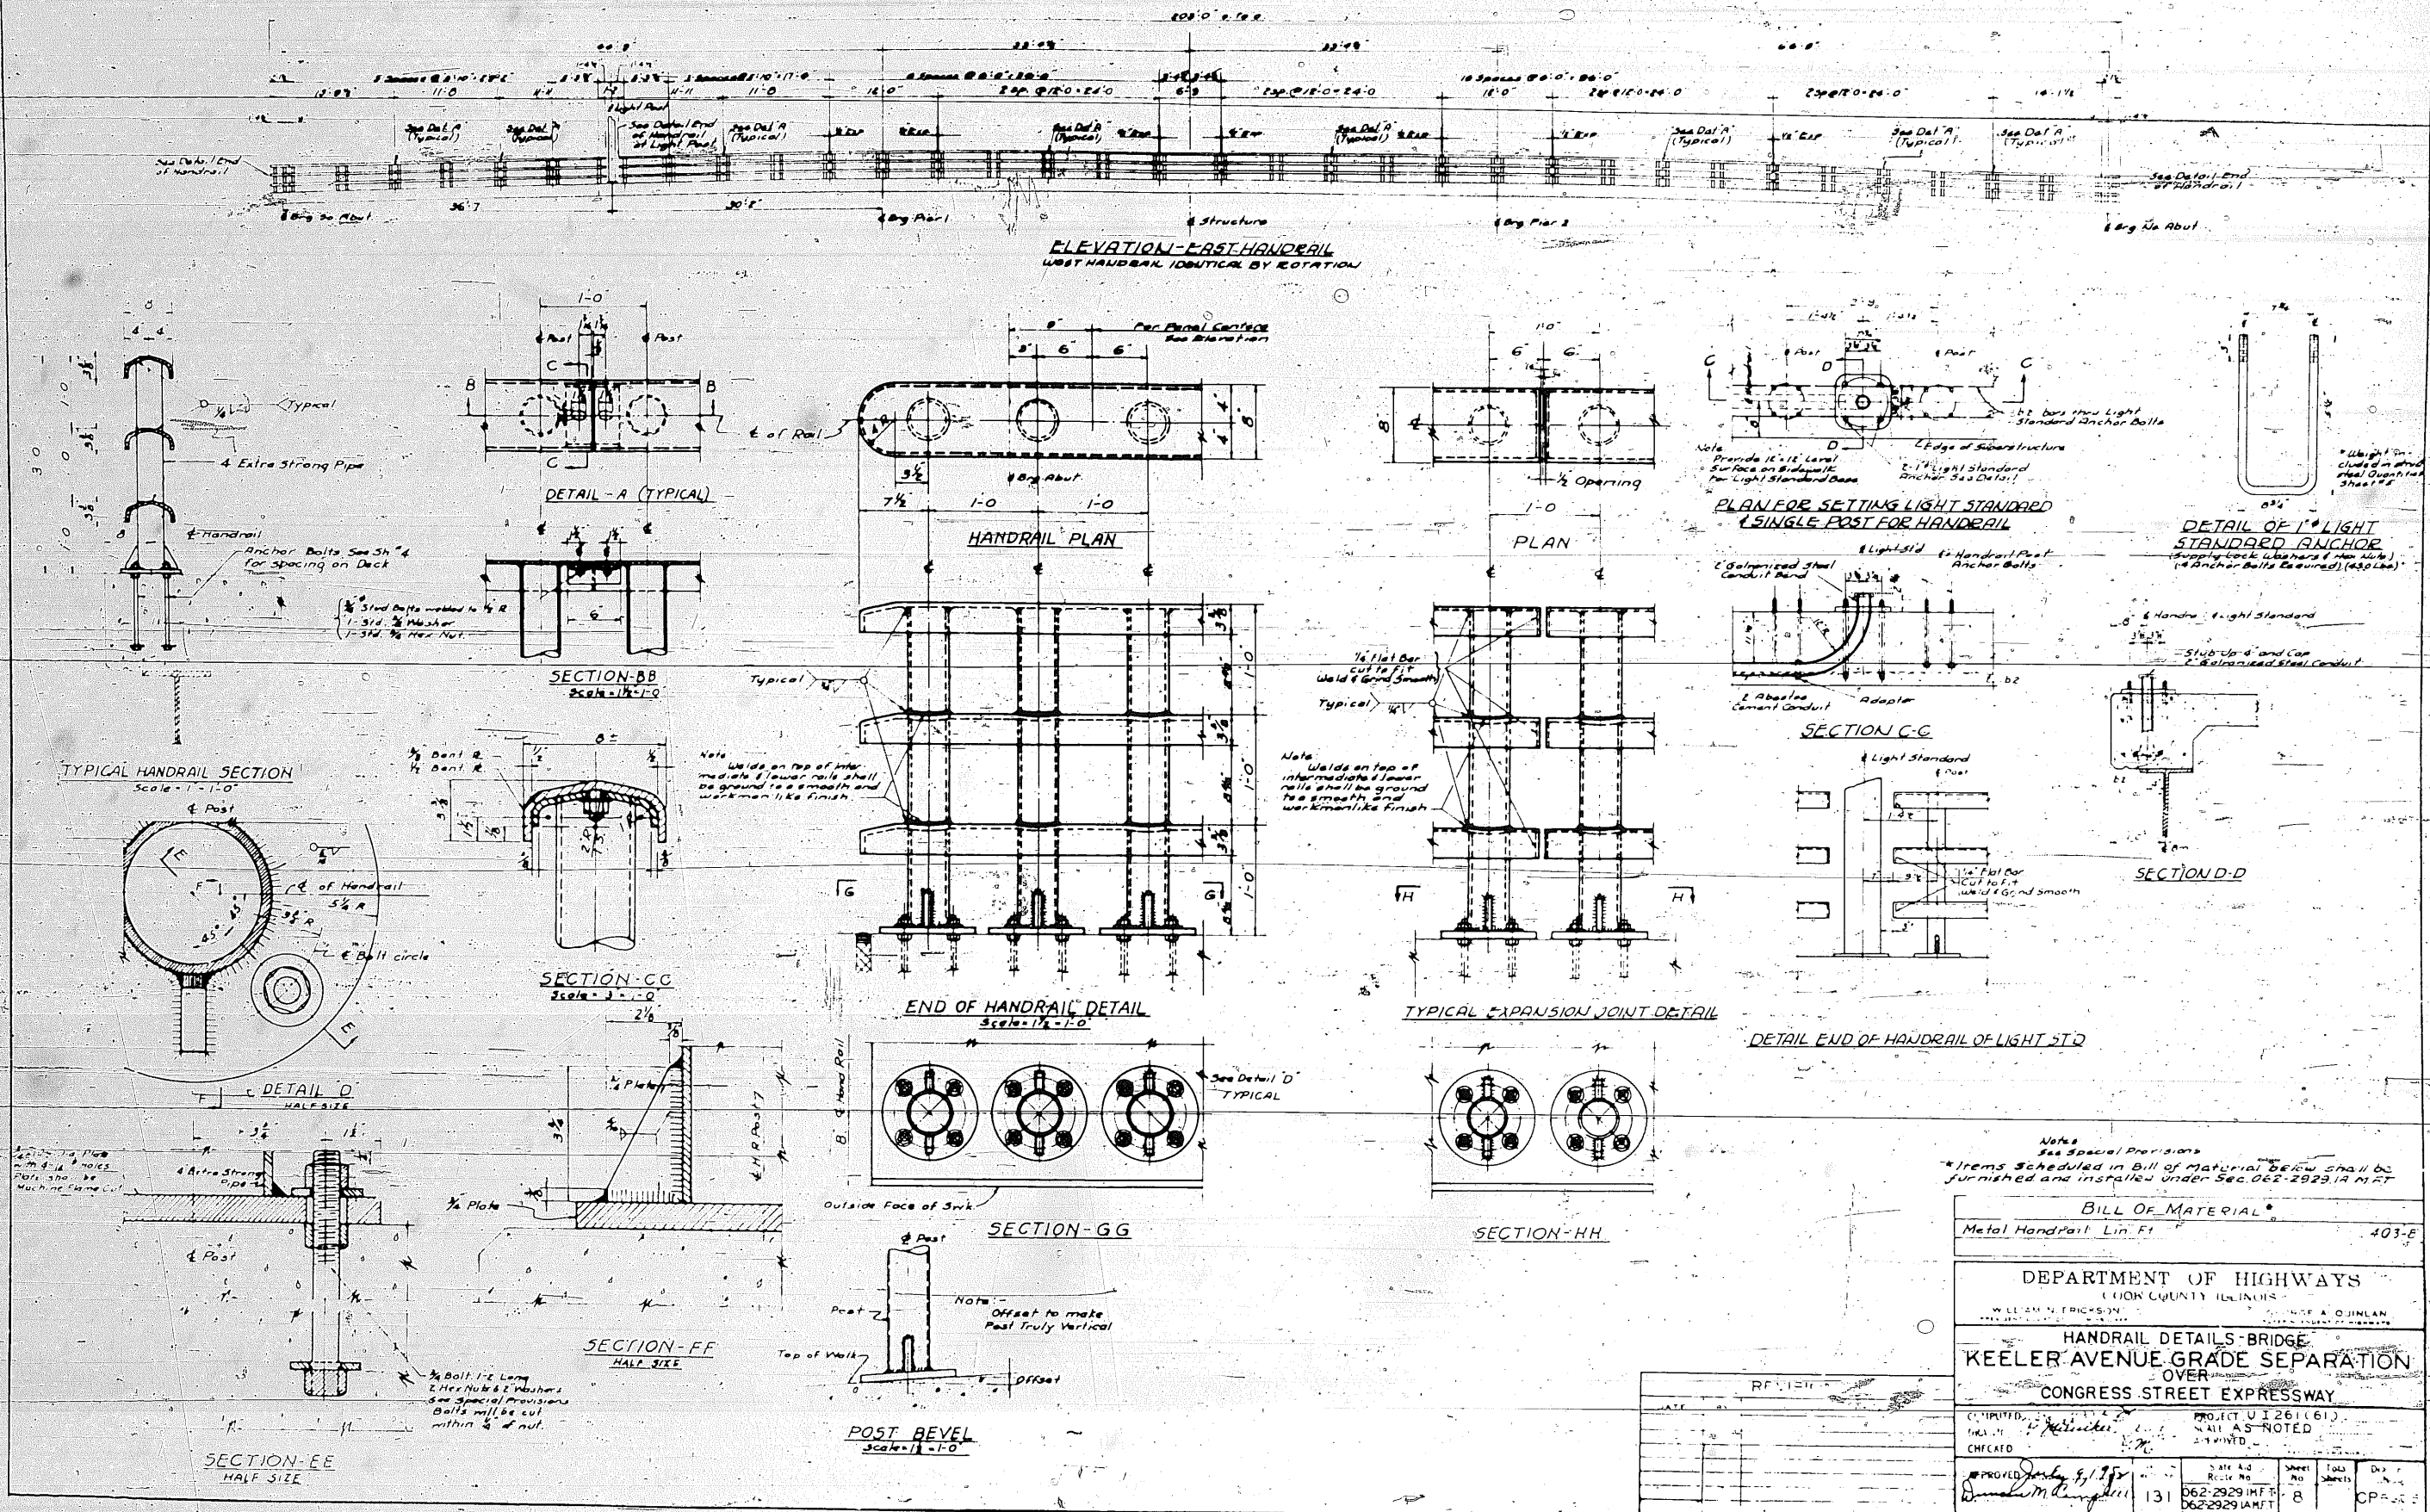

Notes
See Special Provisions

*Items Scheduled in Bill of Material Shall be
furnished and installed under Sec. 062-2929.1A M.T.

BILL OF MATERIAL

Metal Handrail Lin Ft

403.8

DEPARTMENT OF HIGHWAYS

COOK COUNTY ILLINOIS

WILLIAM E. FRICKSON
PRESIDENT OF BOARD OF SUPERVISORS

JOHN J. O'JINLAN
CLERK OF BOARD OF SUPERVISORS

HANDRAIL DETAILS-BRIDGE

KEELER AVENUE GRADE SEPARATION
OVER

CONGRESS STREET EXPRESSWAY

COMPLETED
DATE: 11/1/75
CHECKED: [Signature]

PROJECT: UI 261(61)
MAIL AS NOTED
DATE: 11/1/75

APPROVED: [Signature]
[Signature]

DATE AND
ROUTE NO.
062-2929.1A M.T.

131

SHEET
NO.


8

TOTAL
SHEETS


8

DES. BY
A. J.

CPR 2

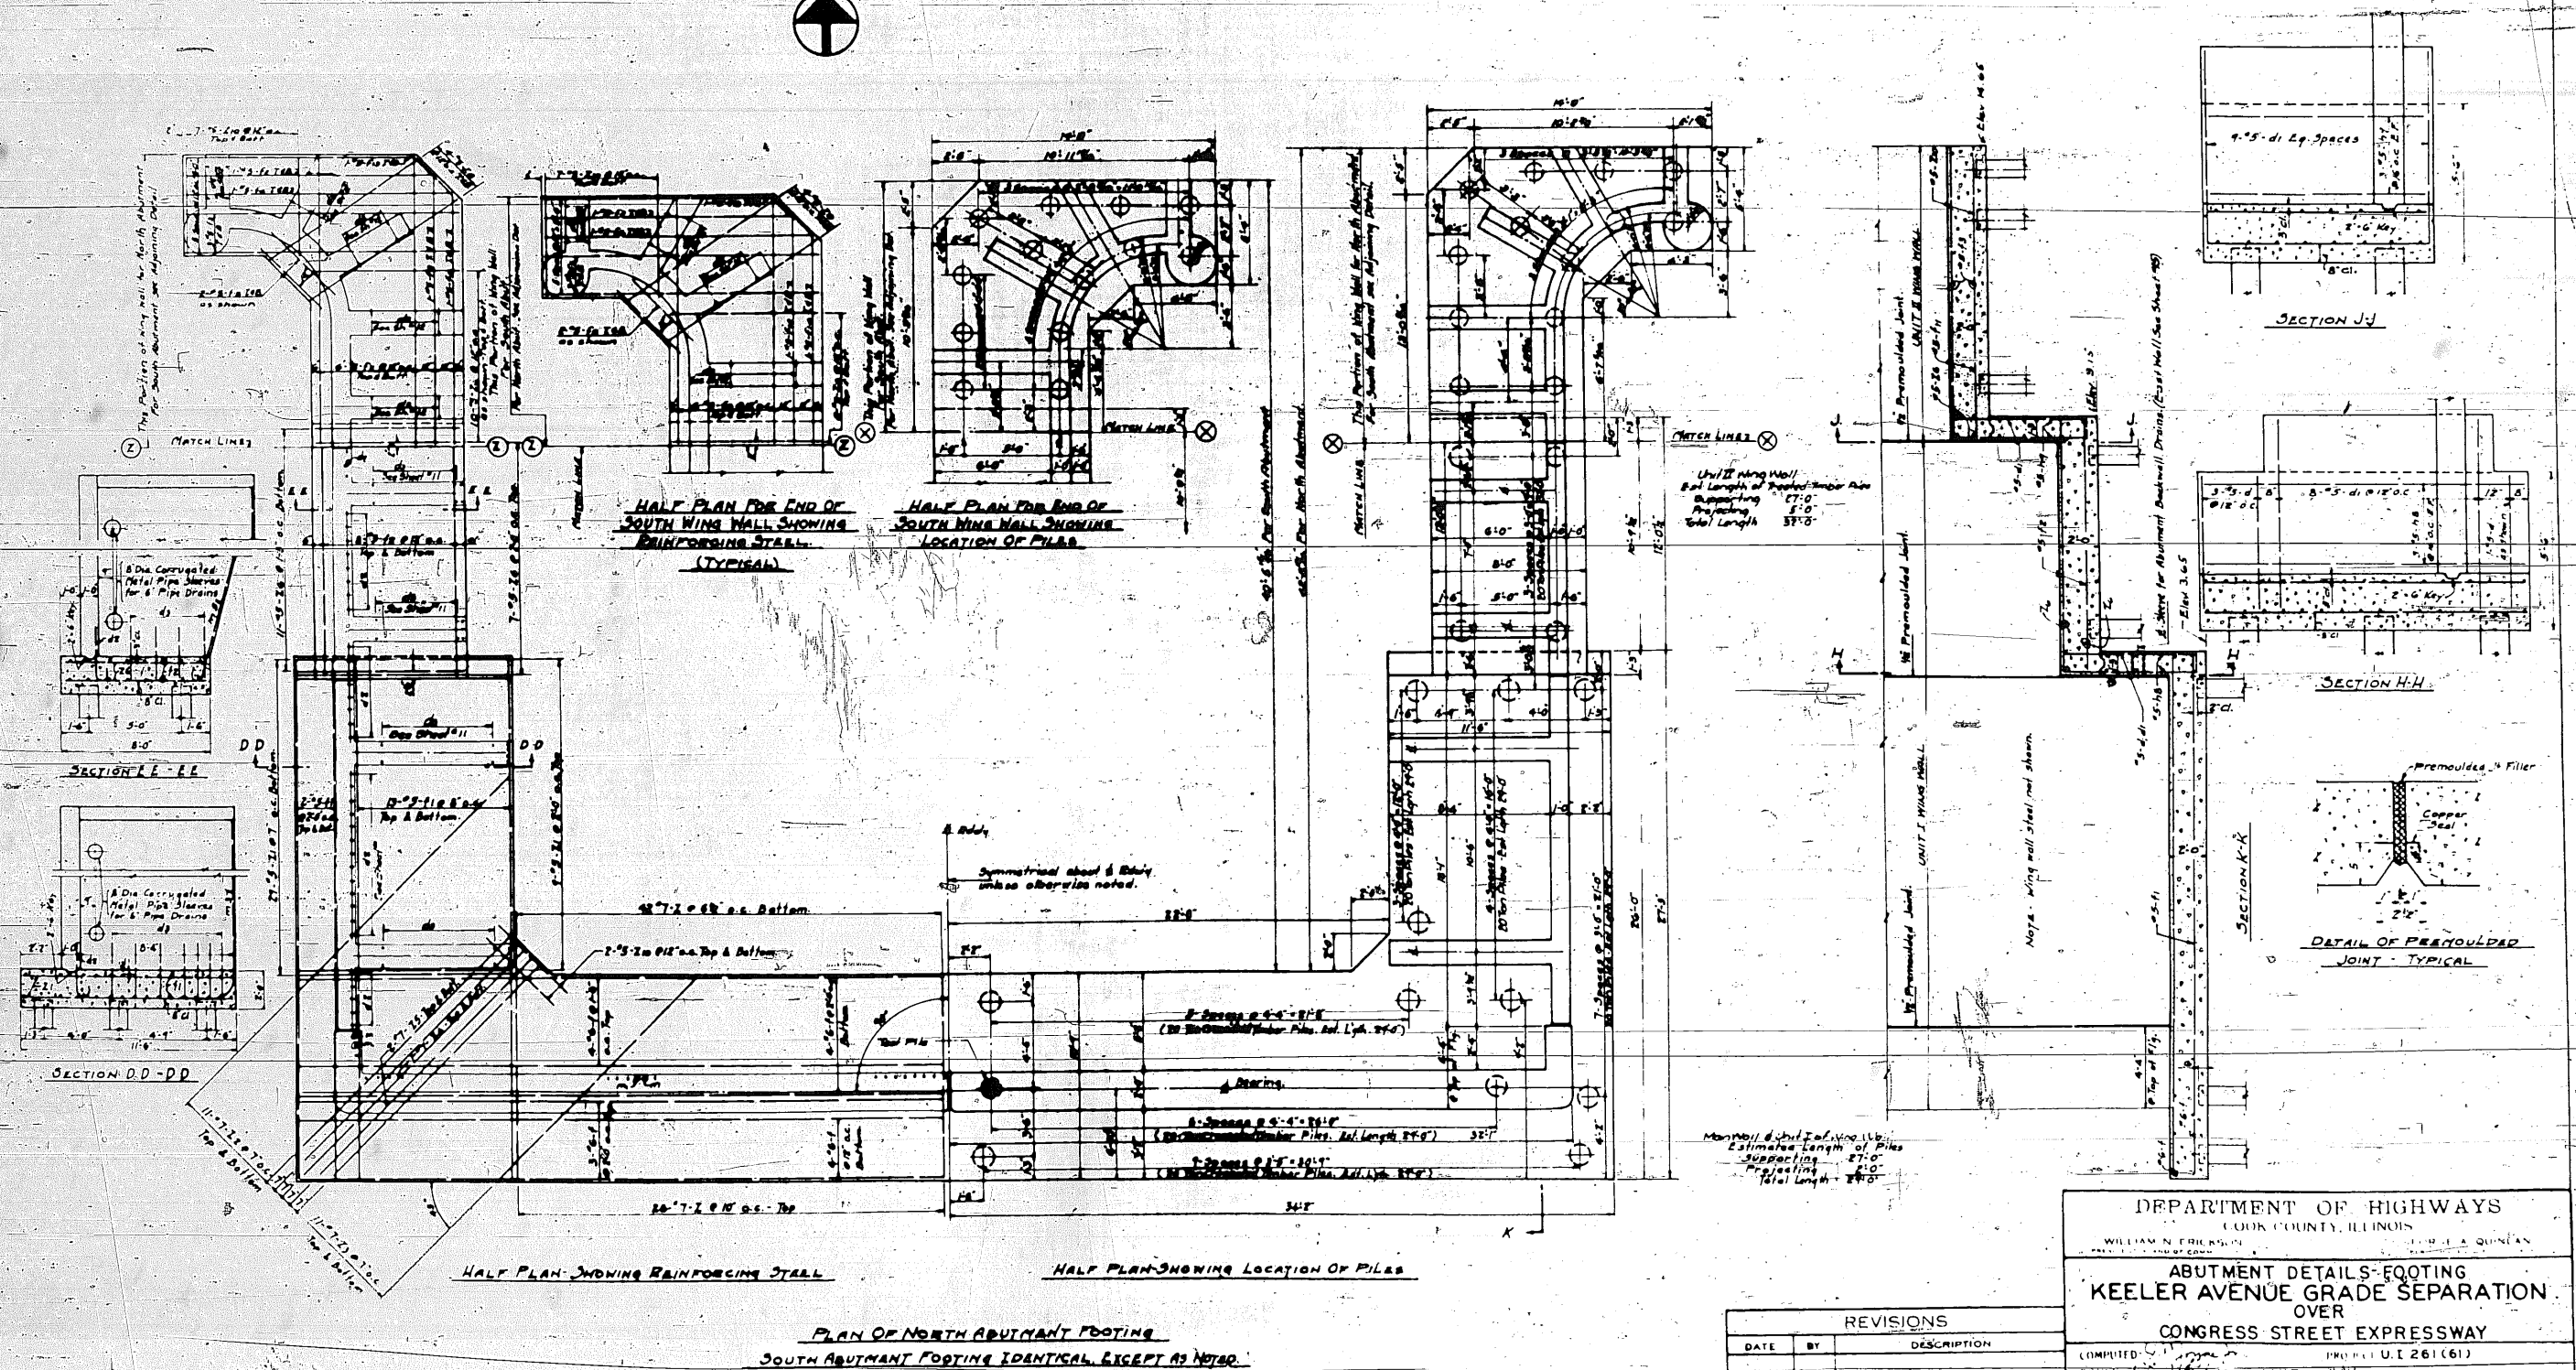
[illegible]

DEPARTMENT OF HIGHWAYS COOK COUNTY, ILLINOIS WILLIAM N. CROOKER CHIEF ENGINEER				
ABUTMENT DETAILS-FOOTING KEELER AVENUE GRADE SEPARATION OVER CONGRESS STREET EXPRESSWAY				
COMPLETED <i>7/1/55</i> DRAWN <i>W. H. F.</i> CHECKED <i>W. H. F.</i>		PROJECT U. S. 261 (61) SHEET NO. 1 APPROVED		
APPROVED <i>July 9, 1955</i> <i>W. M. Campbell</i>	SHEET NO. 131	STATE AND ROUTE NO. 062-29291 W.F.T. 062-29291A W.F.T.	SHEET NO. 9	TOTAL SHEETS 10
		DRAWING NO. CP 1000		

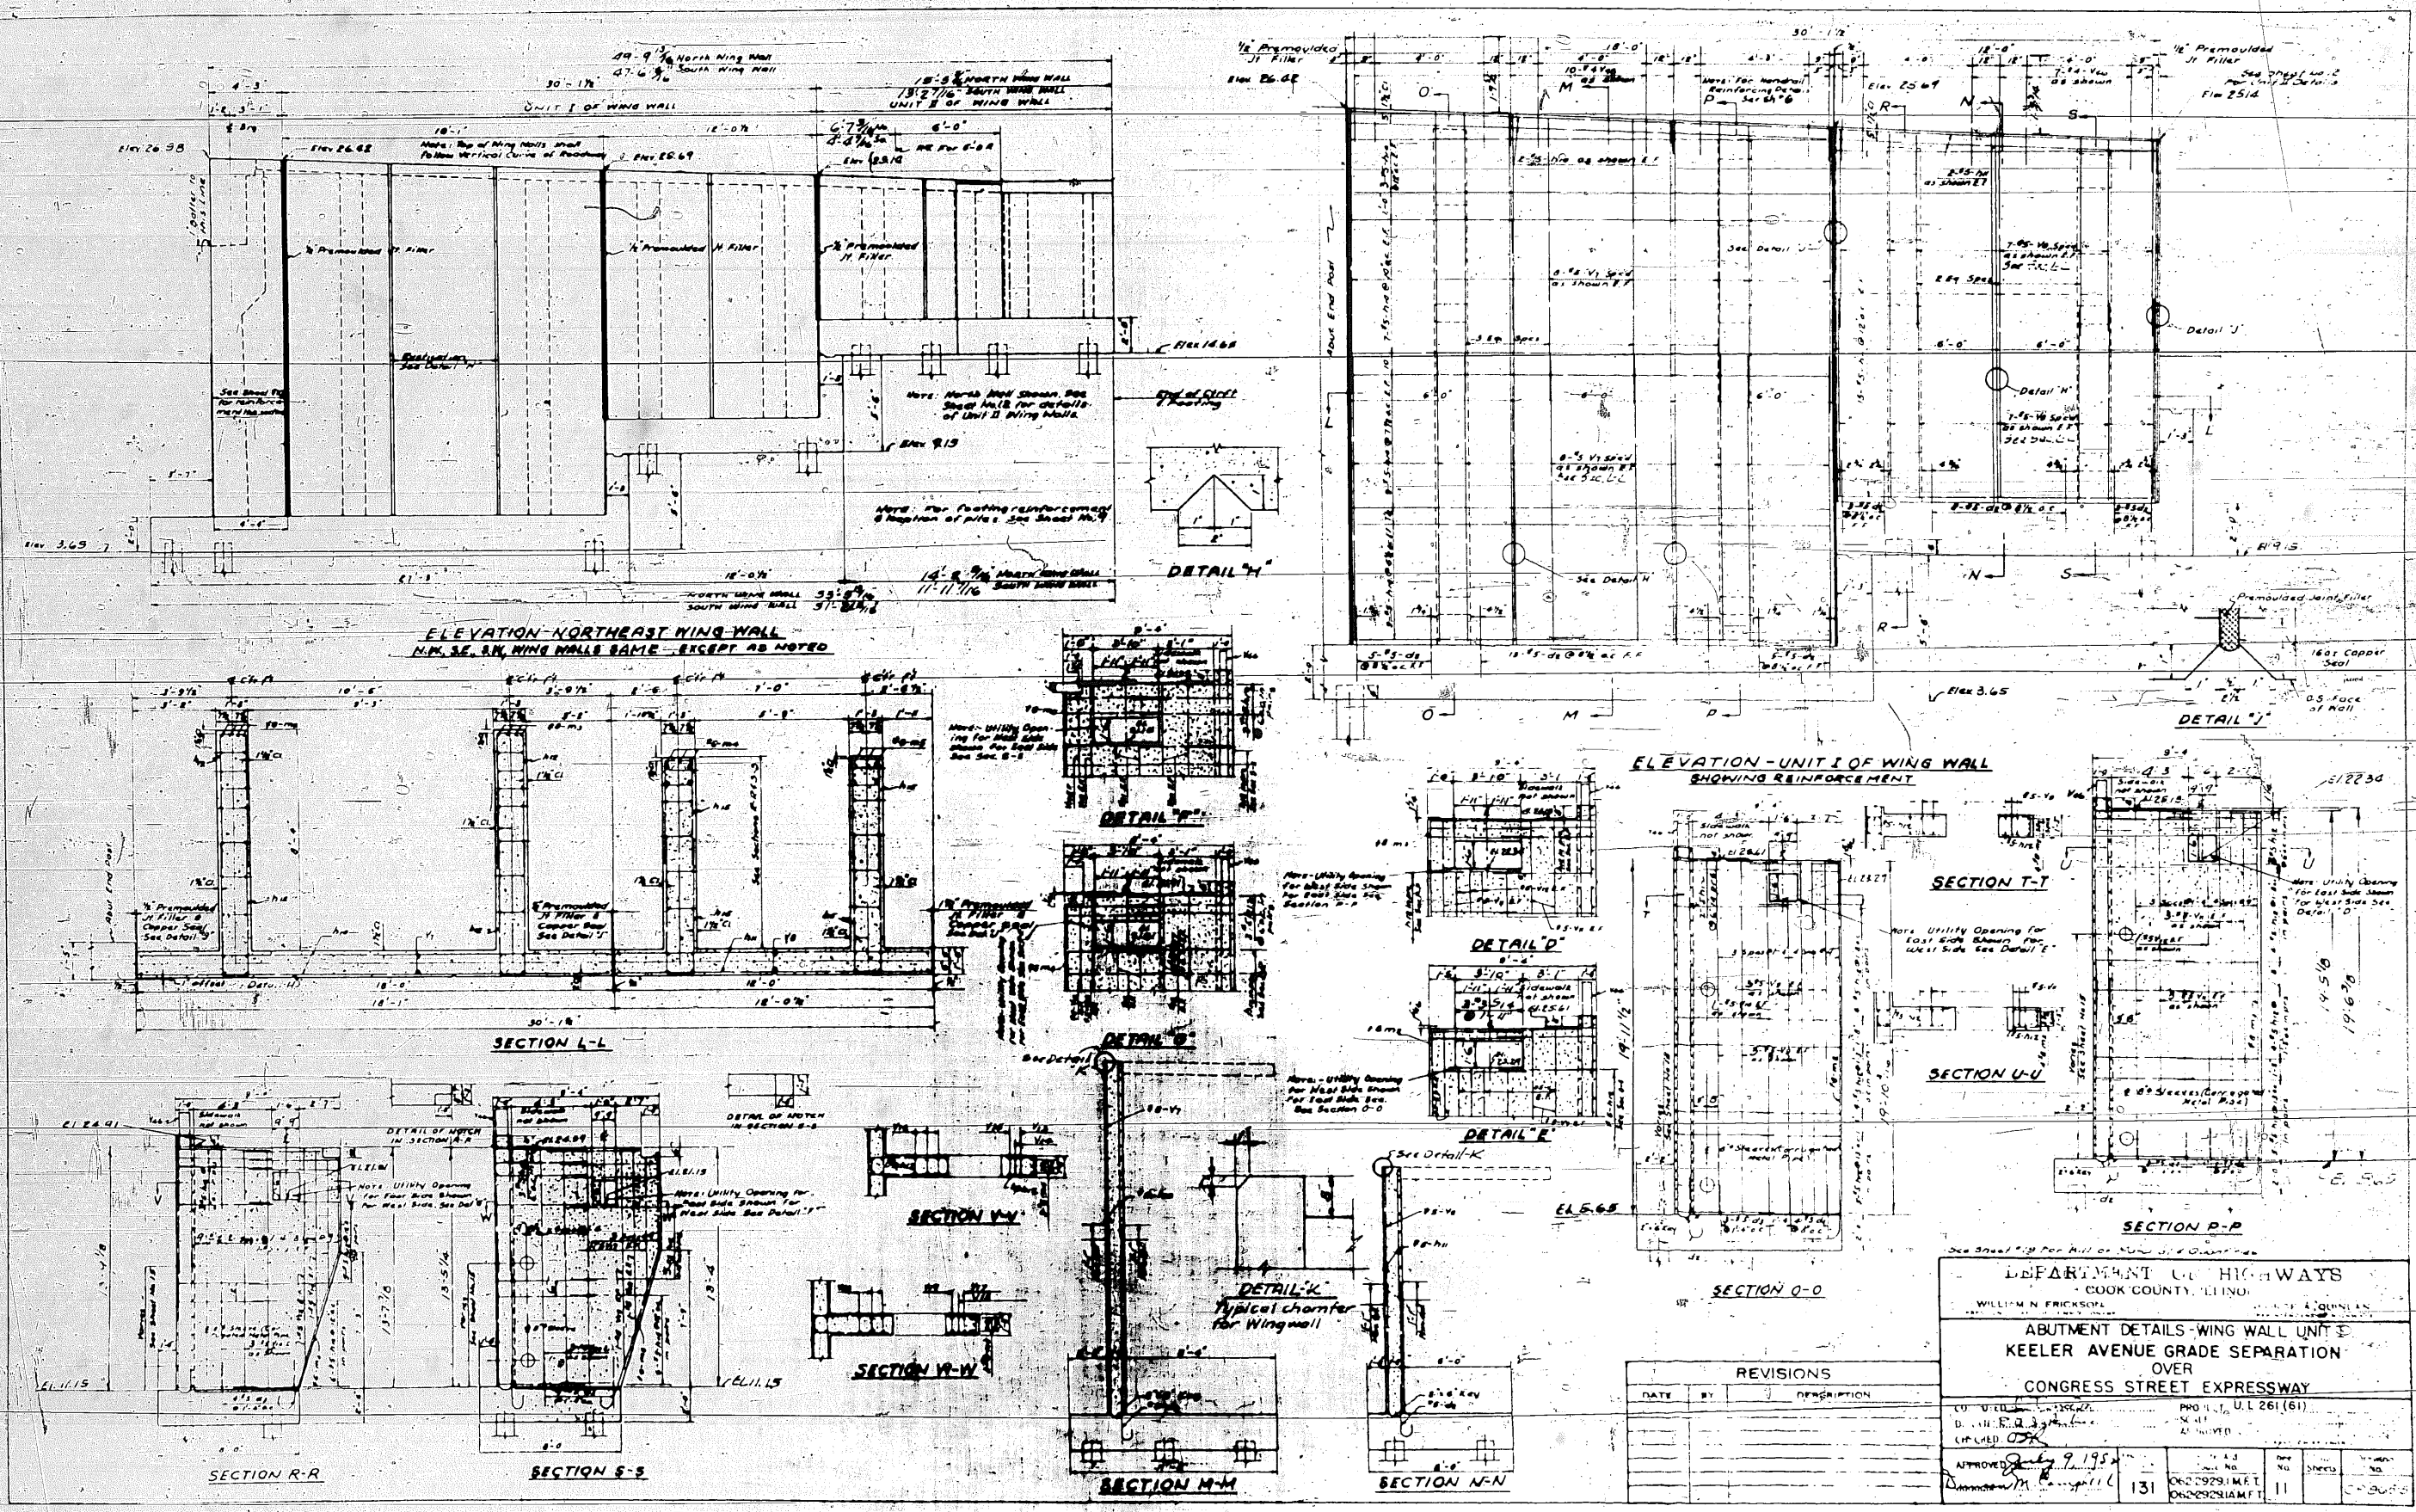


REVISIONS		
DATE	BY	DESCRIPTION

DEPARTMENT OF HIGHWAYS COOK COUNTY, ILLINOIS WILLIAM N. FRICKSON, COUNTY ENGINEER			
ABUTMENT DETAILS - WING WALL UNIT 1 KEELER AVENUE GRADE SEPARATION OVER CONGRESS STREET EXPRESSWAY			
CO. 1111 D. 1111 CH. 1111	PROJ. 1111 SHEET 1111 OF 1111	U.L. 261 (61) APPROVED 9/19/54 131	NO. 1111 SHEET 1111 OF 1111

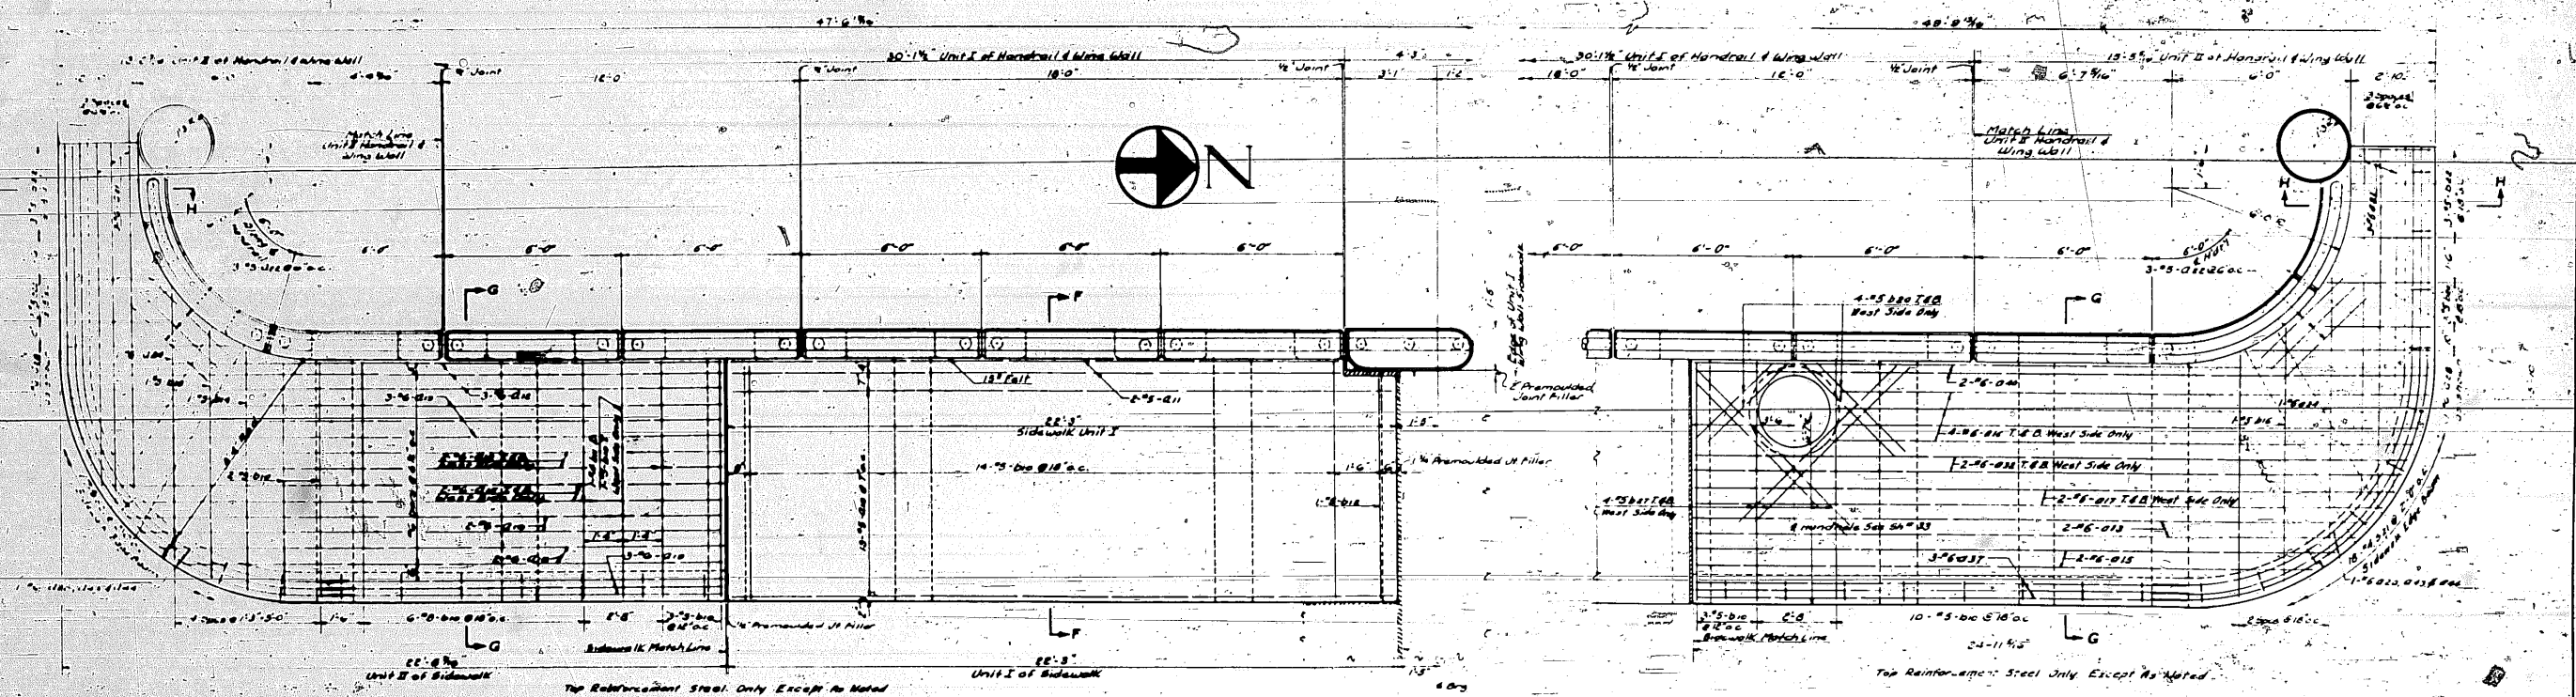

Note: East & West Side of South Unit II Handrail & Sidewalk Opposite Hand Except As Noted.


Note: East & West Sides of North Unit II Handrail & Sidewalk Opposite Hand Except As Noted.

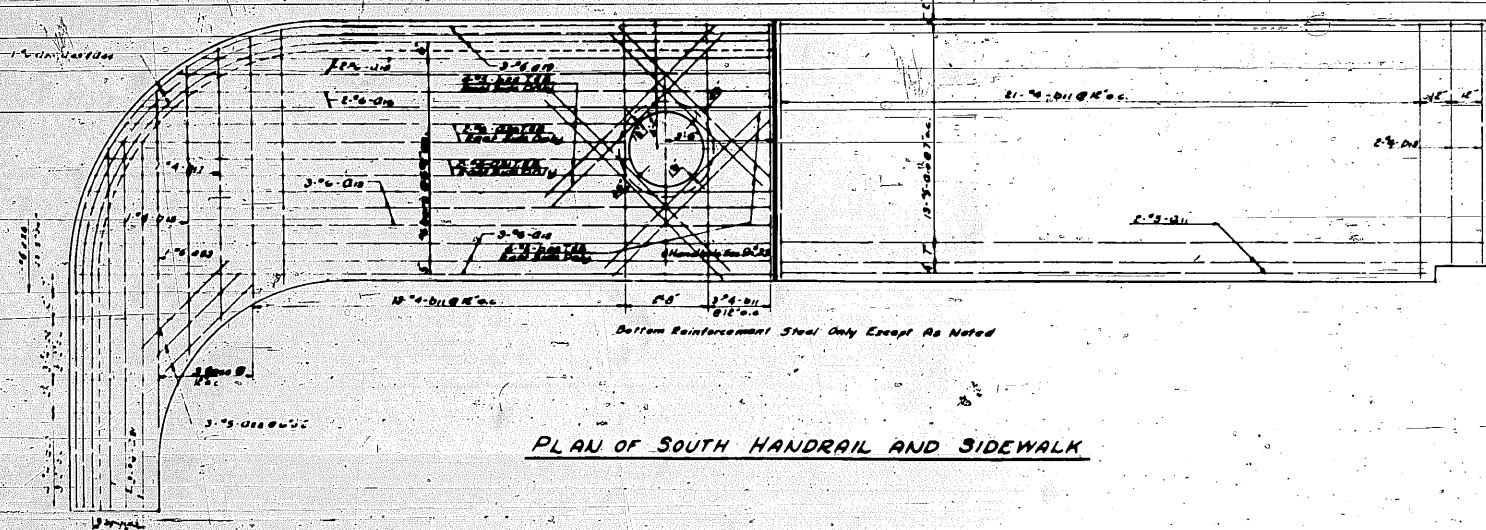


Note: Unit I of Handrail & Unit I of Sidewalk Symmetrical by Rotation.

PLAN OF SOUTH HANDRAIL AND SIDEWALK


PLAN OF NORTH HANDRAIL AND SIDEWALK

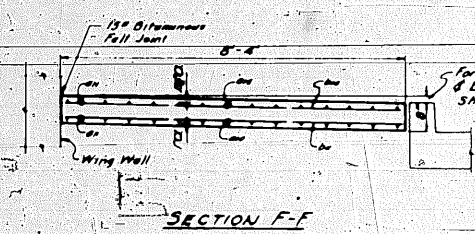

SECTION F-F

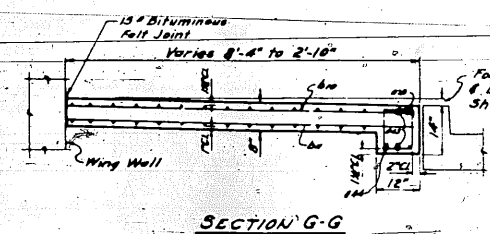


SECTION G-G

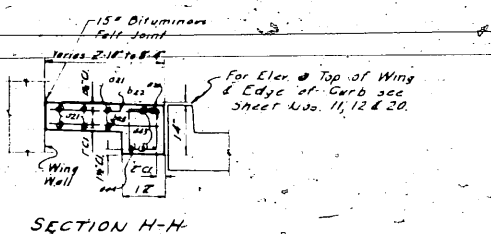


SECTION H-H


Note: Bar Details & Bill of Materials on Sheet No. 19

DEPARTMENT OF HIGHWAYS	
COCK COUNTY, ILLINOIS	
WILLIAM N. ERICKSON PRESIDENT BOARD OF COMMISSIONERS	GEORGE A. QUINN, JR. ENGINEER
ABUTMENT DETAILS: WING WALL, SIDEWALK & HANDRAIL	
KEELER AVENUE GRADE SEPARATION	
OVER	
EAST EXPRESSWAY	
COMPUTED	PROJECT
DRAWN	SCALE
CHECKED	APPROVED
APPROVED	DATE
State Aid Route No.	Sheet No.
Project No.	Total Sheets
Drawn No.	

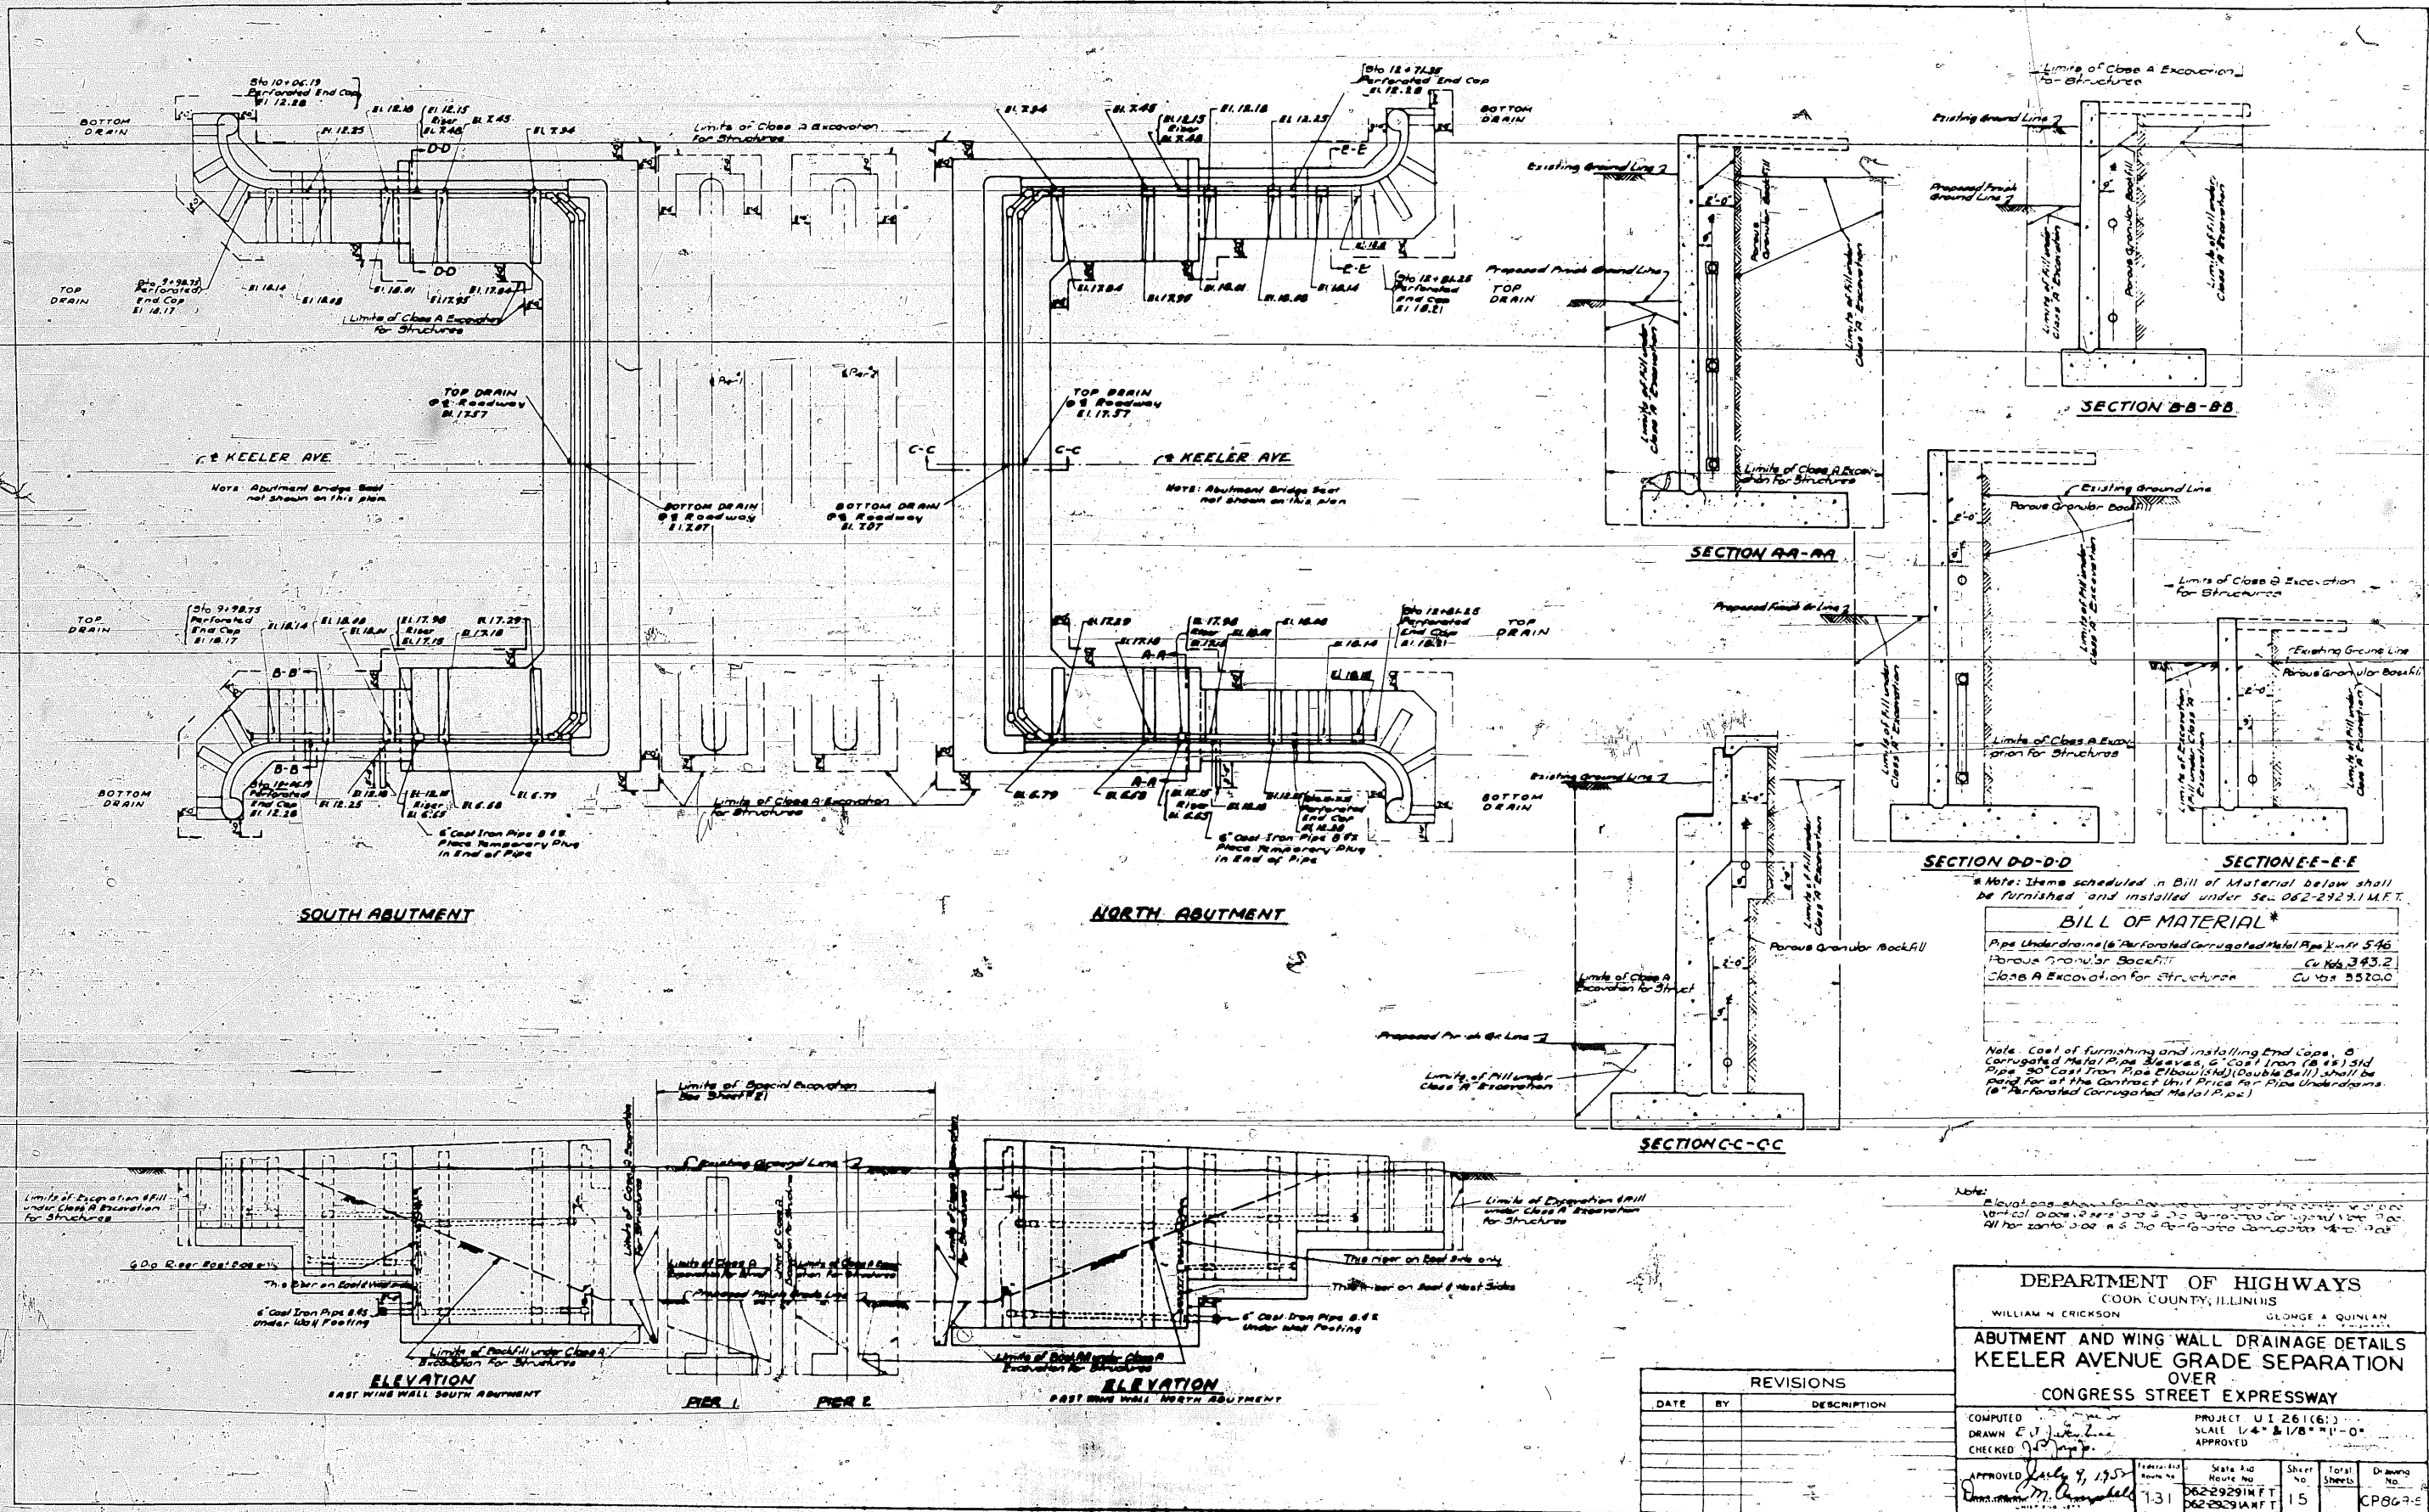


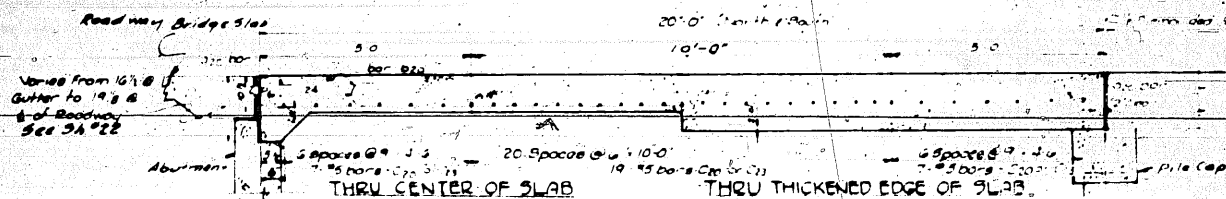


SECTIONAL VIEW OF TWO REINFORCED SLABS

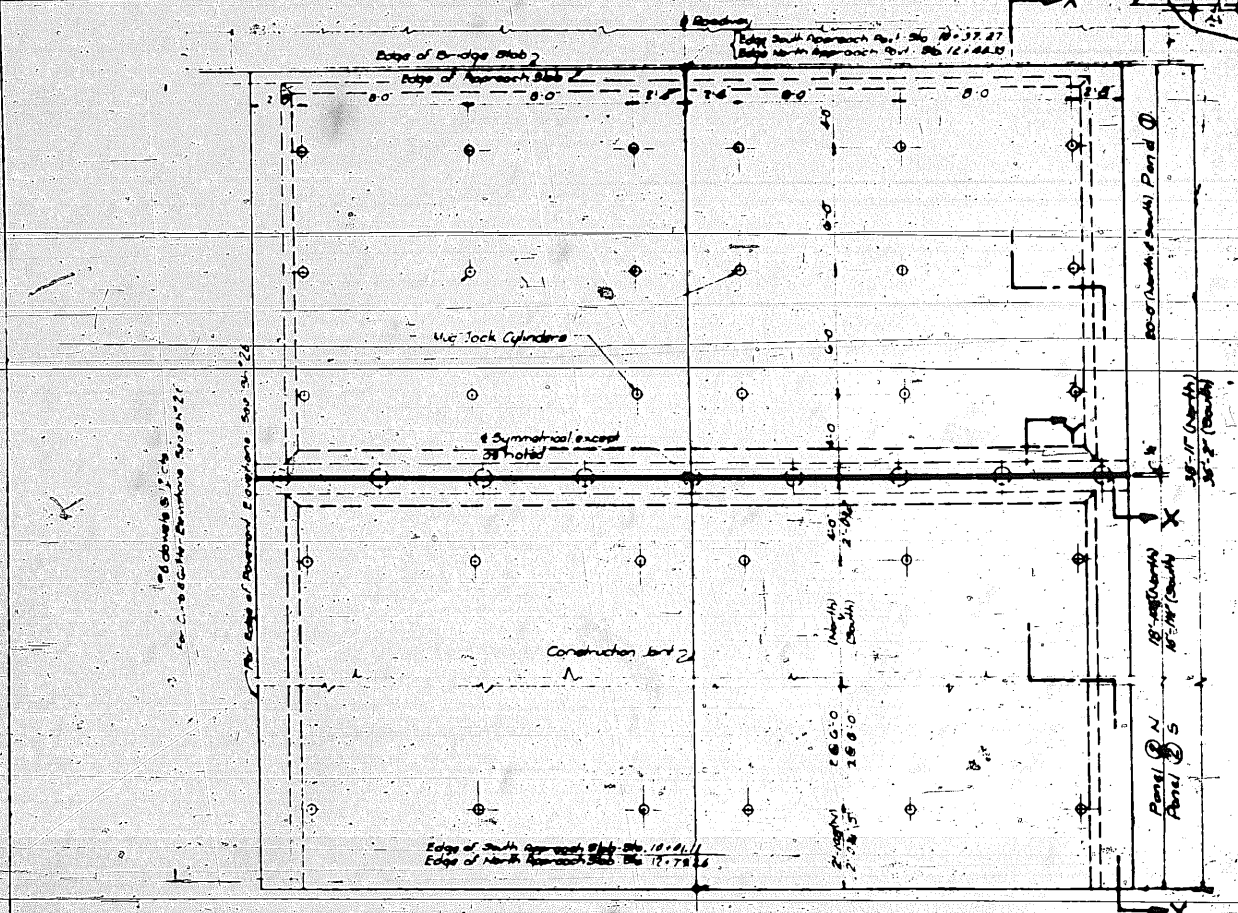


PLAN-NORTH APPROACH SLAB
SOUTH APPROACH SLAB SAME ROTATED 180°

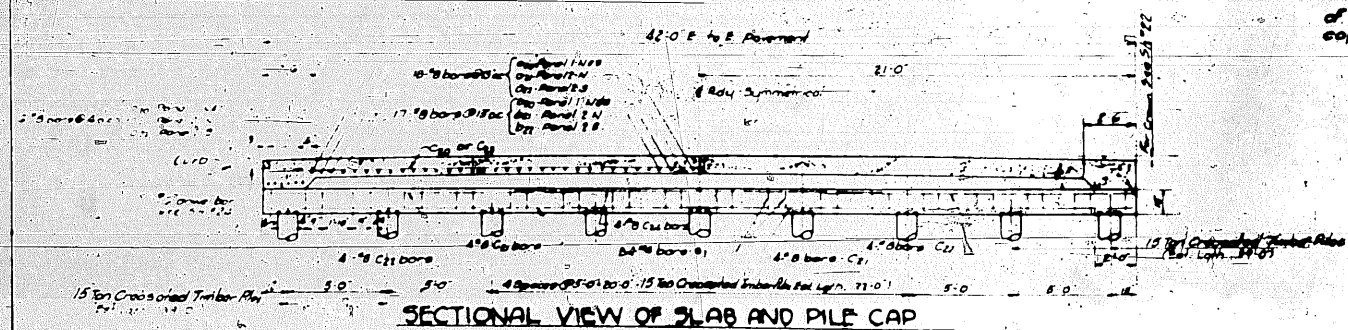


SECTIONAL VIEW OF SLAB AND PILE CAP

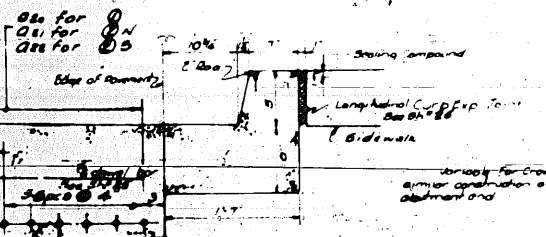

TYPICAL CURB SECTION
AT BRIDGE

 

DETAIL OF
MUD JACK CYLINDER

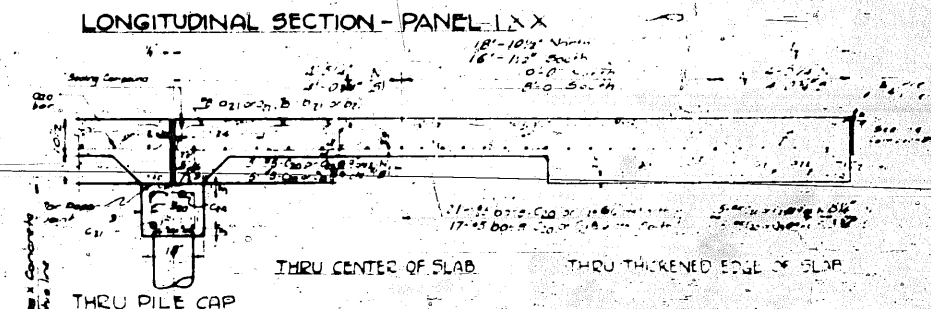

LONGITUDINAL SECTION - PANEL 2 Y-Y
(TYPICAL)

[illegible]

Note: Items scheduled from 6 A.M. through 9:00 AM are furnished under Sec 862 20291.

* Use under bond in the State of California

NOTES

The elabo shall be paid for at the contract unit price for AC Concrete Pavement (14% - 10% - 14%)

The Concrete Cap shall be paid for at the contract unit price for Class X Concrete.

All Reinforcement Bars, on thing the curb and gutter bars, shall be paid for at the contract unit price for Reinforcement Bars

The Mud Jack Cylinders shall be furnished and installed by the Bridge Contractor and included in their contract unit price for AC Concrete Pavement (14% - 10% - 14%)

The 1/4" Premoulded Joint Filler and Top Paper Joint over the Bent Cap shall be included in the contract unit price for AC Concrete Pavement (14% - 10% - 14%)

Premoulded Joint Filler shall conform to any of the fillers specified in Articles 115.67 or 115.68 of the Standard Specifications for Road and Bridge Construction.

All piles shall be driven to obtain a minimum penetration of 10'-0" into stratum of solid material regardless of bearing capacity developed.

[illegible]

DEPARTMENT OF HIGHWAYS
COOK COUNTY, ILLINOIS

WILLIAM H. FRICKMAN
 PRESIDENT BOARD OF SUPERVISORS

GEORGE A. GUINLAN
 CHIEF OF BUREAU OF HIGHWAYS

**APPROACH SLAB
 KEELER AVENUE GRADE SEPARATION
 OVER
 CONGRESS STREET EXPRESSWAY**

COMPLETED 11/28/67 PROJECT 6-2-67(61)
 DRAWN ALA SCALE AS SHOWN
 CHECKED ALA APPROVED _____
 DATE 11/28/67

APPROVED	DESIGNED BY	STATION AND REMARKS	SHEET NO.	TOTA SHEETS	DRAWN BY
<u>11/28/67</u> <u>W. H. Frickman</u> PRESIDENT BOARD OF SUPERVISORS	15	6-2-67(61) 15	6	6	CP-1

ESTIMATED PILE LENGTHS			
Projecting	8'-0"	Projecting	14'-0"
Supporting	20'-0"	Supporting	20'-0"
Total	28'-0"	Total	34'-0"


TYPE-T2


TYPE-T3


TYPE-T5


TYPE-T6


TYPE-S10


TYPE-S11


TYPE-S12


TYPE-S13


TYPE-S2


TYPE-S4


TYPE-I


TYPE-C


TYPE-5


TYPE-6


TYPE-7


TYPE-8


TYPE-9


TYPE-10


TYPE-11


TYPE-12


TYPE-13


TYPE-14


TYPE-15


TYPE-16


TYPE-17


TYPE-18


TYPE-19


TYPE-20


TYPE-21


TYPE-22

TYPE-23

TYPE-24

TYPE-25

TYPE-26

TYPE-27

TYPE-28

TYPE-29

TYPE-30

TYPE-31

TYPE-32

TYPE-33

TYPE-34

TYPE-35

DEPARTMENT OF HIGHWAYS COOK COUNTY, ILLINOIS WILLIAM N. FRICKER, CHIEF ENGINEER GEORGE A. DUNLAP, ASSISTANT CHIEF ENGINEER				
ABUTMENT BILL OF MATERIAL AND BAR SCHEDULE KEELER AVENUE GRADE SEPARATION OVER CONGRESS STREET EXPRESSWAY				
COMPUTED BY BRYAN A. McLeister CHECKED		PROJECT W. 1261 (61) SCALE APPROVED		
APPROVED <i>July 9, 1961</i> <i>Donald M. Campbell</i>	131	DATE JULY 29 062-2928 IM.FT 062-2928 IM.FT	SHEET 19	TOTAL SHEETS 35

