


SIGN DETAIL
1:75

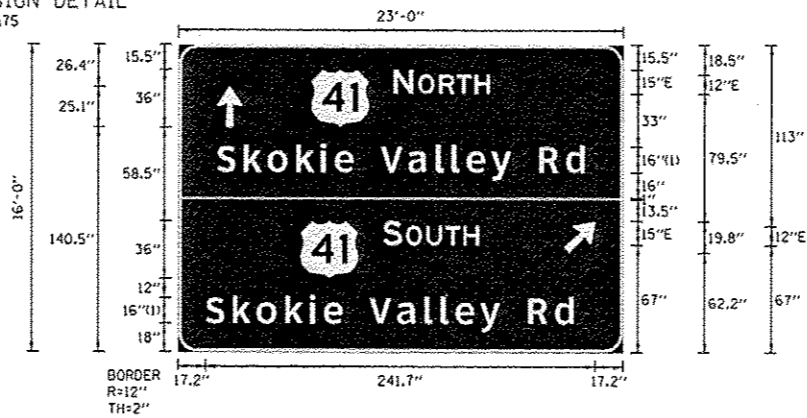

SIGN NUMBER	EB-TR-03
WIDTH x HGHT.	23'-0" x 16'-0"
BORDER WIDTH	2"
CORNER RADIUS	12"
MOUNTING	Overhead
BACKGROUND	TYPE: ZZ Sheeting COLOR: Green / Green
LEGEND/BORDER	TYPE: ZZ Sheeting COLOR: White/White

AR_Type A	0	23.9	140.5	15.9	25.1
ML_4	0	82.5	140.5	36	36
AR_Type A	315	239.1	62.2	15.9	25.1
ML_4	0	75.9	46	36	36

FONT:
(1) ClearviewHwy-5-W

Panel Style: guide_fw_intermediate.ssi
M.U.T.C.O., 2009 Edition

Panel Style: guide_fw_intermediate.ssi
Dimensions are in inches, tenths Letter locations are panel edge to lower left corner

LETTER POSITIONS (X)															LENGTH	SERIES/SIZE
N	O	R	T	H												E 2000
133.5	148.8	161.7	172.7	183.8												59.9 15.12
S	K	O	K	I	E	V	A	L	L	E	Y	R	D			ClearviewHwy-5-W
23.9	40.6	55.4	73.2	88.4	97.2	109	125.7	142.7	159.7	169.6	178.8	194.1	206.7	223.8	240.5	228.3 16/13
S	O	U	T	H												E 2000
126.9	141.3	154.2	165.9	177												59.8 15.12
S	K	O	K	I	E	V	A	L	L	E	Y	R	D			ClearviewHwy-5-W
17.2	33.9	48.7	66.5	81.7	90.5	102.3	119	136	153	162.9	172.1	187.4	200	217.1	233.8	228.3 16/13

FILES 8/1/2013 3:57:44 PM

GRAEF 3501 N. Elgin Road Suite 200
Chicago, Illinois 60631
(773) 399-0112

USER NAME = 1495	DESIGNED - EF	REVISED -
PLOT SCALE = 10.0000 1/ in.	DRAWN - EF	REVISED -
PLOT DATE = 8/1/2013	CHECKED - RS	REVISED -
	DATE - 08/01/2013	REVISED -

**STATE OF ILLINOIS
DEPARTMENT OF TRANSPORTATION**

OVERHEAD SIGN STRUCTURE REPAIR & REPLACEMENT
SIGN PANEL PLAN - LOCATION 3
SCALE: N.T.S. SHEET 3 OF 9 SHEETS STA. TO STA.

F.A. RTE.	SECTION	COUNTY	TOTAL SHEETS	SHEET NO.
VAR. DI OVD SIN STR REPL14-30	VARIOUS	VARIOUS	53	40
			CONTRACT NO.	46291
ILLINOIS FED. AID PROJECT				