


SIGN DETAIL
1:75

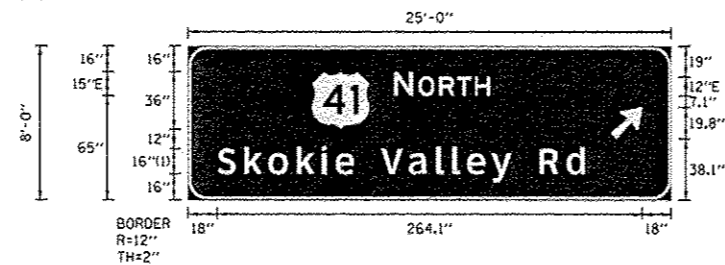

BORDER
R=12"
TH=2"

FONT:
(1) ClearviewHwy-5-W

Panel Style: guide.fwy_intermediate.ssi
M.U.T.C.D.: 2009 Edition


Panel Style: guide.fwy_intermediate.ssi
Dimensions are in Inches.tenths Letter locations are panel edge to lower left corner

SIGN NUMBER	EB-TR-05
WIDTH x HIGHT	25'-0" x 8'-0"
BORDER WIDTH	2"
CORNER RADIUS	12"
MOUNTING	Overhead
BACKGROUND	TYPE: ZZ Sheeting COLOR: Green
LEGEND/BORDER	TYPE: ZZ Sheeting COLOR: White/White

SYMBOL	ROT	X	Y	WID	HT
ML_4	0	76.6	44	36	36
AR_Type A	315	262.3	38.1	15.3	25.1

LETTER POSITIONS (X)													LENGTH	SERIES/SIZE			
N	O	R	T	H										E 2000			
127.7	143	155.8	166.8	177.9									60	15,12			
S	K	O	K	I	E	V	O	L	I	E	Y	R	D		ClearviewHwy-5-W		
18	34.7	49.5	67.3	82.5	91.3	103.1	119.8	136.8	153.8	163.7	172.9	188.2	200.8	217.9	234.6	228.3	16/13

 8/1/2013 3:57:46 PM



USER NAME = 1485	DESIGNED - EF	REVISED -
DRAWN - EF	CHECKED - RS	REVISED -
PLOT SCALE = 10.0000 ' / in.	DATE - 08/01/2013	REVISED -
PLOT DATE = 8/1/2013		

STATE OF ILLINOIS
DEPARTMENT OF TRANSPORTATION

OVERHEAD SIGN STRUCTURE REPAIR & REPLACEMENT			
SIGN PANEL PLAN - LOCATION 4			
SCALE: N.T.S.	SHEET 4	OF 9 SHEETS	STA. TO STA.

F.A. RTE.	SECTION	COUNTY	TOTAL SHEETS	SHEET NO.
VAR. 01	01 OVD SIN STR REPL14-30	VARIOUS	53	41
				CONTRACT NO. 46291
ILLINOIS FED. AID PROJECT				