
 


FILE PATH = p:\388035-p\m\ae\comon\me\local\p\ae\comon\Documents\01_Americas\Transportation\60269938_Circle\Phase_1\1000_CAD\006_Roadway_Sheets\60W26-Sht-Drain-04

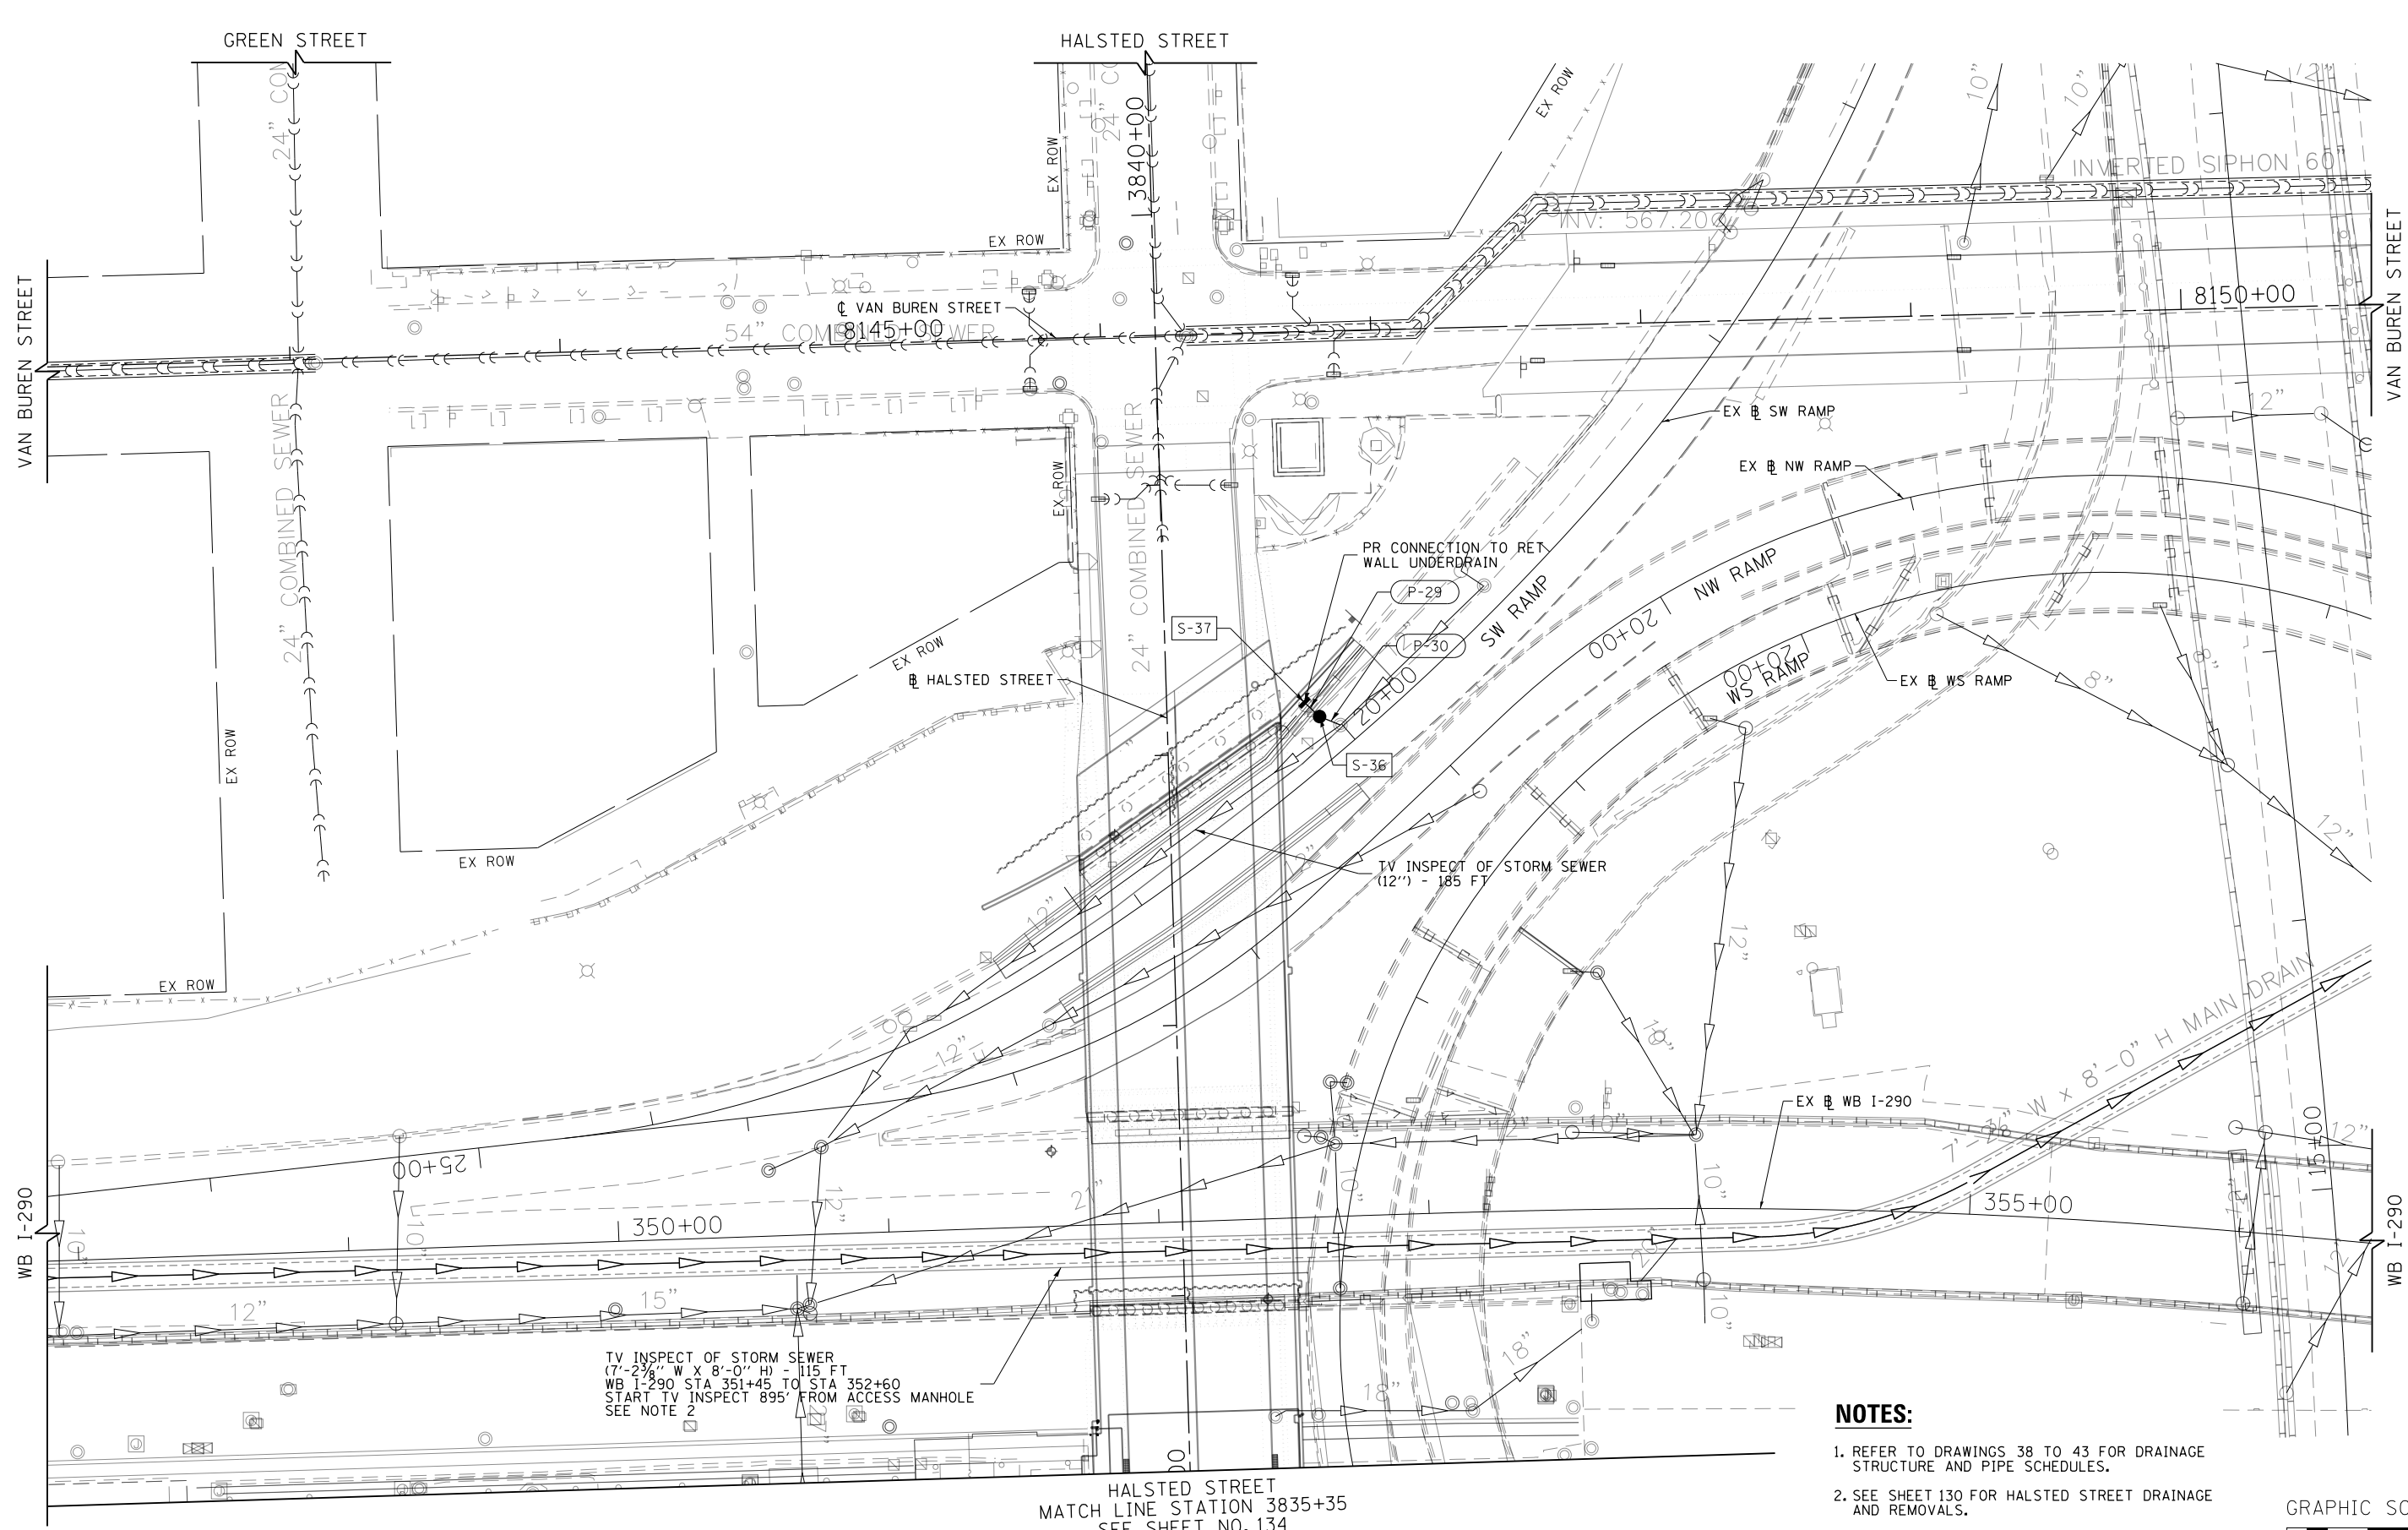

NOTES:

1. REFER TO DRAWINGS 38 TO 43 FOR DRAINAGE STRUCTURE AND PIPE SCHEDULES.
2. SEE SHEET 130 FOR HALSTED STREET DRAINAGE AND REMOVALS.
3. ACCESS MANHOLE FOR TELEVISION IS WB I-290 STA 3704+53, 3' RT (1170163.0950, 1898033.2350)



TV INSPECT OF STORM SEWER
(7'-2 3/8" W X 8'-0" H) - 115 FT
WB I-290 STA 351+45 TO STA 352+60
START TV INSPECT 895' FROM ACCESS MANHOLE
SEE NOTE 2

HALSTED STREET
MATCH LINE STATION 3835+35
SEE SHEET NO. 134



D160W26-Sht-Drain-04
USER NAME = jslavanne
PLOT SCALE = 30.0000' / in.
PLOT DATE = 9/13/2013

DESIGNED - JSL
DRAWN - BAW
CHECKED - JWC
DATE - 9/15/13

REVISED -
REVISED -
REVISED -
REVISED -

**STATE OF ILLINOIS
DEPARTMENT OF TRANSPORTATION**

**DRAINAGE PLAN
I-290**

SCALE: 1"=30' SHEET 4 OF 10 SHEETS STA. TO STA.

F.A.I. RTE.	SECTION	COUNTY	TOTAL SHEETS	SHEET NO.
90/94/290	2013-008R	COOK	559	133
CONTRACT NO. 60W26				
ILLINOIS FED. AID PROJECT				