 


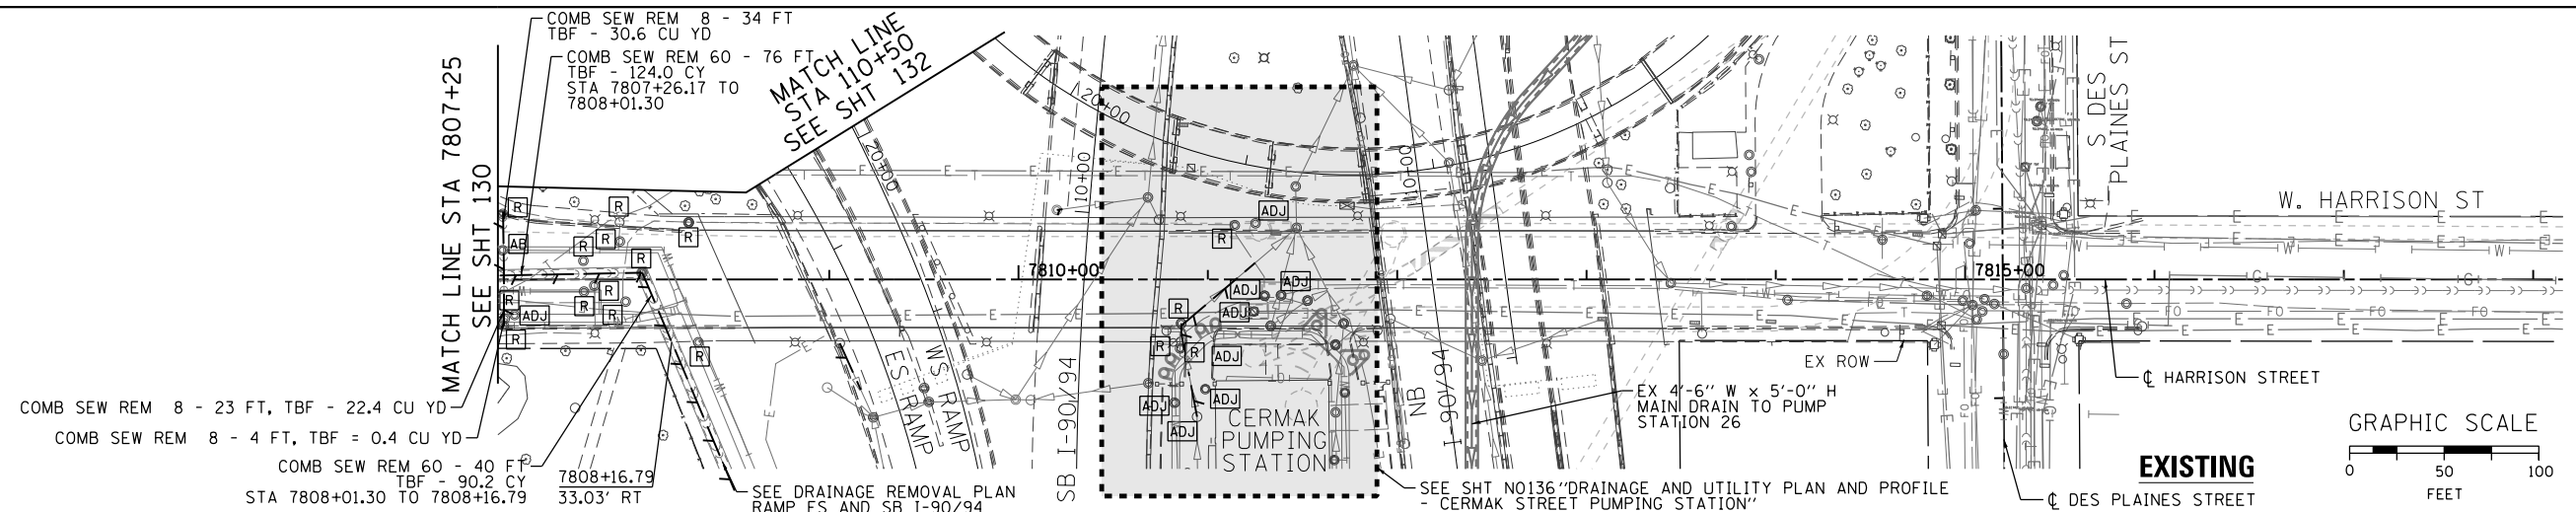



PLAN	SURVEYED	DATE
	PLOTTED	BY
	CHECKED	
	ALIGNED	
	FILED	
	NO.	
	NO.	

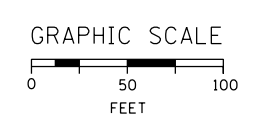

- NOTES:
- SEE LIGHTING, TRAFFIC SIGNAL, AND ITS PLANS FOR REMOVAL AND CONSTRUCTION OF STRUCTURES, DUCTBANKS AND CONDUITS.

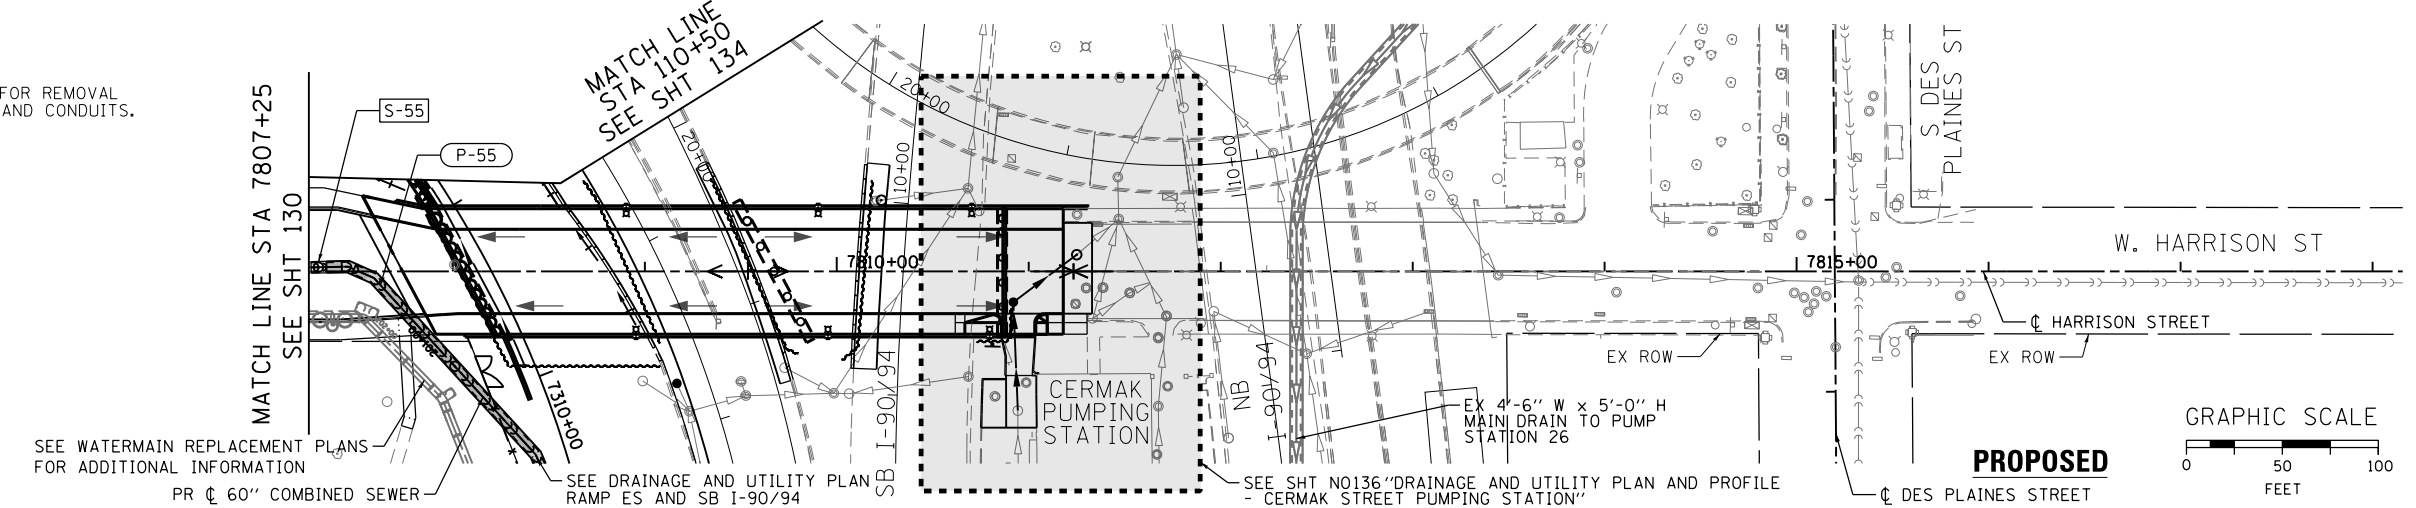

PROFILE	SURVEYED	DATE
	PLOTTED	BY
	CHECKED	
	GRADES	
	STRUCTURE	
	NOT AT THIS OFFICE	
	NO.	
	NO.	

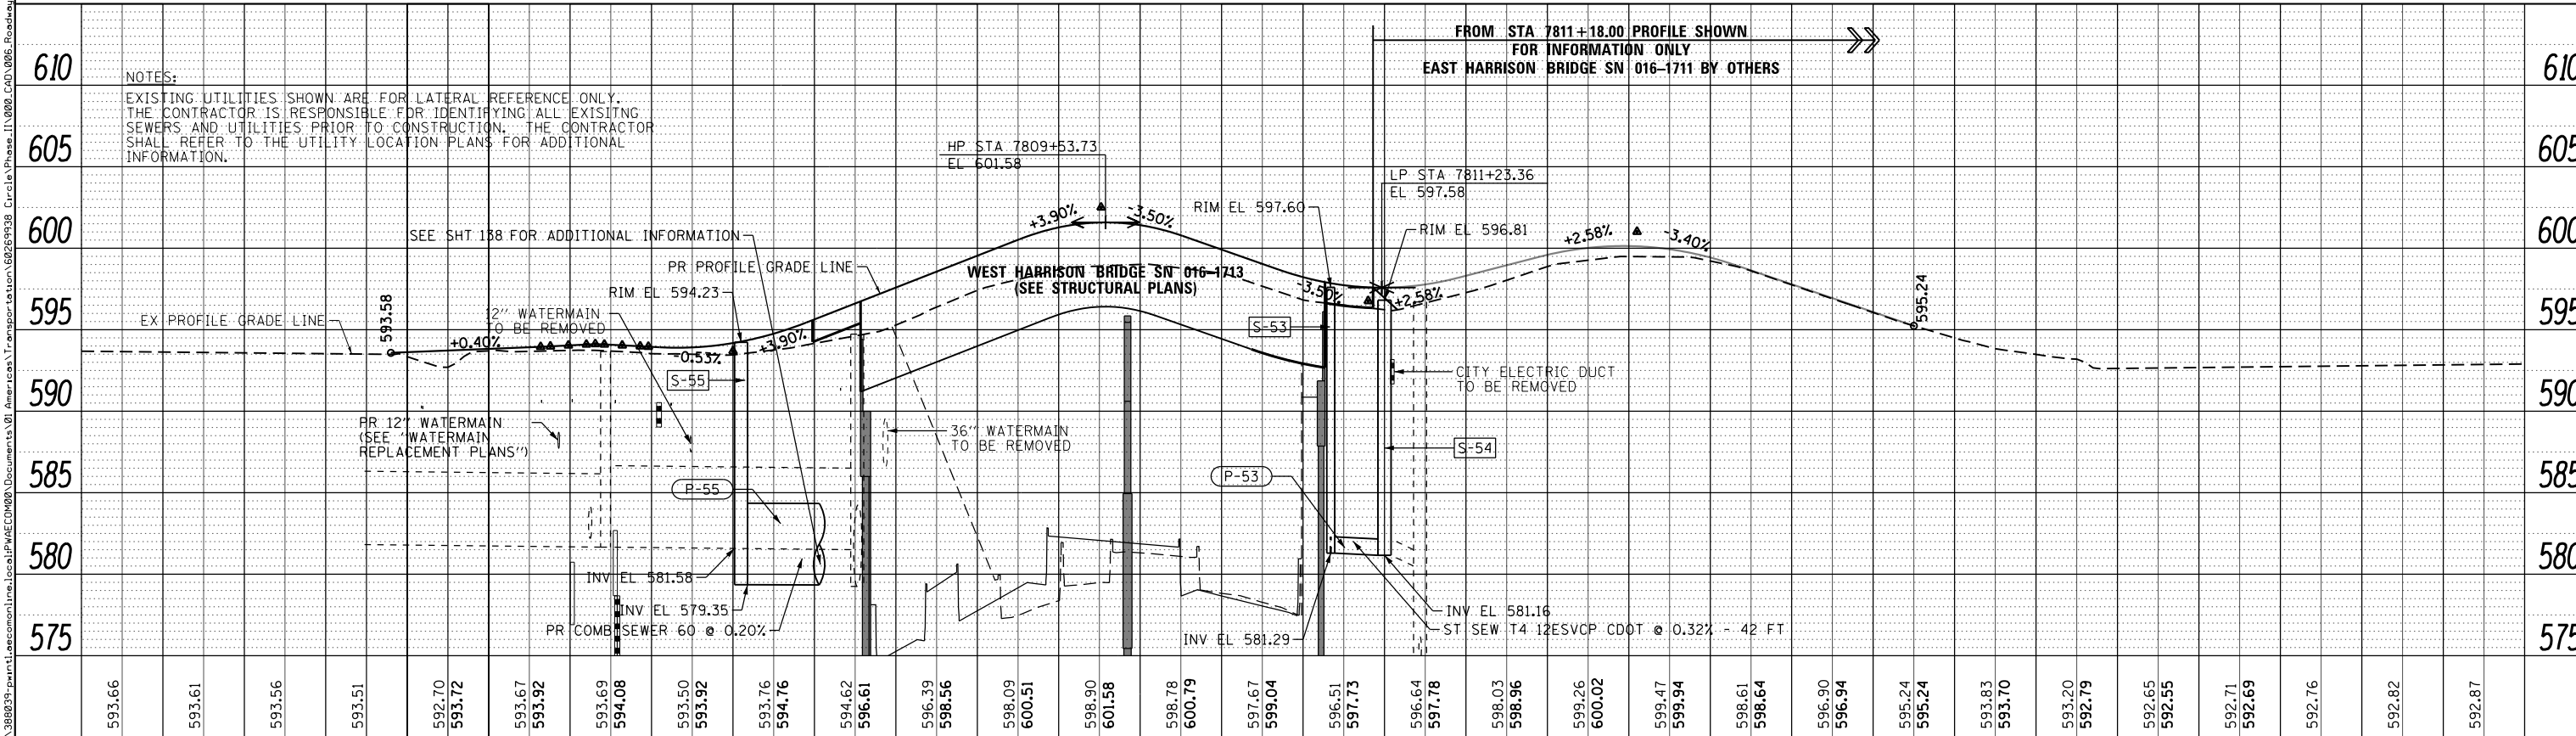

D160W26-sht-Drain-06.dgn
 USER NAME = chitua
 PLOT SCALE = 50.0000' / in.
 PLOT DATE = 9/12/2013

DESIGNED - AFC/MSC
 DRAWN - AFC/DMS
 CHECKED - DBM
 DATE - 09/15/13

REVISED -
 REVISED -
 REVISED -
 REVISED -

STATE OF ILLINOIS
 DEPARTMENT OF TRANSPORTATION

DRAINAGE AND UTILITY PLAN AND PROFILE
 HARRISON STREET
 SCALE: 1"=50'
 SHEET 6 OF 10 SHEETS STA. TO STA.

F.A.I. RTE.	SECTION	COUNTY	TOTAL SHEETS	SHEET NO.
90/94/290	2013-008R	COOK	559	135
CONTRACT NO. 60W26				
ILLINOIS FED. AID PROJECT				